

Conditions Legend

Concrete Deterioration

Biogrowth



Crack

Ferrous Staining

Metal Deterioration

Pipe End

The Conditions Legend is specific to the subject building of each report and conditions drawing set.

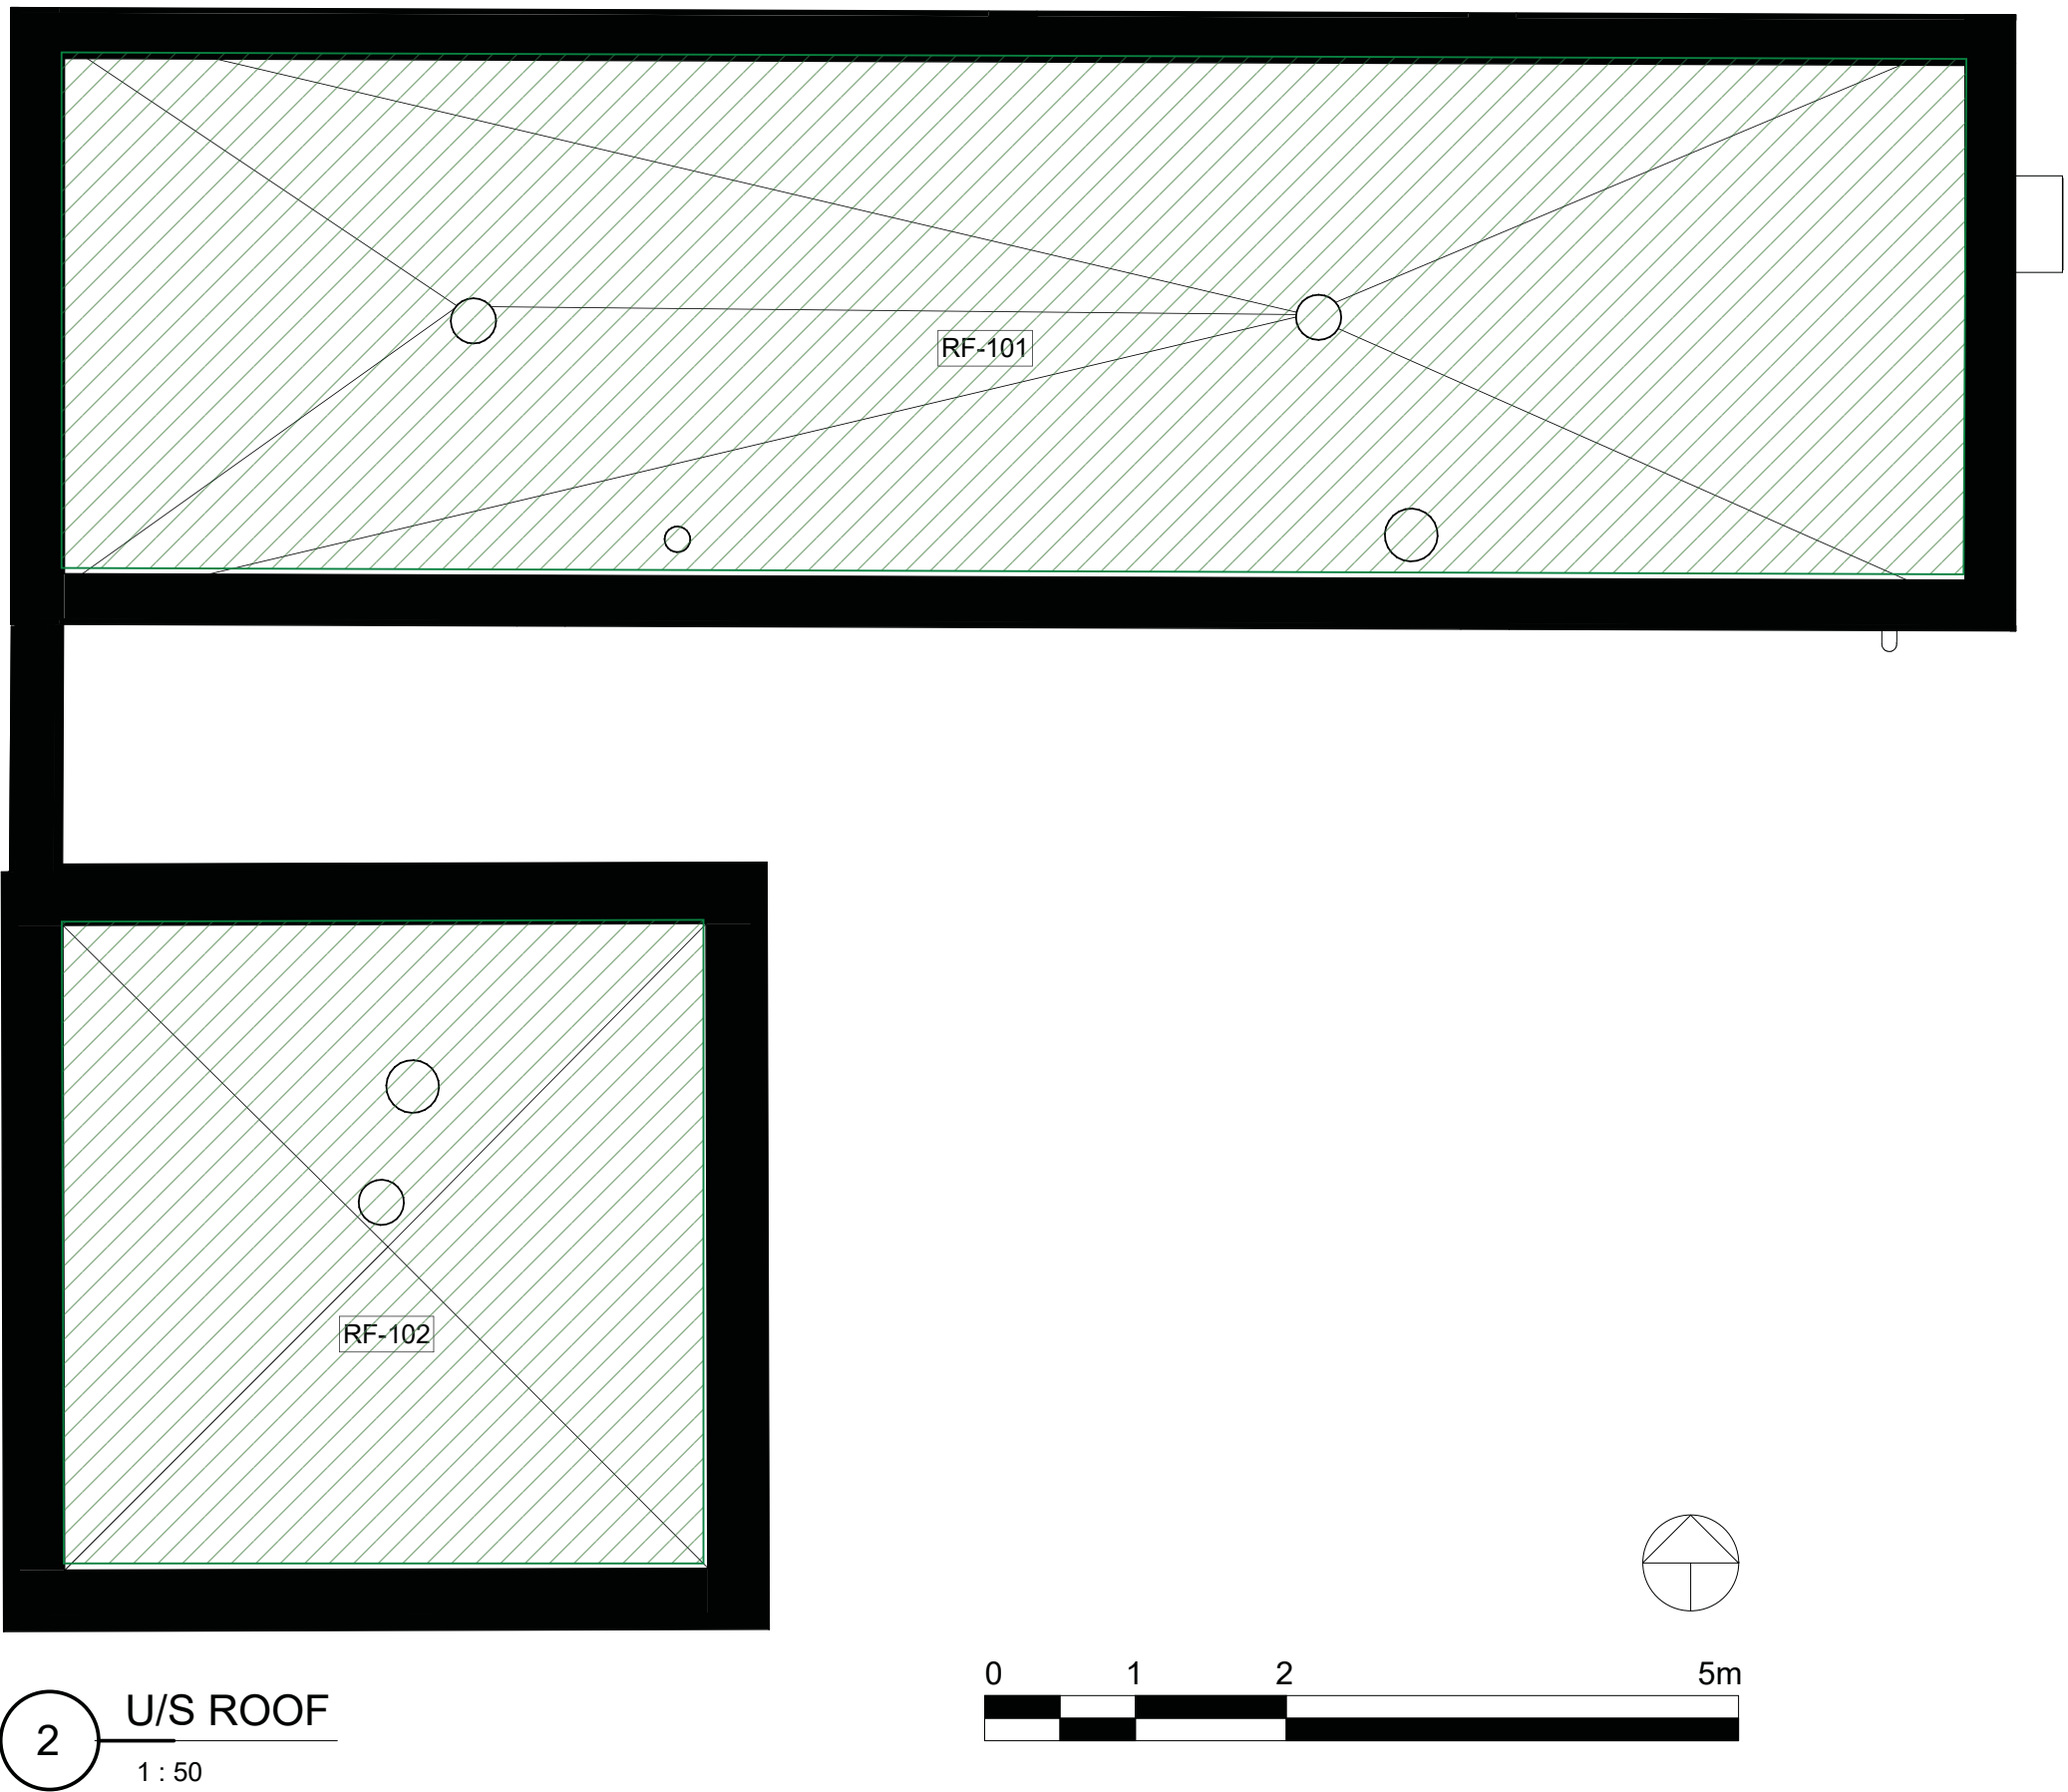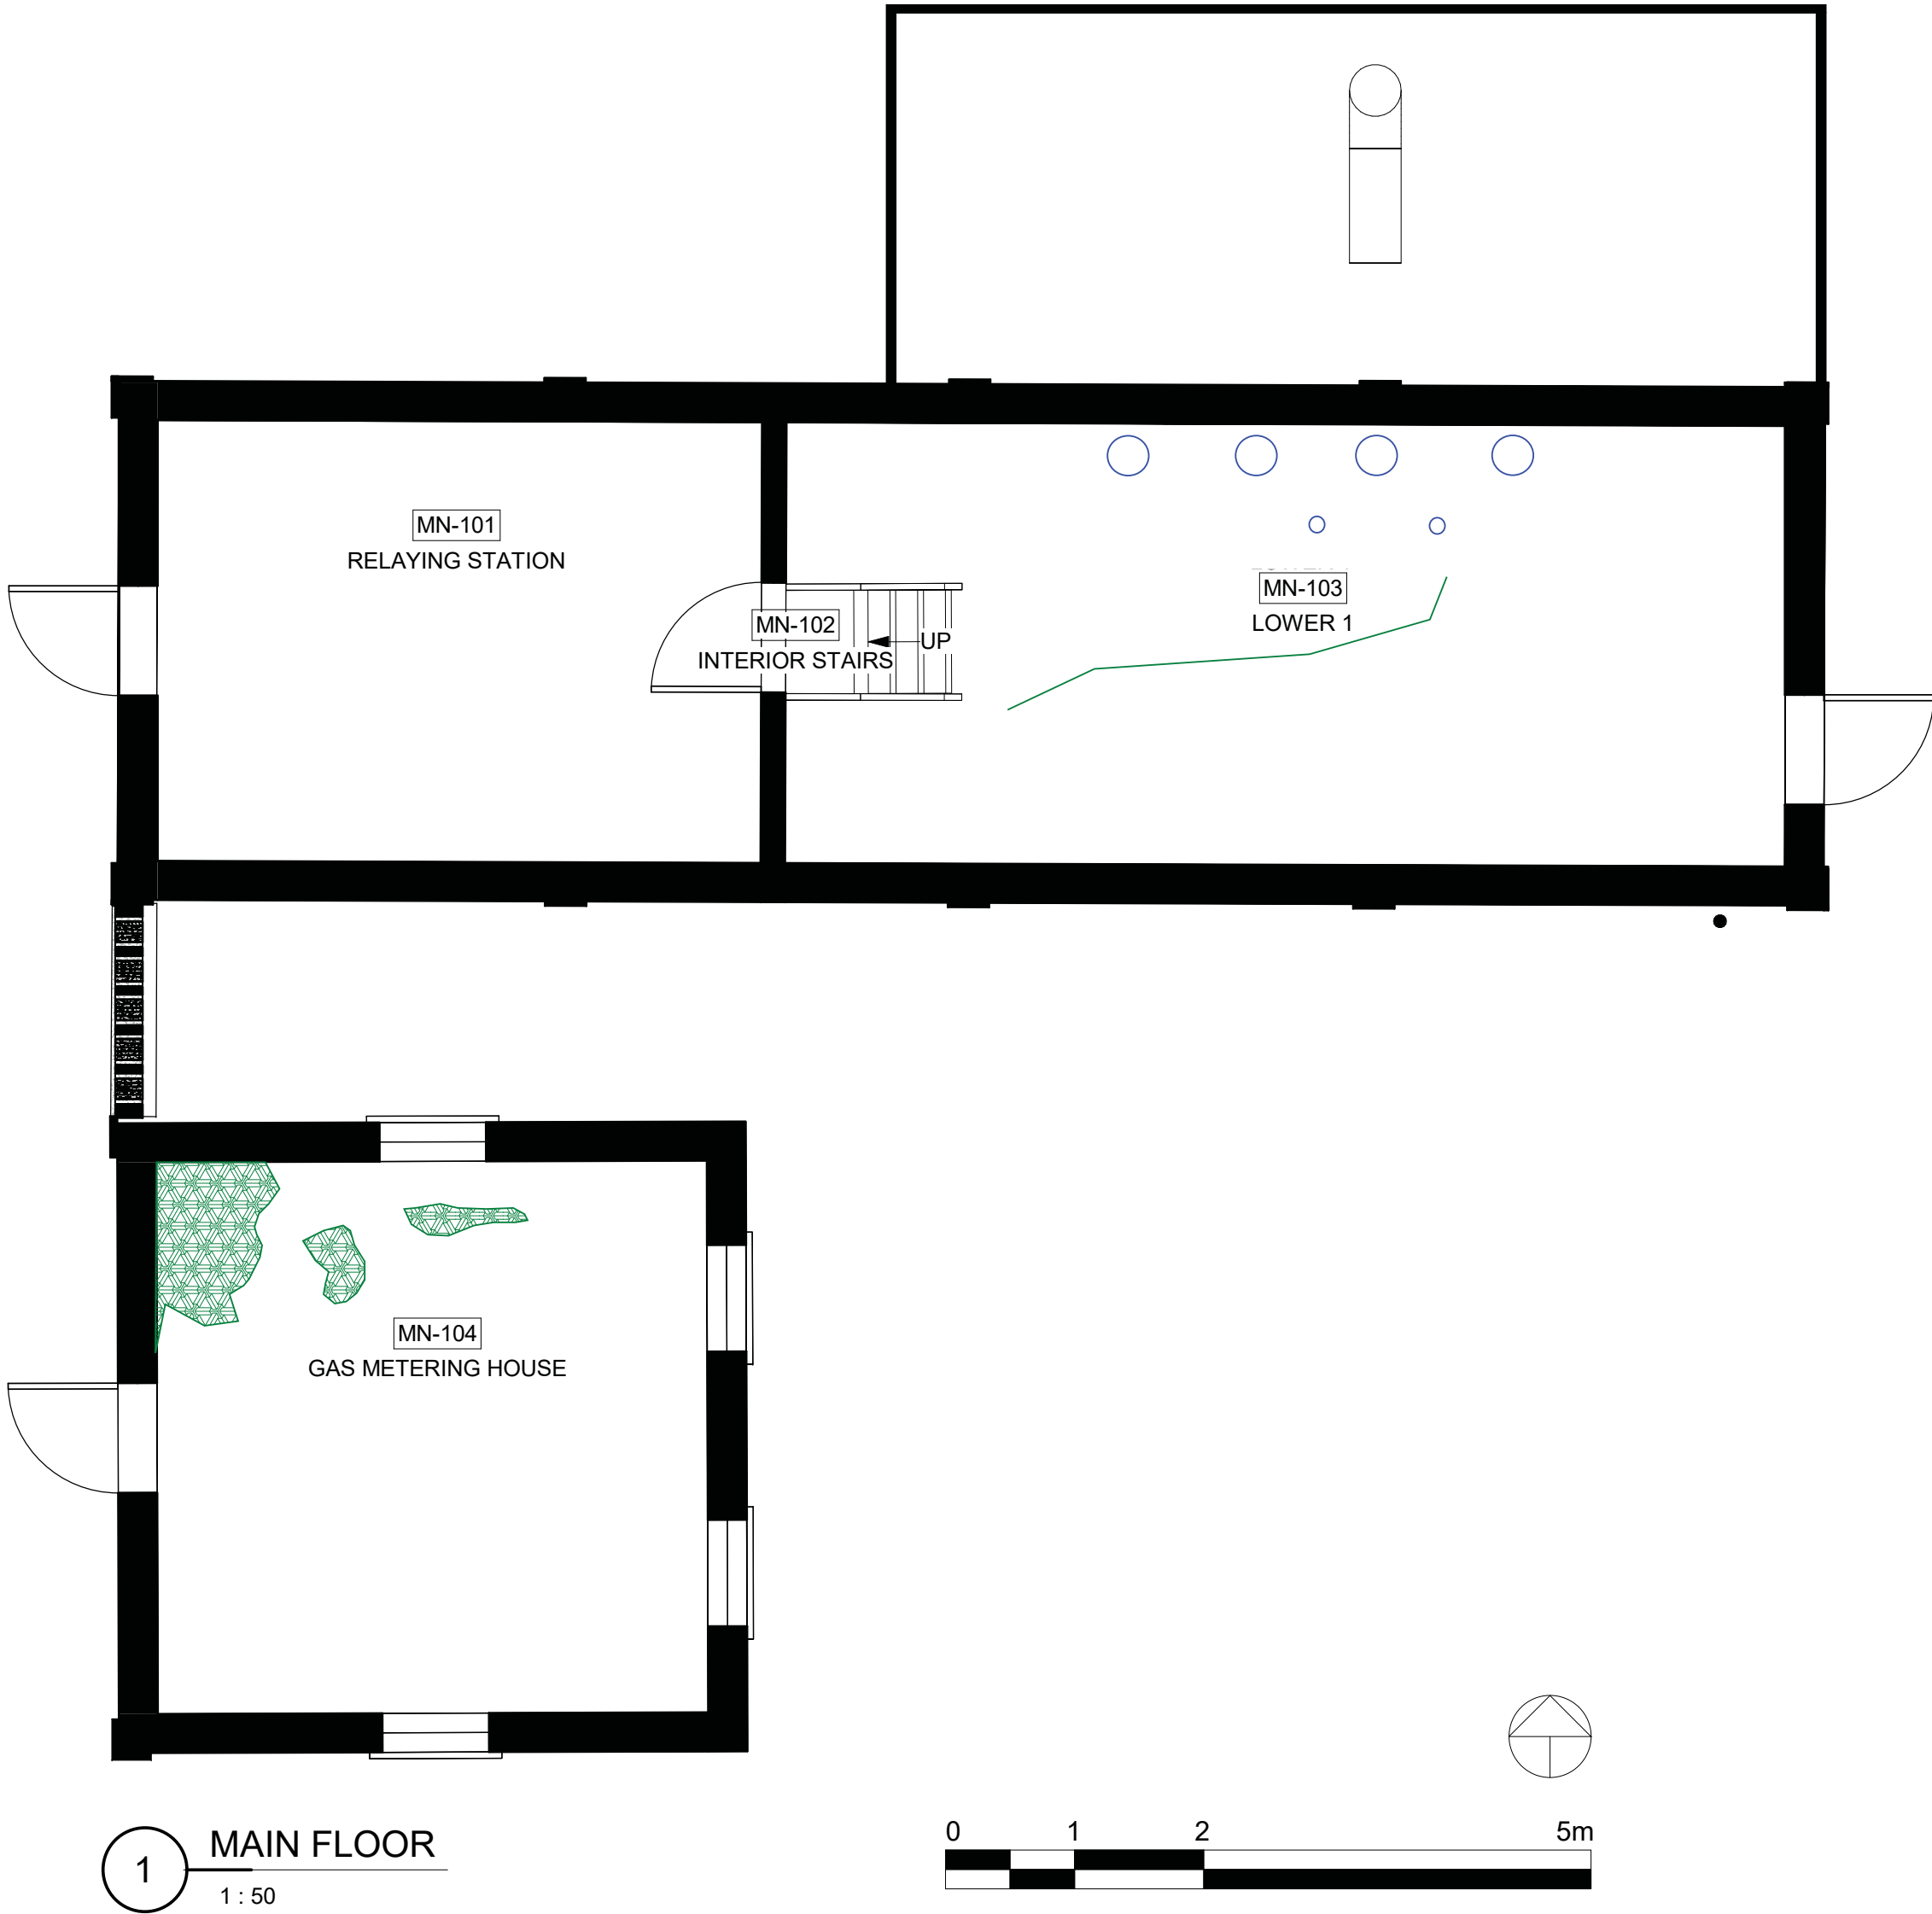

HATCH LEGEND

CHAIN LINK FENCE

PLYWOOD

OPEN TO BELOW

MASKED REGION

PROJECTING SURFACE

CUT SURFACE

Consultant

PRIME CONSULTANT/ARCHITECTURAL

the marc boutin architectural collaborative inc.

10085 Jasper Ave #200,

205 9th Avenue SE, Suite 100

Calgary, AB, T2C 0R3

Contact: Richard Coder

MECHANICAL/ELECTRICAL

Williams Engineering Canada Inc.

10085 Jasper Ave #200,

Edmonton, AB T5J 3B1

Contact: Sheldon Samborsky (M), Ben Rajewski (E)

HERITAGE

DPS Inc. Architecture & Design

400 Boulevard de Maisonneuve O,

Montreal, QC H3A 1L4

Contact: Evan Ostend

BUILDING/FIRE CODE

Jensen Hughes

5855 9 St SE #106,

Calgary, AB T2H 1Z3

Contact: Kyle Duckworth

ARCHITECTURAL

Saucier + Perrotte Architects

7043 Waverly St,

Montreal, QC H2S 3J1

Contact: Anna-Marie Saucier

COST

BTY Group

404 8 Ave SW #645,

Calgary, AB T2P 0R9

Contact: Michael Giesert

STRUCTURAL/CIVIL/BUILDING ENVELOPE

Road Jones Christofferson Ltd

17415 102 Ave NW #100,

Edmonton, AB T5S 1J6

Contact: Frank Cavaliere (S), John Balla (C), Nick Trovati (BE)

INDIGENITY

Nahwegah

1205 - 10903 103 Ave NW,

Edmonton, Alberta, T5K 2K6

Contact: Hunter Cardinal

CONSULTANT PROJECT 20008

Seal	Permit
	PRELIMINARY NOT FOR CONSTRUCTION

Edmonton

ROSSDALE POWER PLANT
ADVANCED ASSESSMENT AND
PRIORITY REHABILITATION -
HISTORIC BUILDING RECORD

CP-9496

Department	INTEGRATED INFRASTRUCTURE SERVICES
------------	------------------------------------

No.	Description	Date
1	Conditions Assessment Revision 1	01/20/2021
2	Conditions Assessment Revision 2	01/28/2021
3	Conditions Assessment Revision 3	03/04/2021
4	Conditions Assessment Revision 4	03/09/2021
5	Conditions Assessment Revision 5	04/29/2021

Location ID	ROS112
Description	ATCO GAS BUILDING - CONDITIONS ASSESSMENT

Drawing Title	ATCO FLOOR PLANS
---------------	------------------

Discipline	HERITAGE	Drawn	B.H.
Volume		Drawing Number	
Sheet	H250		
File			