

Conditions Legend







Concrete Deterioration

Soil Deposits

Metal Deterioration

Corrosion

The Conditions Legend is specific to the subject building of each report and conditions drawing set

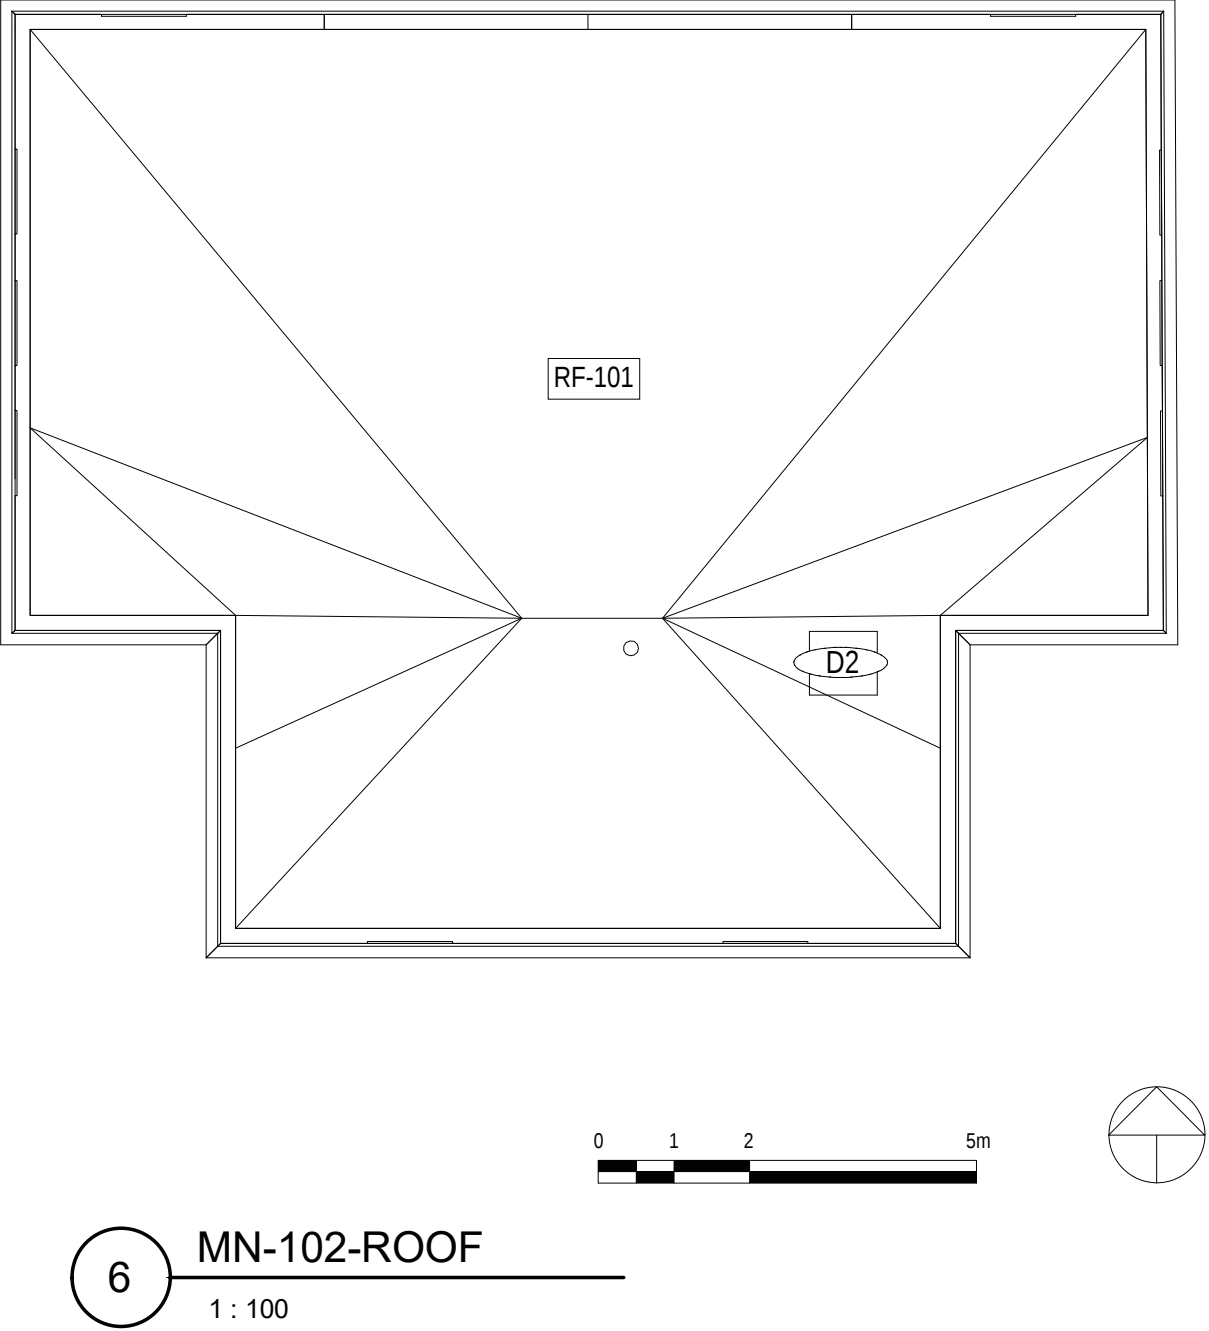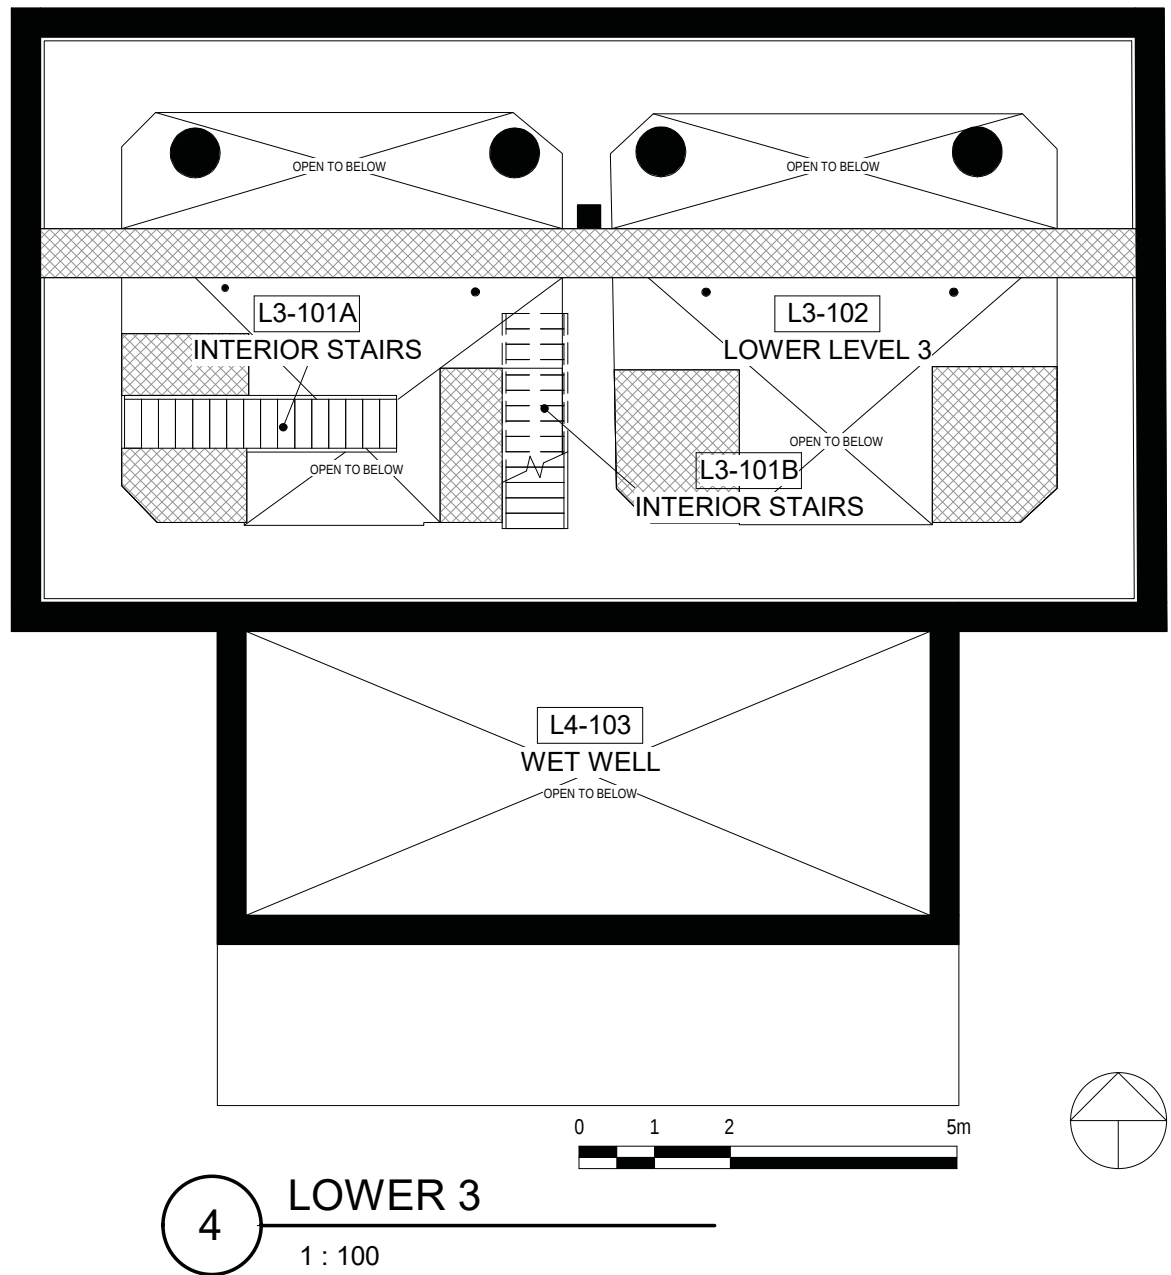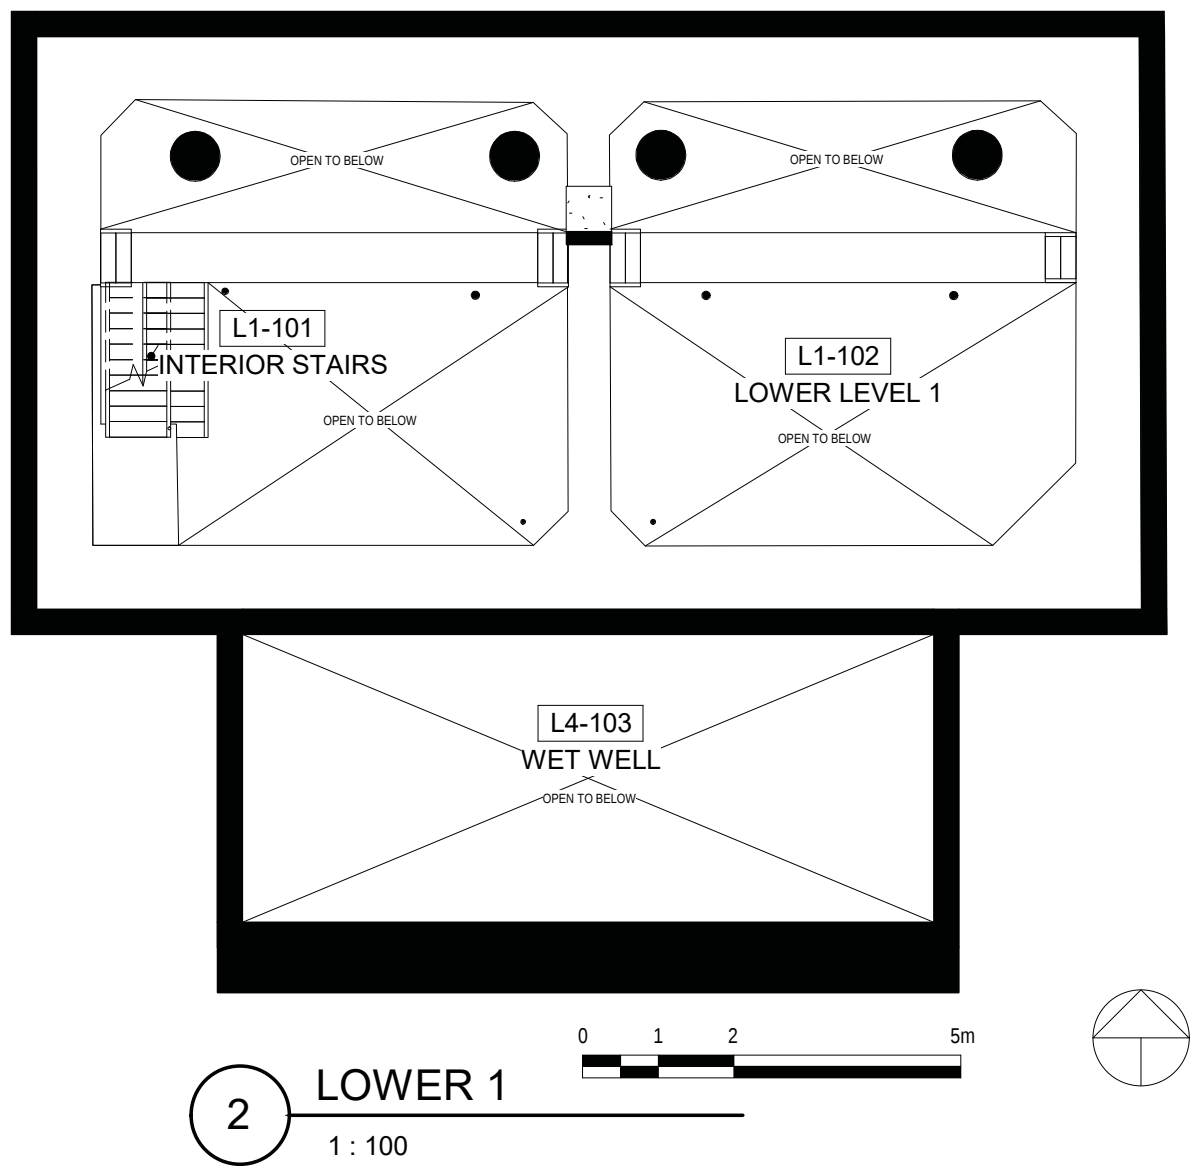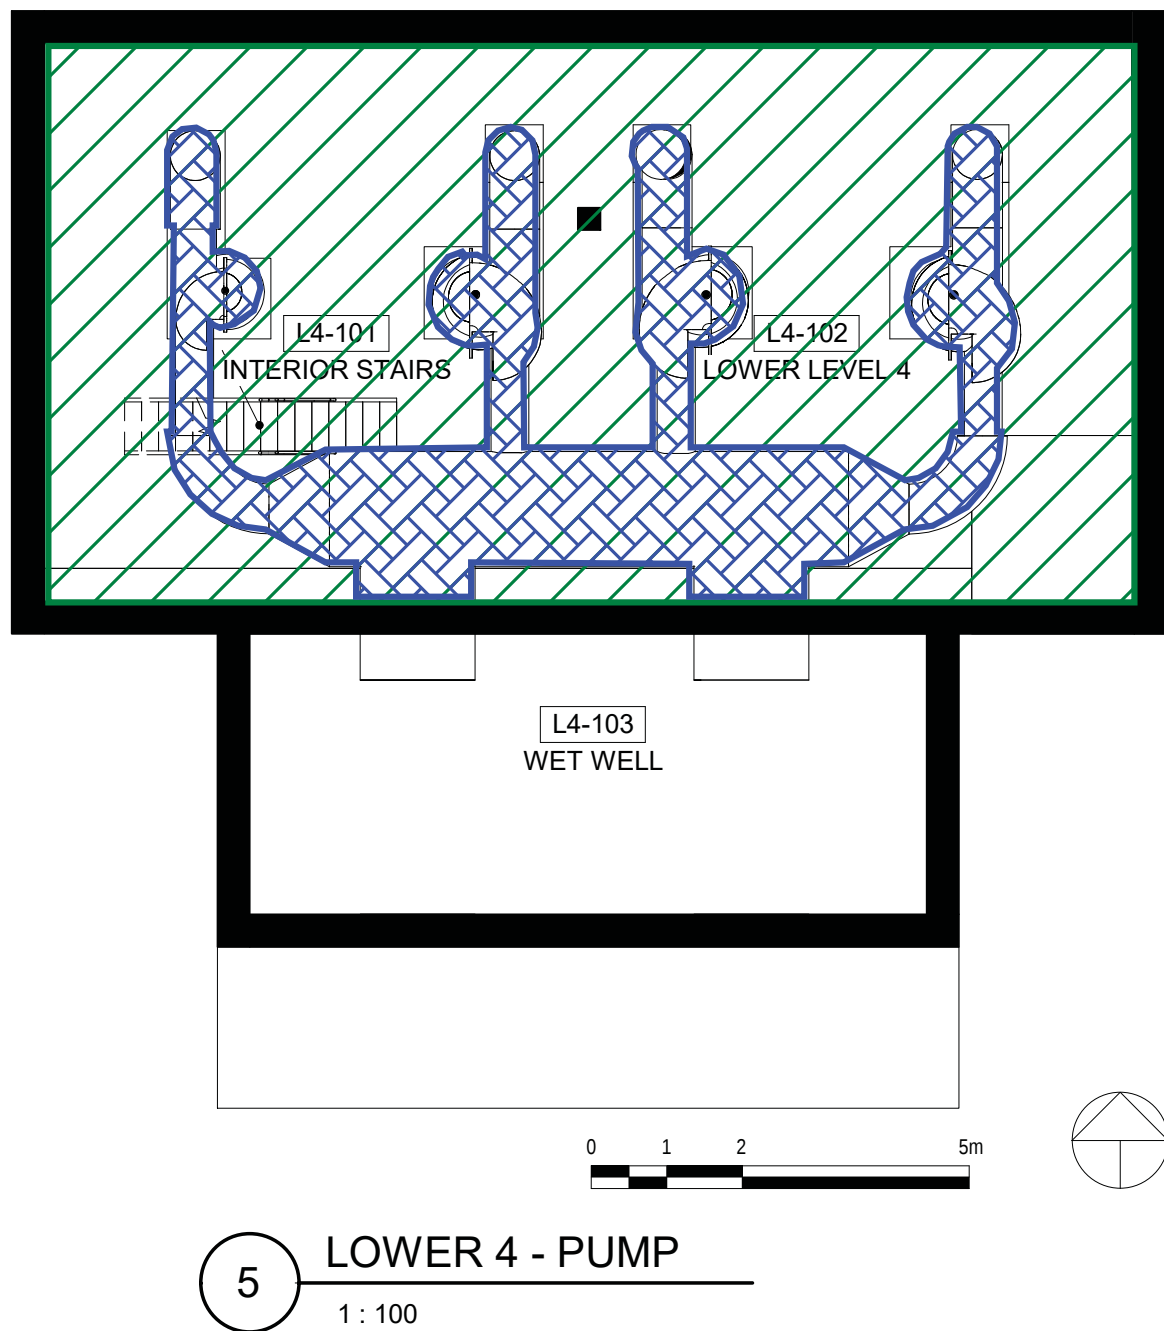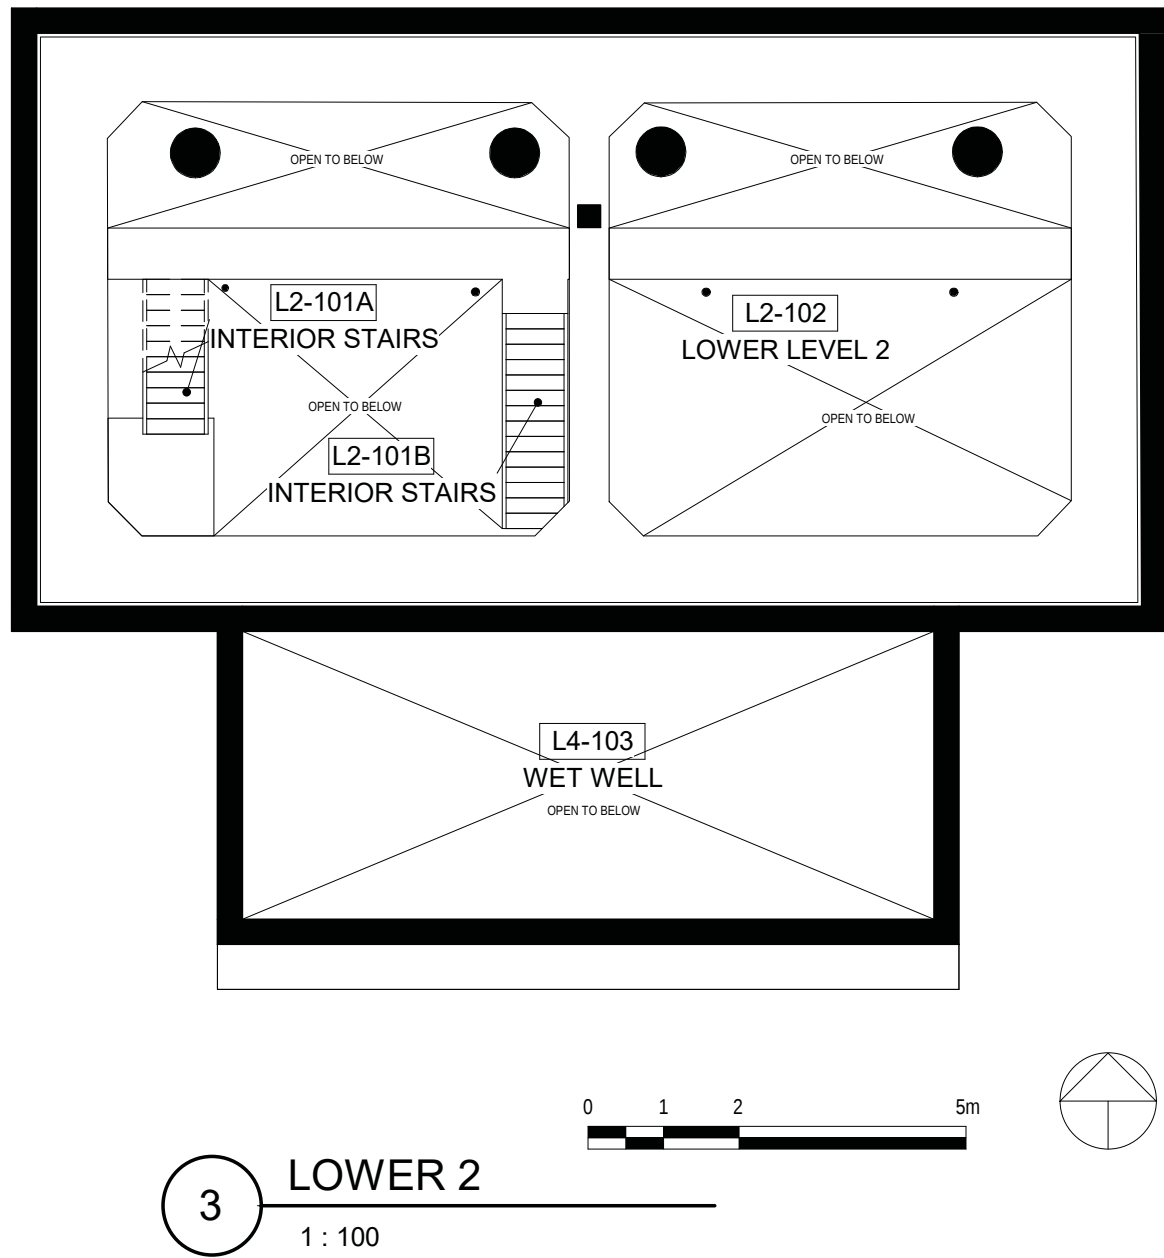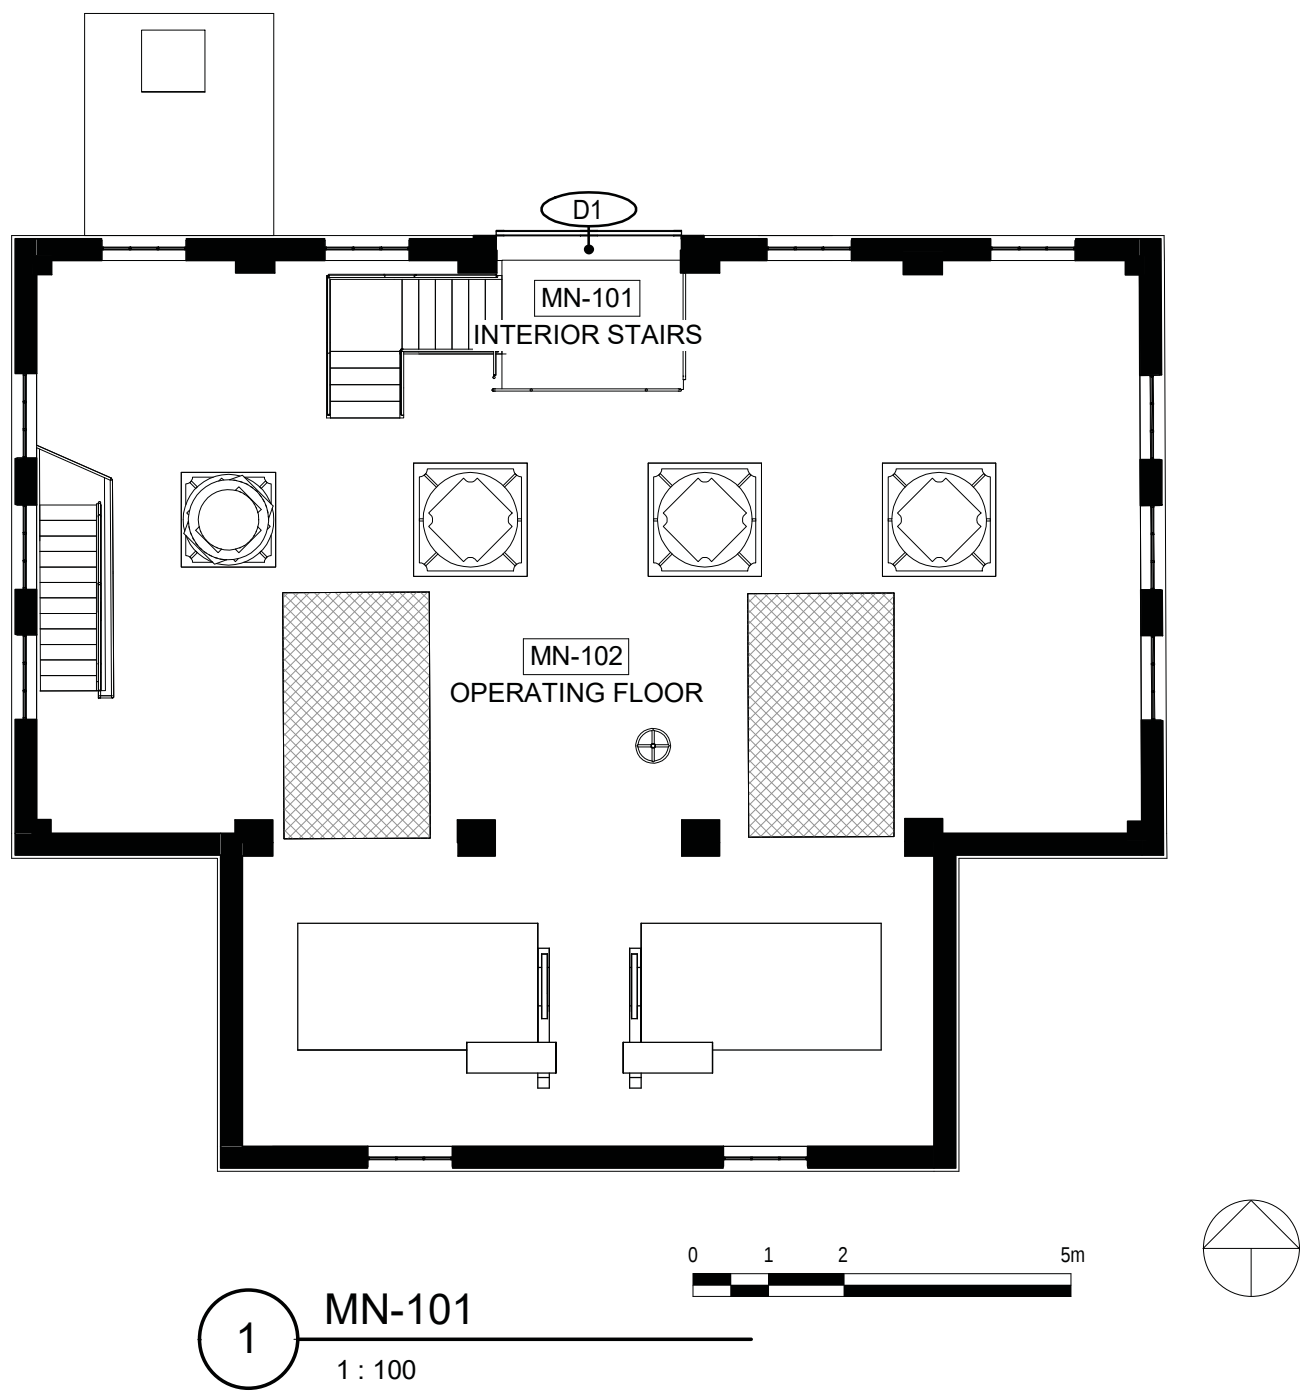

HATCH LEGEND

- CONCRETE
- METAL
- PLYWOOD
- OPEN TO BELOW
- MASKED REGION
- PROJECTING SURFACE
- CUT SURFACE

Consultant

PRIME CONSULTANT/ARCHITECTURAL
the marc boutin architectural collaborative inc.
10085 Jasper Ave #200,
205 9th Avenue SE, Suite 100
Calgary, AB, T2C 0R3
Contact: Richard Coder

MECHANICAL/ELECTRICAL
Williams Engineering Canada Inc.
10085 Jasper Ave #200,
Edmonton, AB T5J 3B1
Contact: Sheldon Samborsky (M), Ben Rajewski (E)

HERITAGE
DPS Inc. Architecture & Design
400 Boulevard de Maisonneuve O,
Montreal, QC H3A 1L4
Contact: Evan Ostend

ARCHITECTURAL
Saucier + Perrotte Architectes
7043 Waverly St,
Montreal, QC H2S 3J1
Contact: Anne-Marie Saucier

STRUCTURAL/CIVIL/BUILDING ENVELOPE
Reed Jones Christofferson LLP
17415 102 Ave NW #100,
Edmonton, AB T5S 1J6
Contact: Frank Cavaliere (S), John Balla (C),
Nick Trovati (RE)

BUILDING/FIRE CODE
Jensen Hughes
5855 9 St SE #106,
Calgary, AB T2H 1Z9
Contact: Nyle Duckworth

COST
BTY Group
404 8 Ave SW #645,
Calgary, AB T2P 0R9
Contact: Michael Giesert

INDIGENITY
Nahayewit
1205 - 10903 103 Ave NW,
Edmonton, Alberta, T5K 2X6
Contact: Hunter Cardinal

MBAC
DFS

CONSULTANT PROJECT 20008

Seal

Permit

PRELIMINARY NOT FOR CONSTRUCTION

Edmonton

ROSSDALE POWER PLANT
ADVANCED ASSESSMENT AND
PRIORITY REHABILITATION -
HISTORIC BUILDING RECORD

CP-9496

Department

INTEGRATED INFRASTRUCTURE SERVICES

No.	Description	Date
4	CORRECTION	2021-04-29

Location ID

ROS108

Description

PUMP HOUSE #1
CONDITION ASSESSMENT

Drawing
Title

PLANS

Discipline	HERITAGE	Drawn	KC
Volume		Drawing Number	
Sheet	H250		
File			

Conditions Legend

Concrete Deterioration

Cementitious Patch

Cold Joint

Crack

Efflorescence

Exposed Rebar

Graffiti

Honeycomb

Incipient Spall

Overpaint

Relict Wood Anchor

Spall

Waterproofing

Metal Deterioration

Corrosion

Exposed Rebar Ends

Failed Ferrous Fixture

Ferrous Fixture

Window Deterioration


Plywood Cover

Wood Deterioration


Paint Failure

Wood Decay


The Conditions Legend is specific to the subject building of each report and conditions drawing set

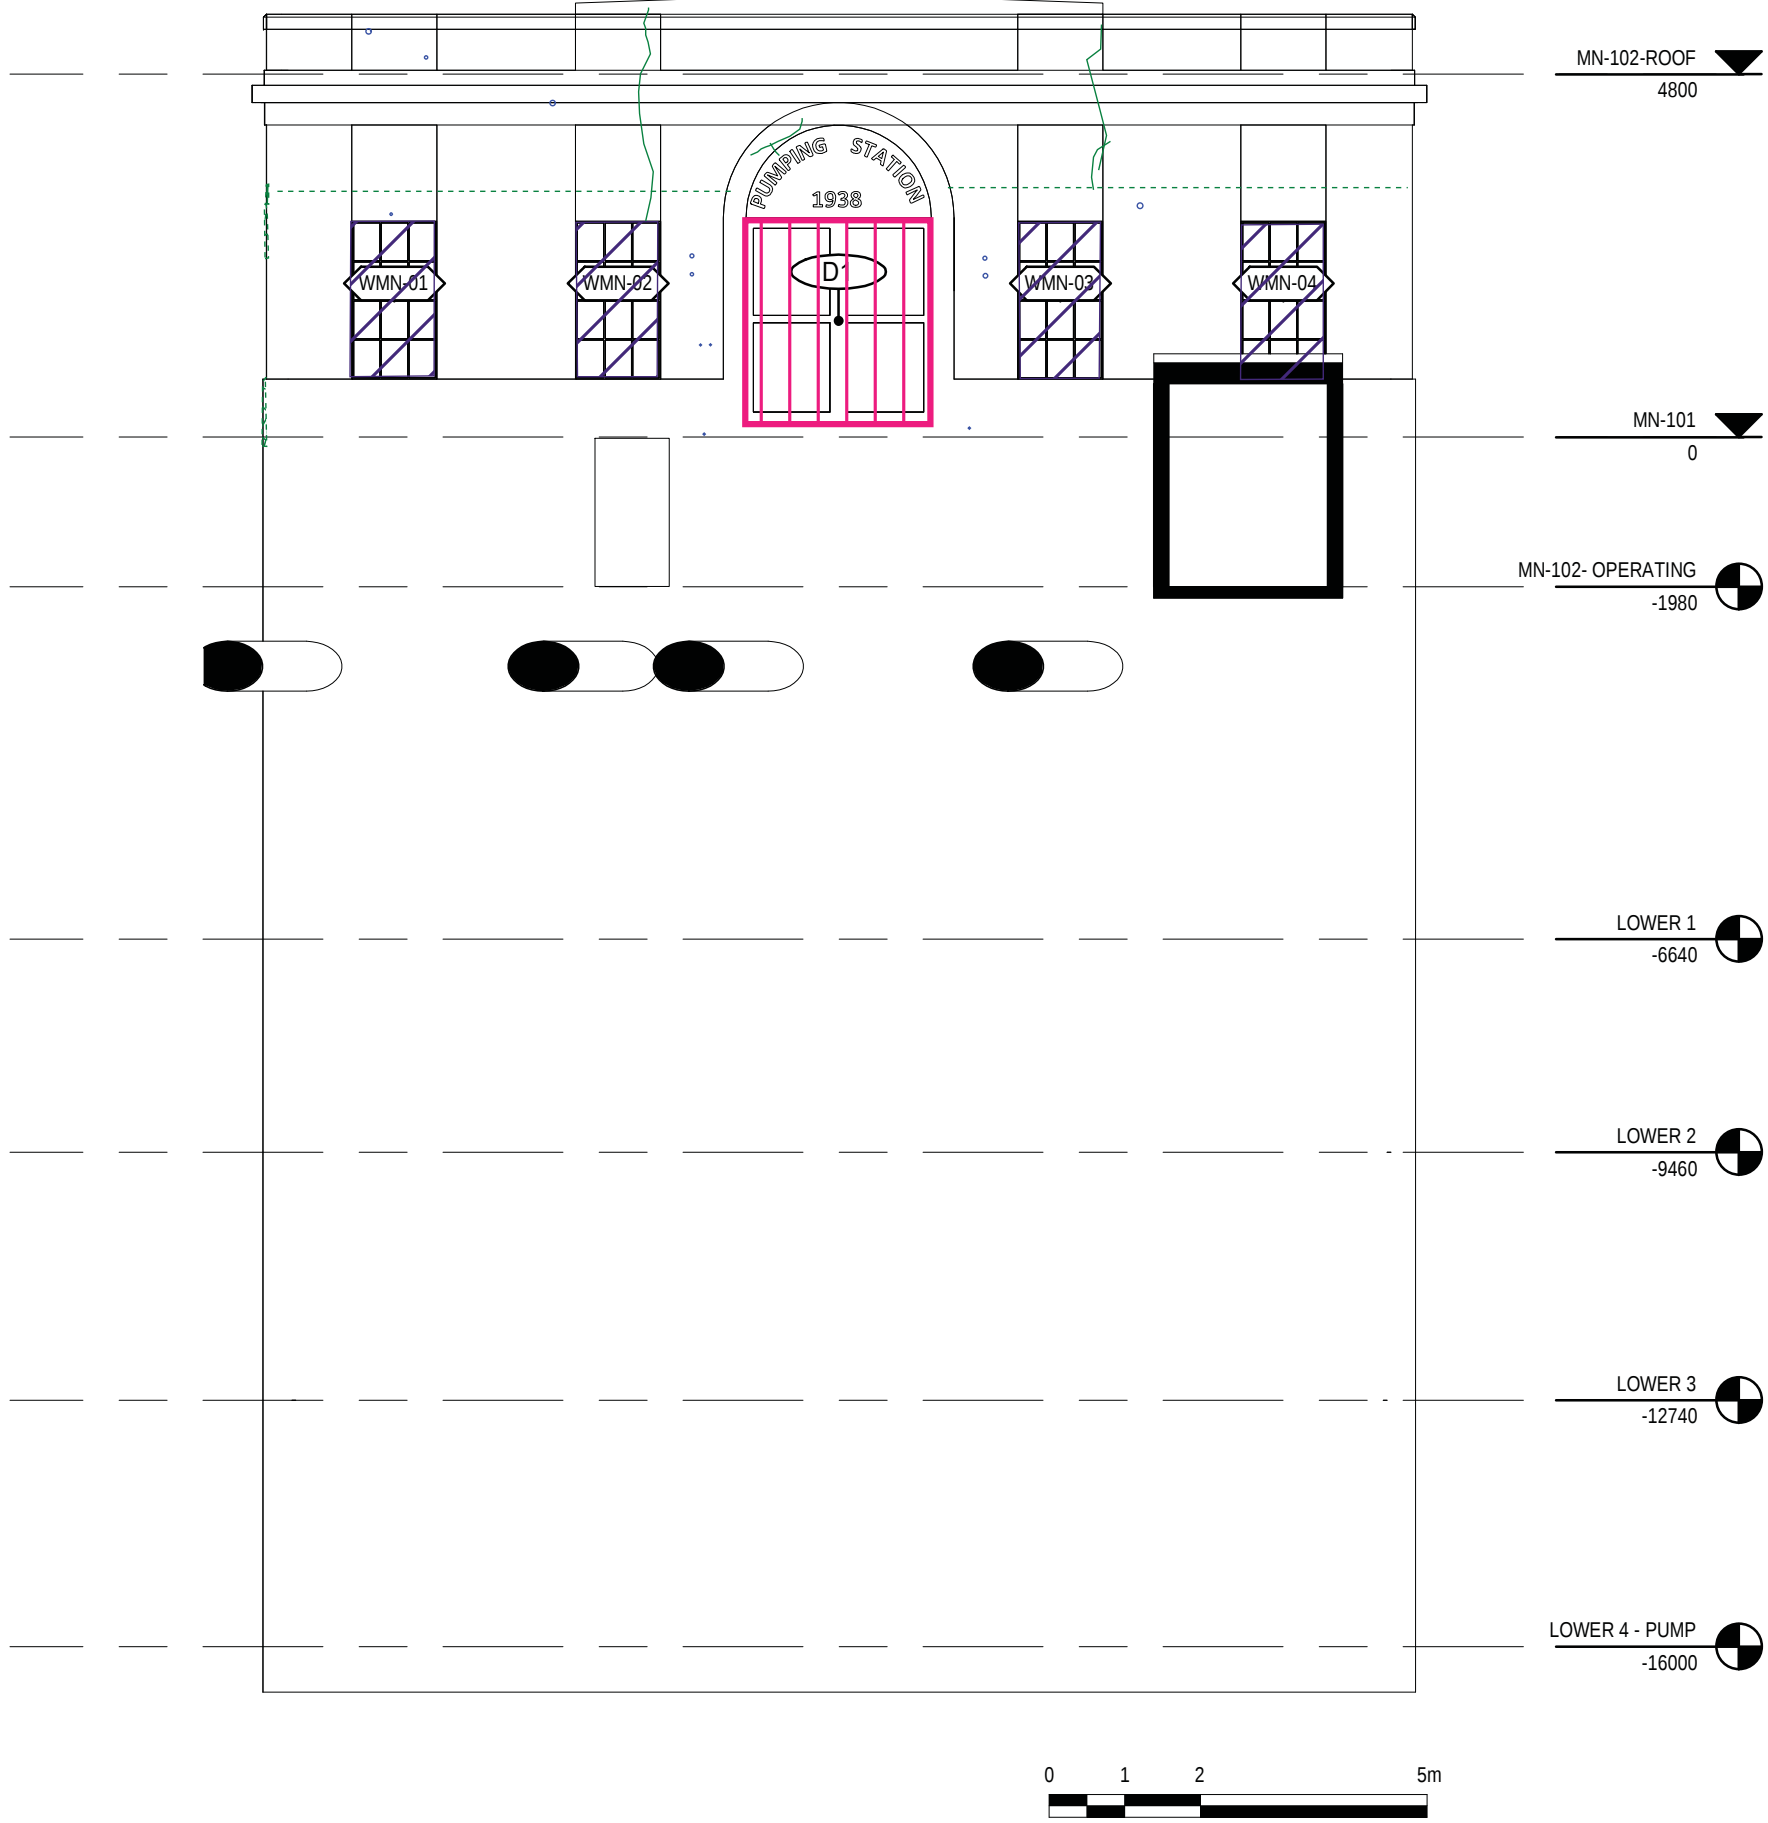


1 ELEVATION NORTH
1 : 100

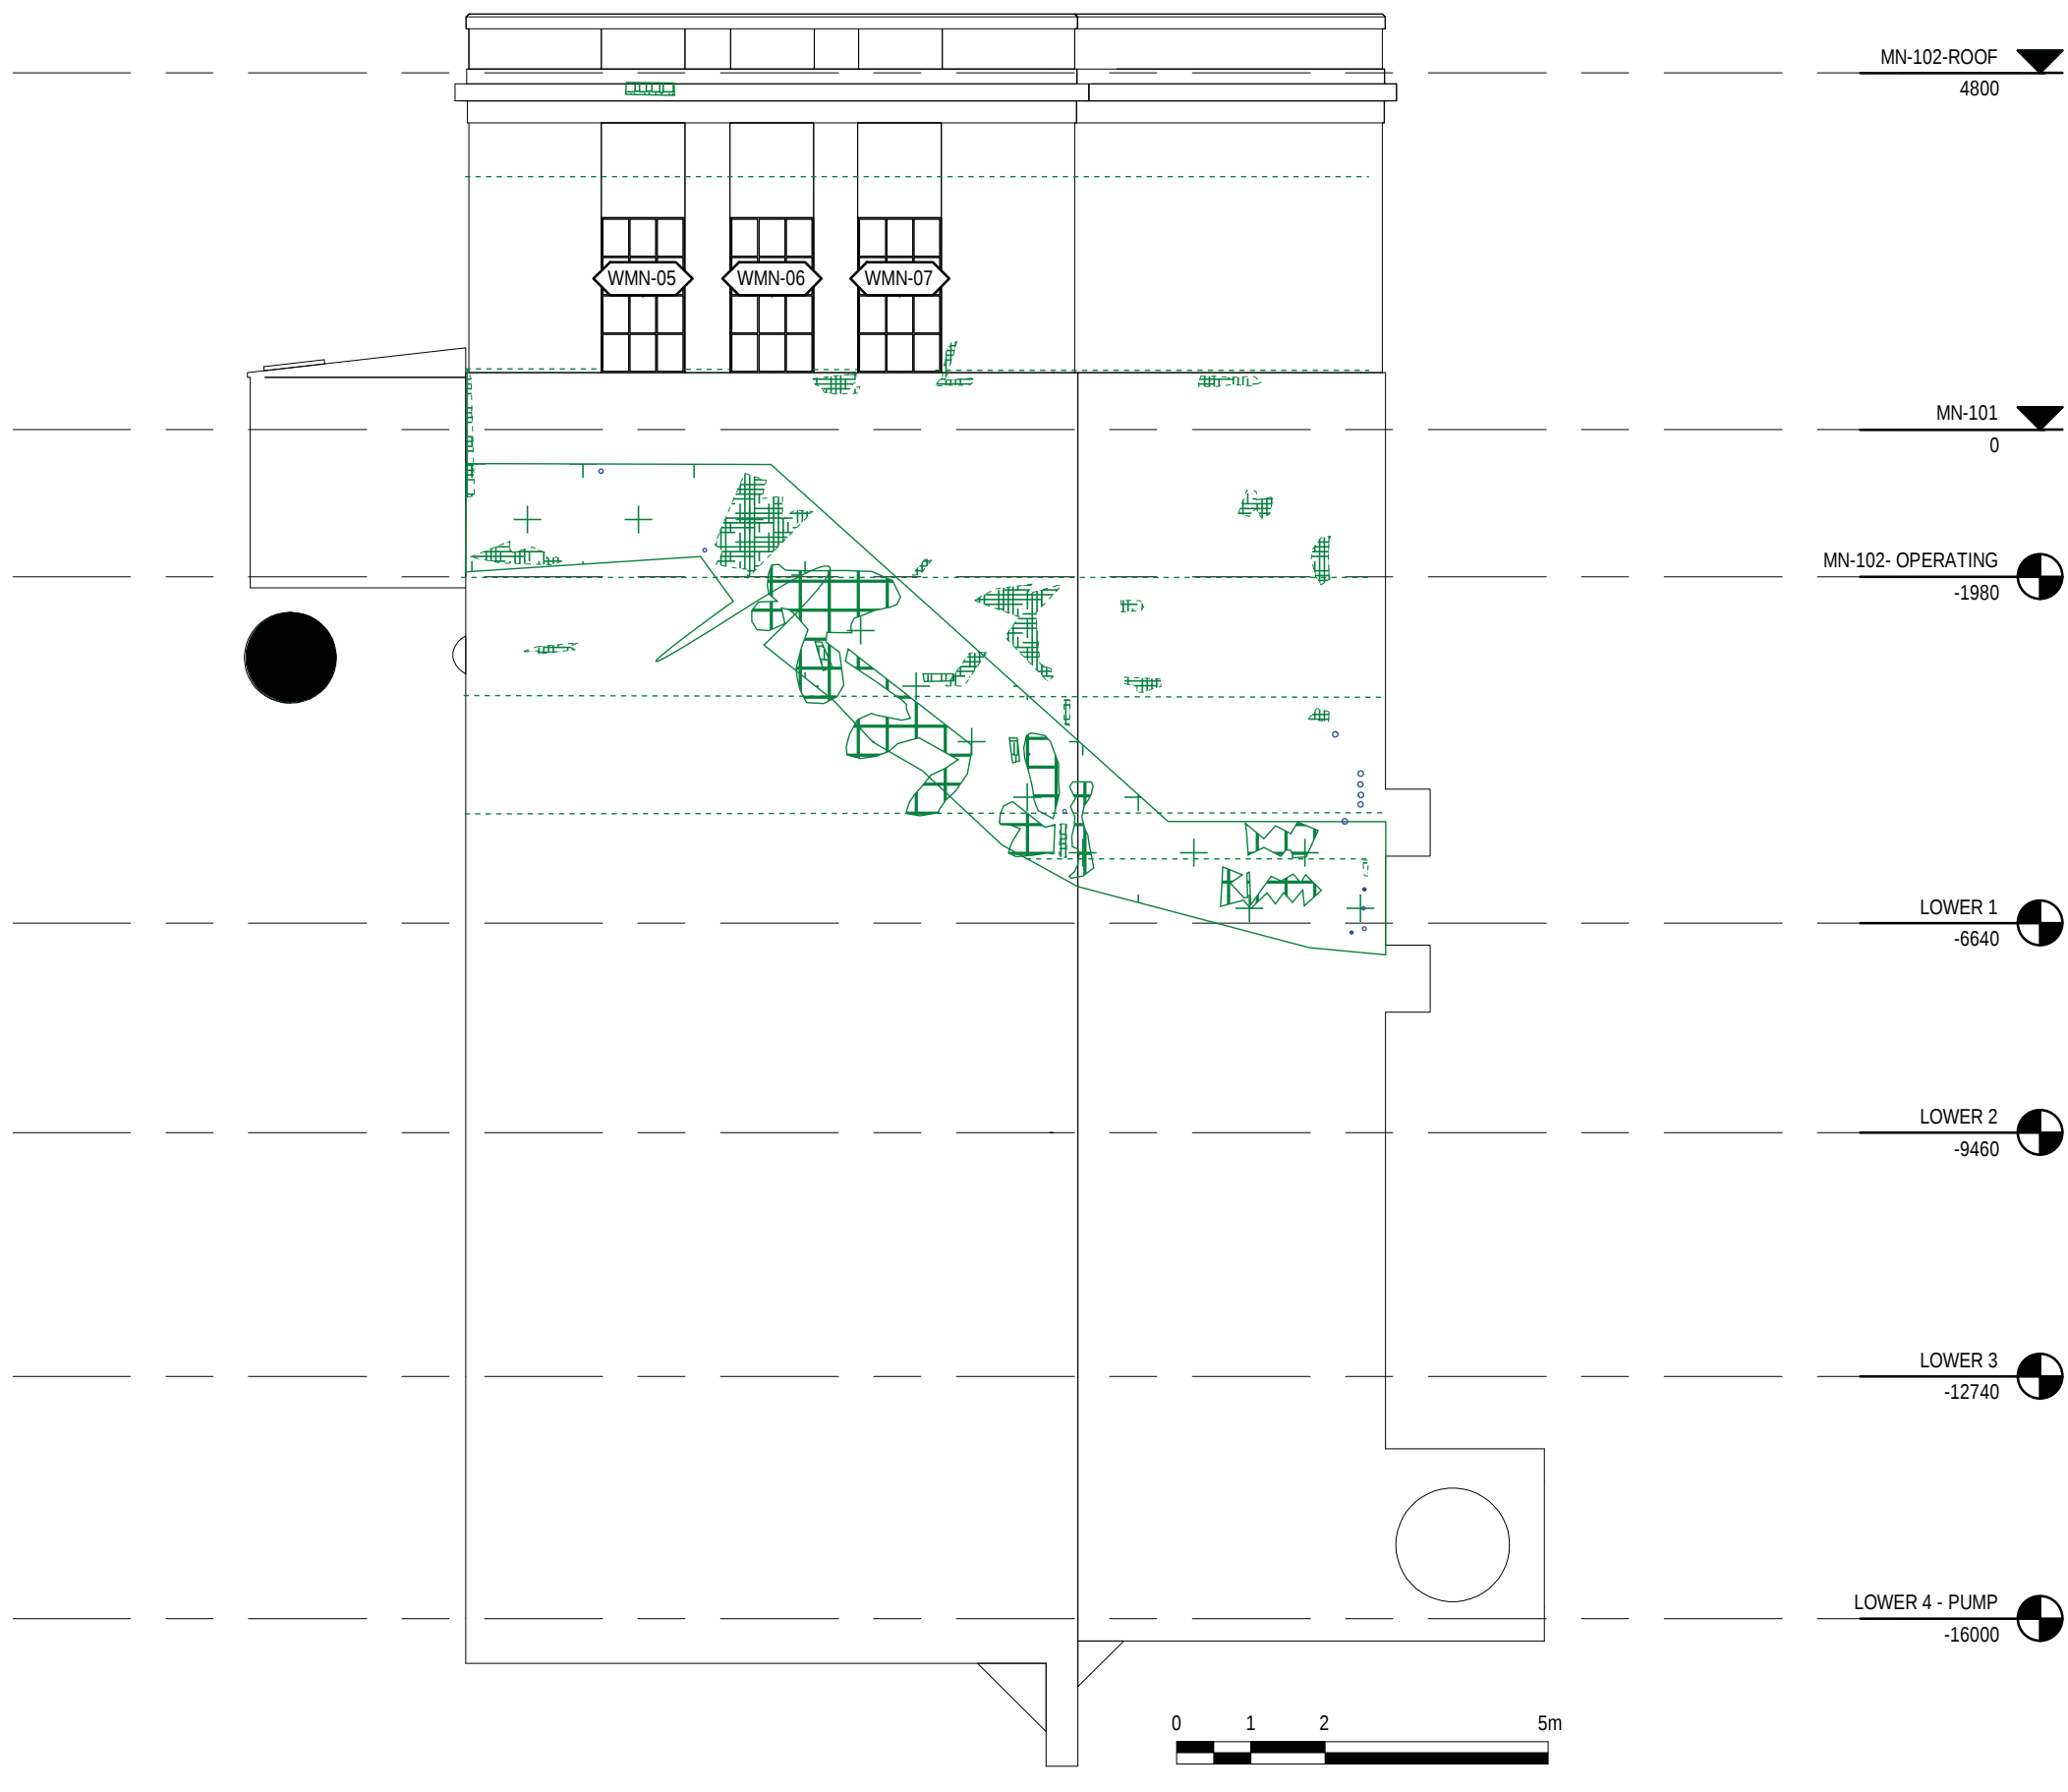

2 ELEVATION EAST
1 : 100

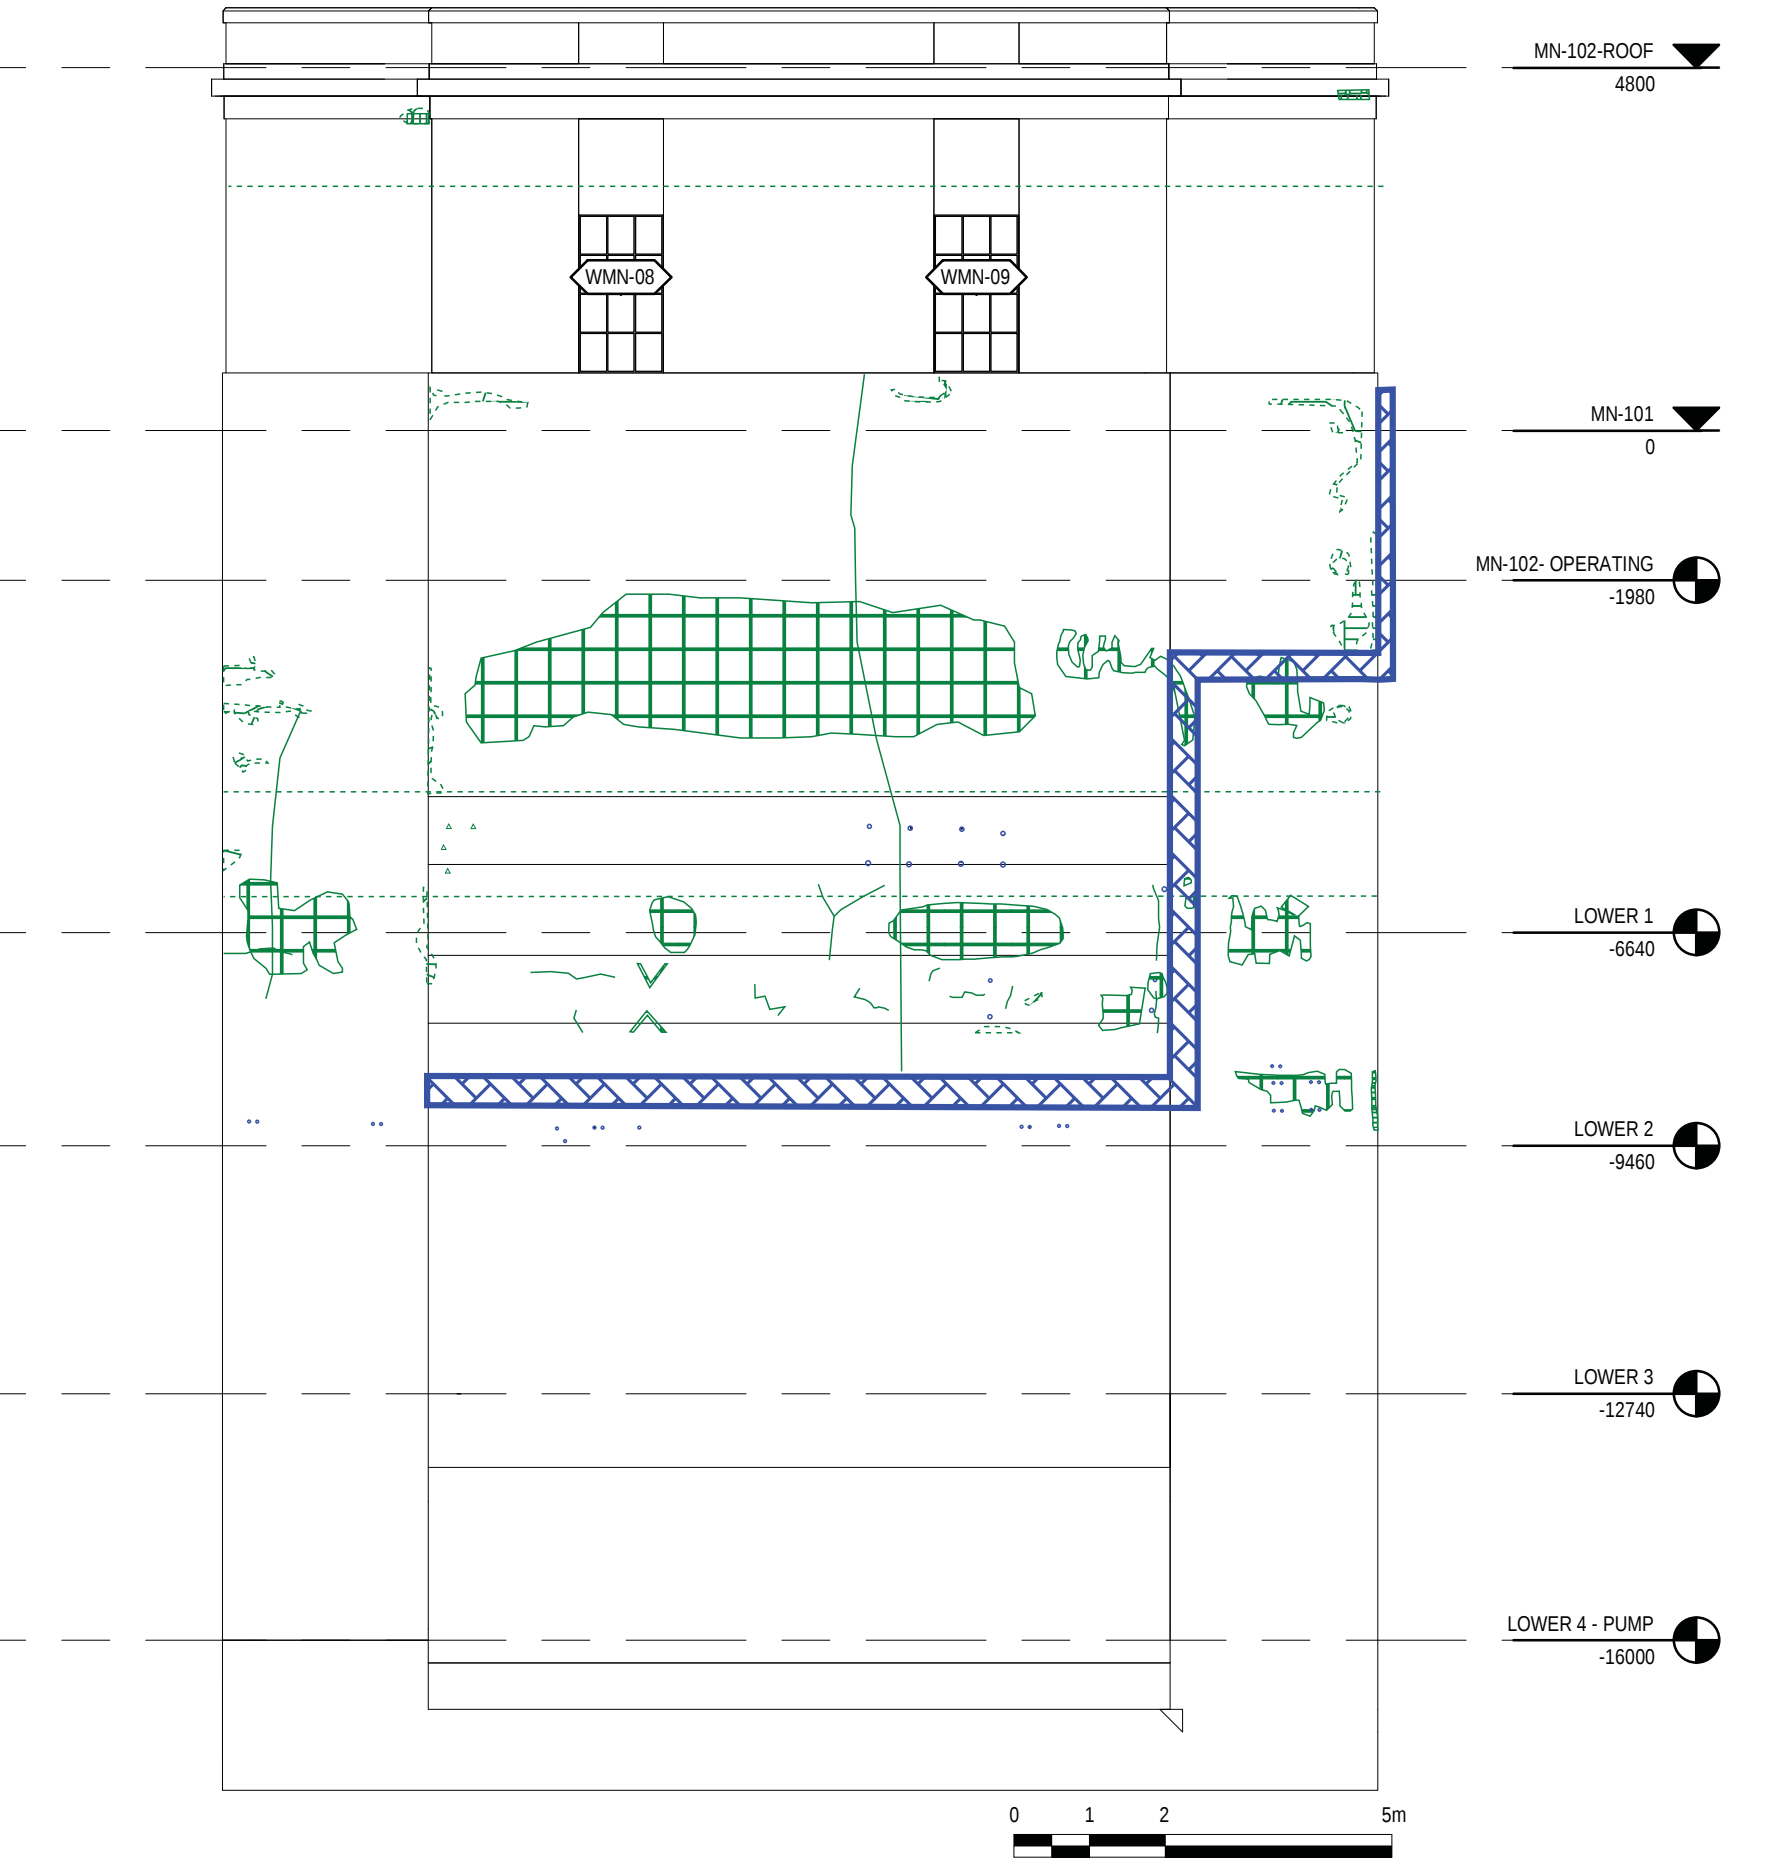

3 ELEVATION SOUTH
1 : 100

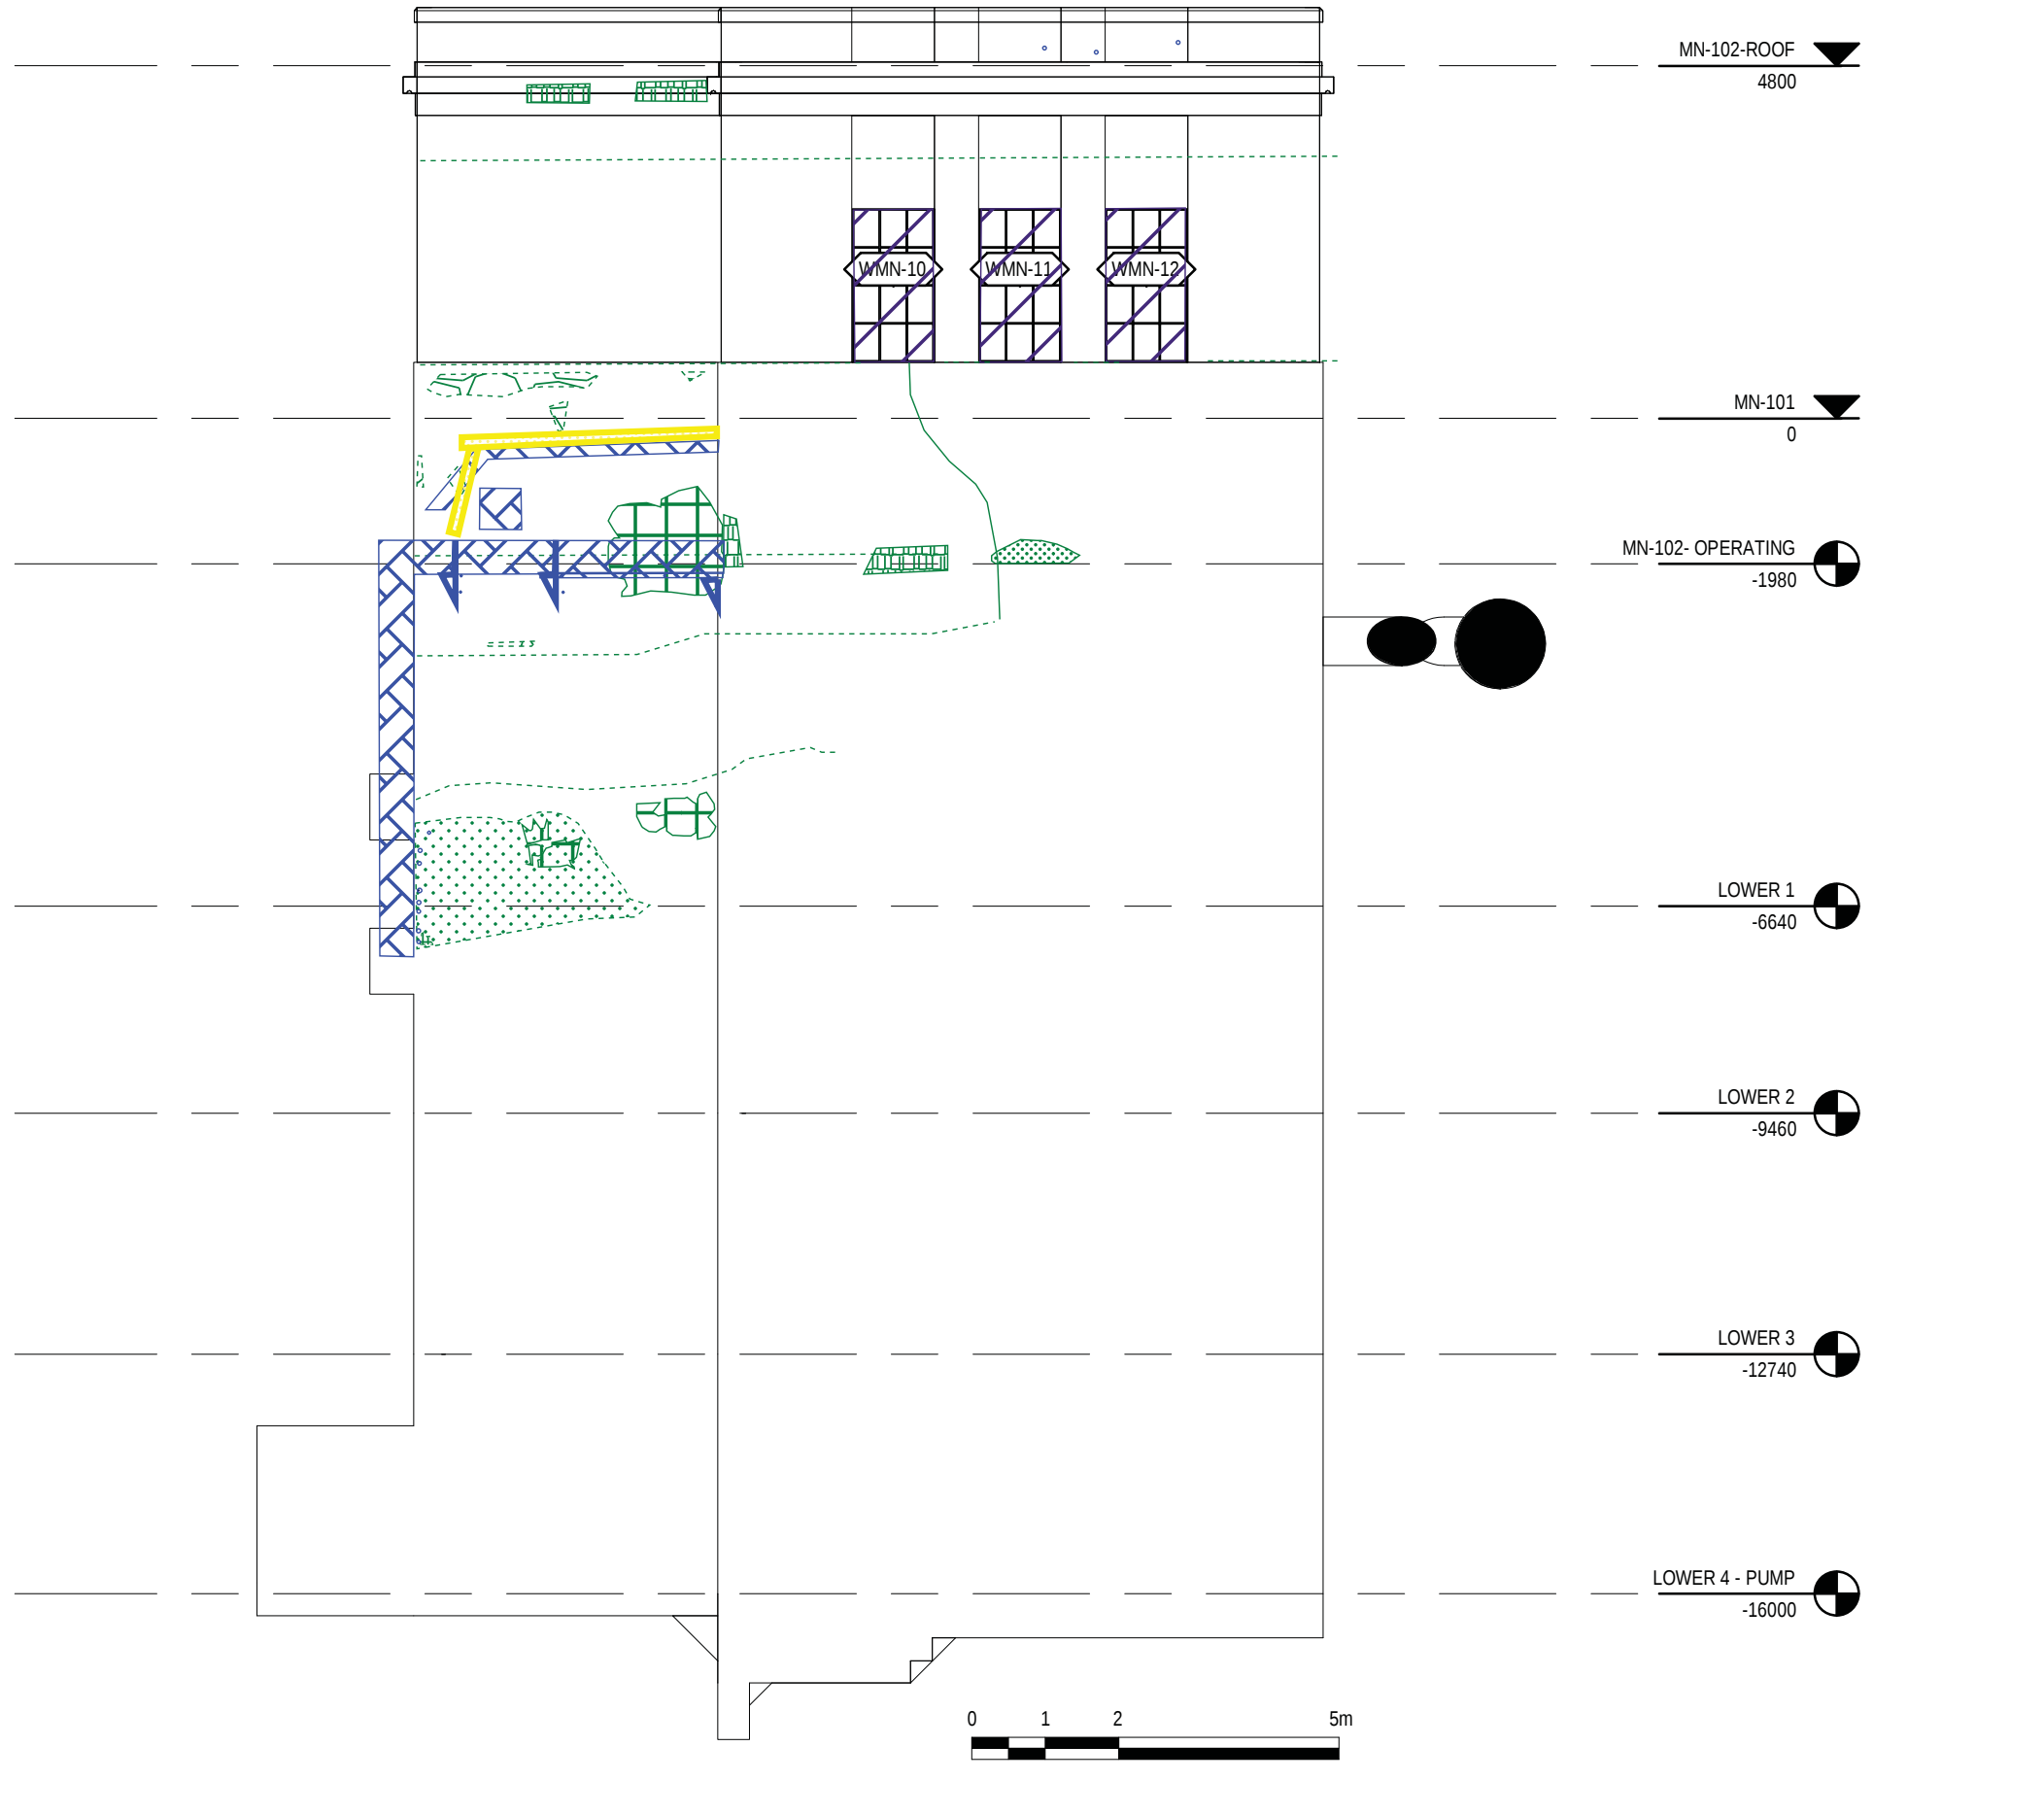

4 ELEVATION WEST
1 : 100

HATCH LEGEND

- CONCRETE
- METAL
- PLYWOOD
- OPEN TO BELOW
- MASKED REGION
- PROJECTING SURFACE
- CUT SURFACE

Consultant

PRIME CONSULTANT/ARCHITECTURAL

the marc boutin architectural collaborative inc.

205 9th Avenue SE, Suite 100

Calgary, AB, T2C 0B3

Contact: Richard Colter

MECHANICAL/ELECTRICAL

Williams Engineering Canada Inc.

10085 Jasper Ave #200,

Edmonton, AB T5J 3B1

Contact: Sheldon Samborsky (M), Ben Rajewski (E)

HERITAGE

DPS Inc. Architecture & Design

400 Boulevard de Maisonneuve O,

Montreal, QC H3A 1L4

Contact: Evan Ostland

ARCHITECTURAL

Saucier + Perrotte Architectes

7043 Waverly St,

Montreal, QC H2S 3J1

Contact: Anne-Marie Saucier

STRUCTURAL/CIVIL/BUILDING ENVELOPE

Reed Jones Christofferson LLP

17415 102 Ave NW #100,

Edmonton, AB T5S 1J6

Contact: Frank Cavalliere (S), John Balla (C), Nick Trovati (RE)

BUILDING/FIRE CODE

Jensen Hughes

5855 9 St SE #106,

Calgary, AB T2H 1Z9

Contact: Kyle Duckworth

COST

BTY Group

404 8 Ave SW #645,

Calgary, AB T2P 0R9

Contact: Michael Giesert

INDIGENITY

Nahwegah

1205 - 10903 103 Ave NW,

Edmonton, Alberta, T5K 2X6

Contact: Hunter Cardinal

MBAC

DFS

CONSULTANT PROJECT 20008

Seal	Permit
PRELIMINARY NOT FOR CONSTRUCTION	

Edmonton

ROSSDALE POWER PLANT
ADVANCED ASSESSMENT AND
PRIORITY REHABILITATION -
HISTORIC BUILDING RECORD

CP-9496

Department	INTEGRATED INFRASTRUCTURE SERVICES
------------	------------------------------------

No.	Description	Date
3	CORRECTION	2021-03-04
4	CORRECTION	2021-04-29

Location ID ROS 108

Description PUMP HOUSE #1
CONDITION ASSESSMENT

Drawing Title

EXTERIOR ELEVATIONS

Discipline	HERITAGE	Drawn	KC
Volume		Drawing Number	
Sheet	H350		
File			

Conditions Legend

Concrete Deterioration

Crack

Efflorescence

Exposed Rebar

Incipient Spall

Fibre Board Deterioration

Missing Unit

The Conditions Legend is specific to the subject building of each report and conditions drawing set

CEILING CONDITIONS MARKED DIRECTLY ABOVE LOCATION IDENTIFIED ON PLAN

1 MN-101
1 : 100

2 LOWER 1
1 : 100

3 LOWER 2
1 : 100

4 LOWER 3
1 : 100

5 LOWER 4 - PUMP
1 : 100

HATCH LEGEND

- CONCRETE
- METAL
- PLYWOOD
- OPEN TO BELOW
- MASKED REGION
- PROJECTING SURFACE
- CUT SURFACE

Consultant

PRIME CONSULTANT/ARCHITECTURAL

the marc boutin architectural collaborative inc.

205 9th Avenue SE, Suite 100

Calgary, AB, T2C 0R3

Contact: Richard Coder

MECHANICAL/ELECTRICAL

Williams Engineering Canada Inc.

10085 Jasper Ave #200,

Edmonton, AB T5J 3B1

Contact: Sheldon Samborsky (M), Ben Rajewski (E)

HERITAGE

DPS Inc. Architecture & Design

400 Boulevard de Maisonneuve O,

Montreal, QC H3A 1L4

Contact: Evan Ostlund

ARCHITECTURAL

Saucier + Perrotte Architectes

7043 Waverly St,

Montreal, QC H2S 3J1

Contact: Anne-Marie Saucier

STRUCTURAL/CIVIL/BUILDING ENVELOPE

Reed Jones Christofferson LLP

17415 102 Ave NW #100,

Edmonton, AB T5S 1J6

Contact: Frank Cavaliere (S), John Balla (C), Nick Trovati (RE)

BUILDING/FIRE CODE

Jensen Hughes

5855 9 St SE #106,

Calgary, AB T2H 1Z9

Contact: Kyle Duckworth

COST

BTY Group

404 8 Ave SW #645,

Calgary, AB T2P 0R9

Contact: Michael Giesert

INDIGENITY

Nahayewin

1205 - 10903 103 Ave NW,

Edmonton, Alberta, T5K 2X6

Contact: Hunter Cardinal

CONSULTANT PROJECT 20008

Seal

Permit

PRELIMINARY NOT FOR CONSTRUCTION

ROSSDALE POWER PLANT
ADVANCED ASSESSMENT AND
PRIORITY REHABILITATION -
HISTORIC BUILDING RECORD

CP-9496

Department INTEGRATED INFRASTRUCTURE SERVICES

No.	Description	Date
3	CORRECTION	2021-03-04
4	CORRECTION	2021-04-29

Location ID ROS 108
Description PUMP HOUSE #1
CONDITION ASSESSMENT

Drawing Title CEILING PLAN

Discipline	HERITAGE	Drawn	KC
Volume		Drawing	
Sheet	H550	Number	
File			

Conditions Legend

Fibre Board Deterioration

Failed Attachment/
Distorted Unit

Missing Unit


Window Deterioration

Broken/Missing Unit

Wood Deterioration

Paint Failure


The Conditions Legend is
specific to the subject
building of each report and
conditions drawing set

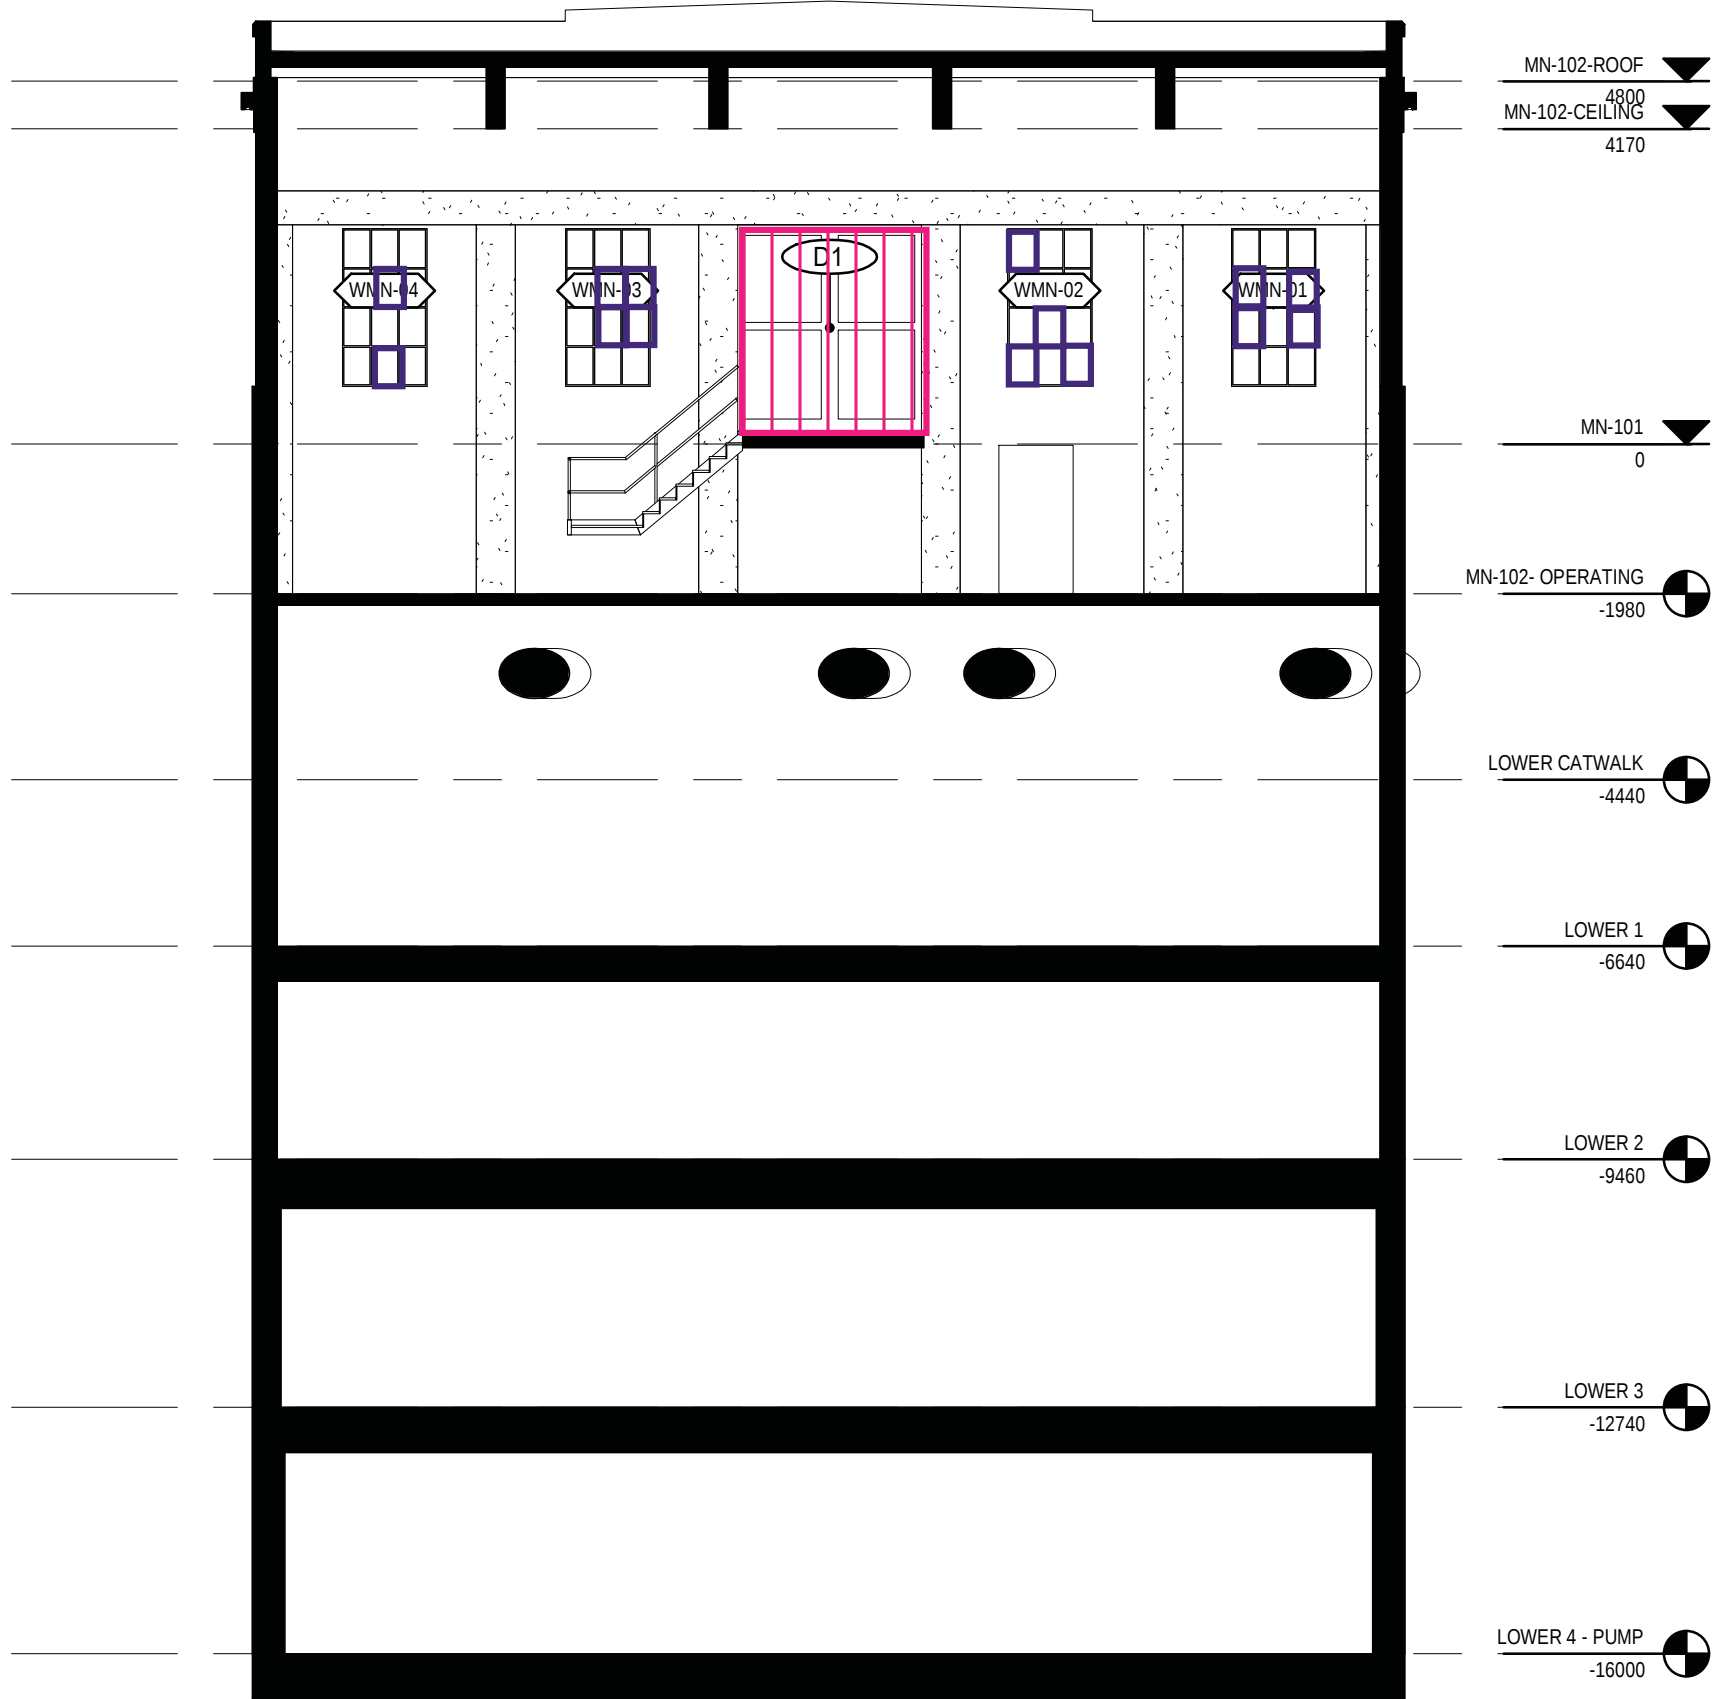


1 INTERIOR NORTH
1 : 100



2 INTERIOR EAST
1 : 100

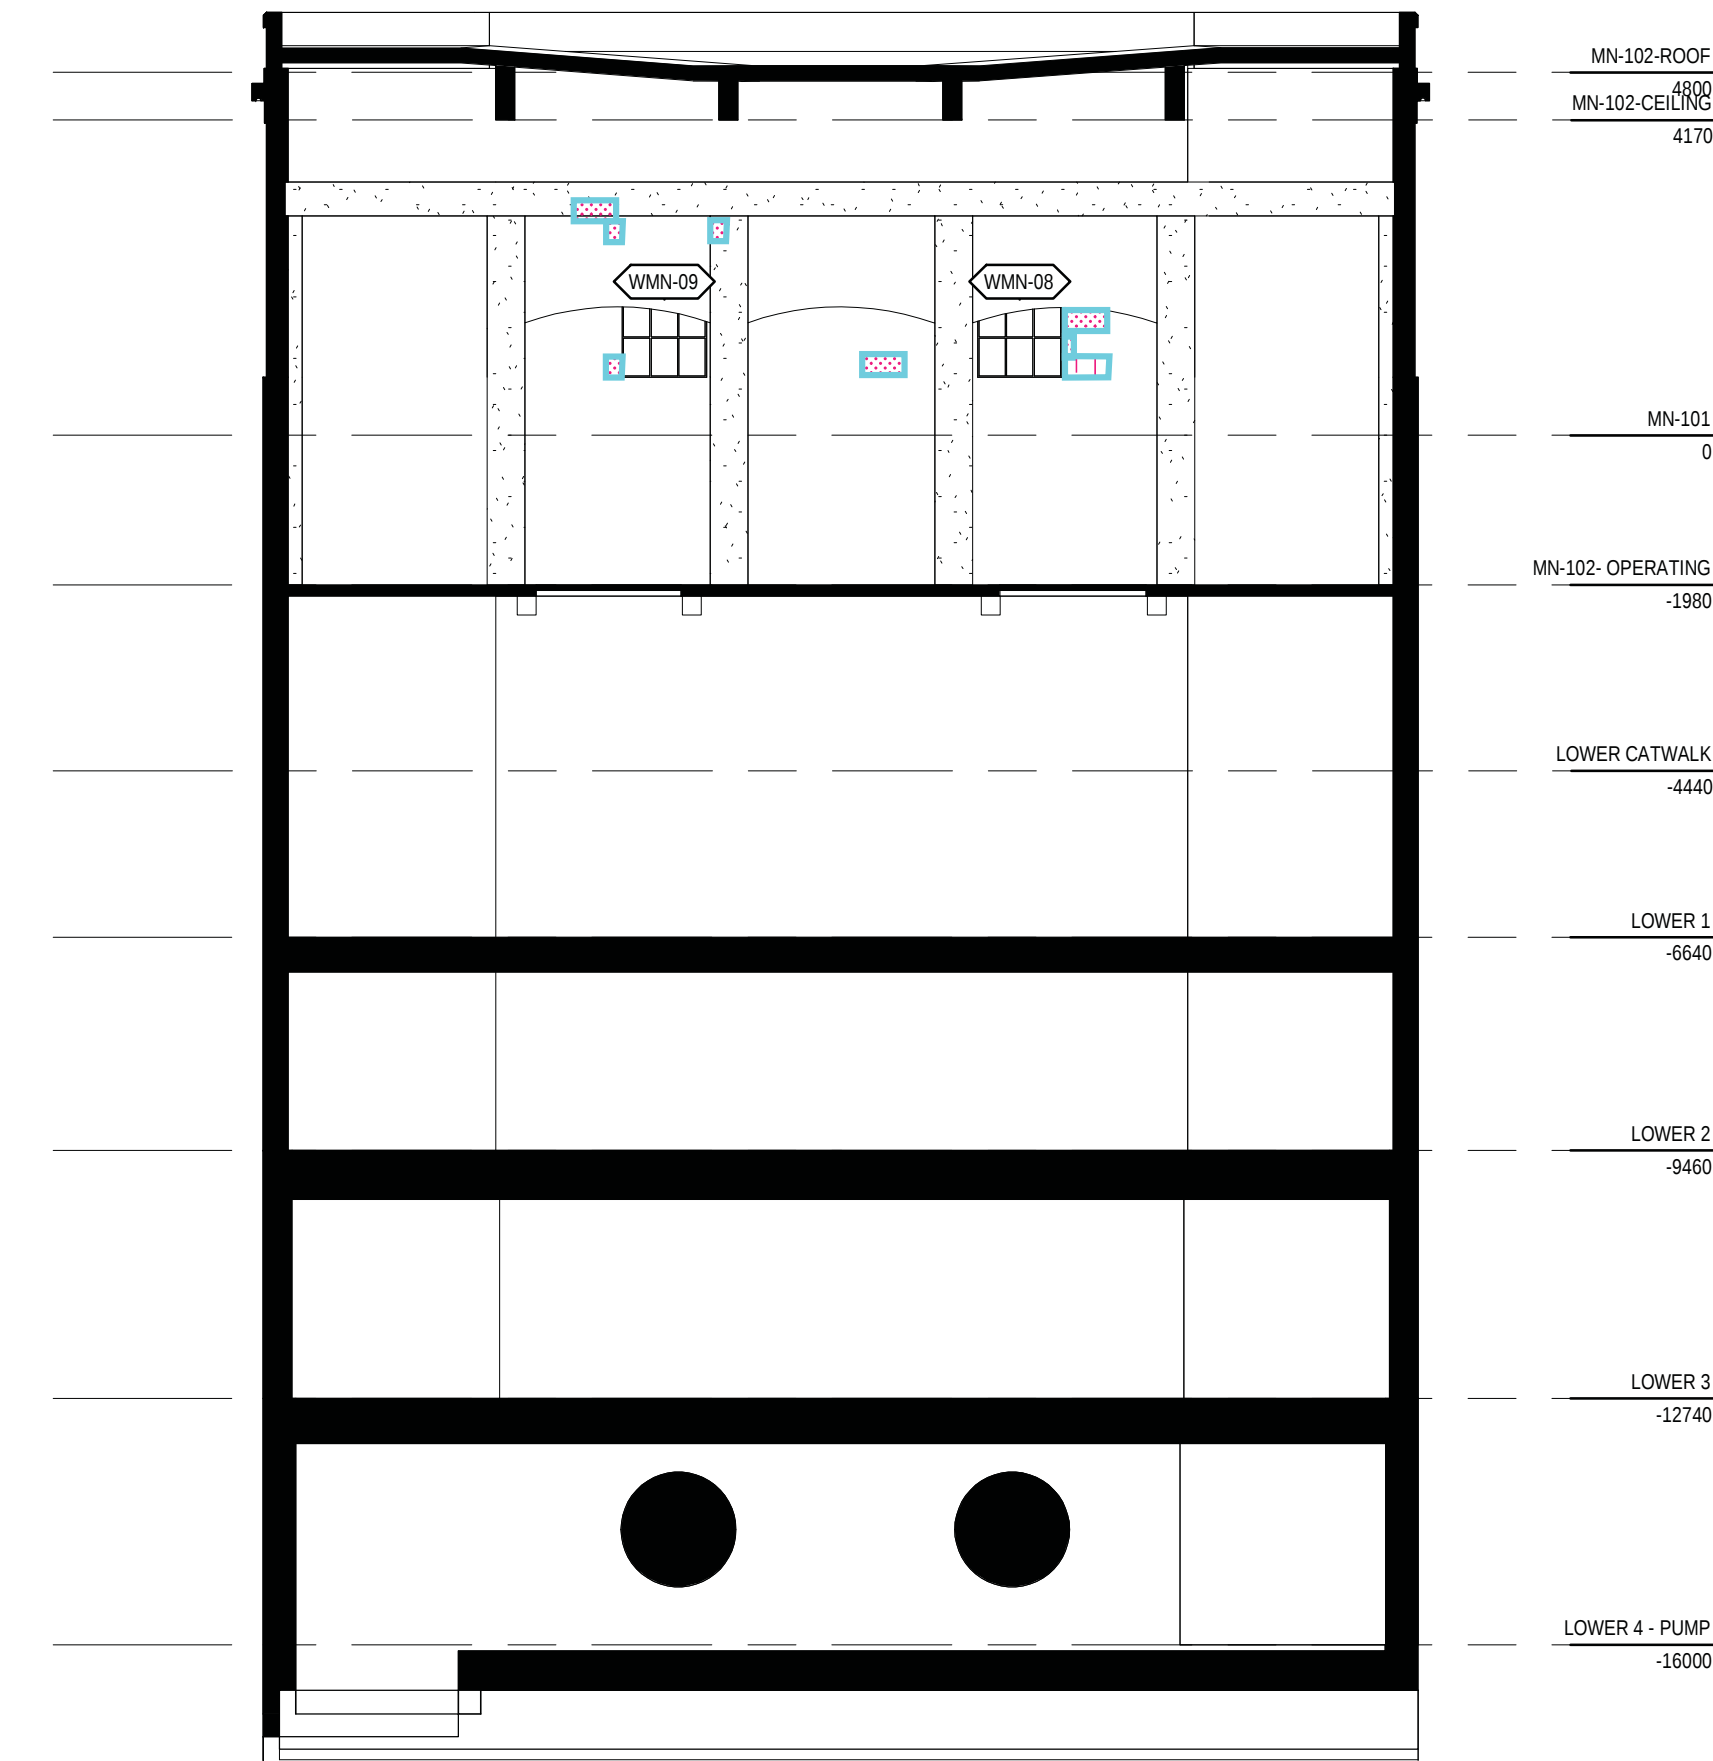

3 INTERIOR SOUTH
1 : 100

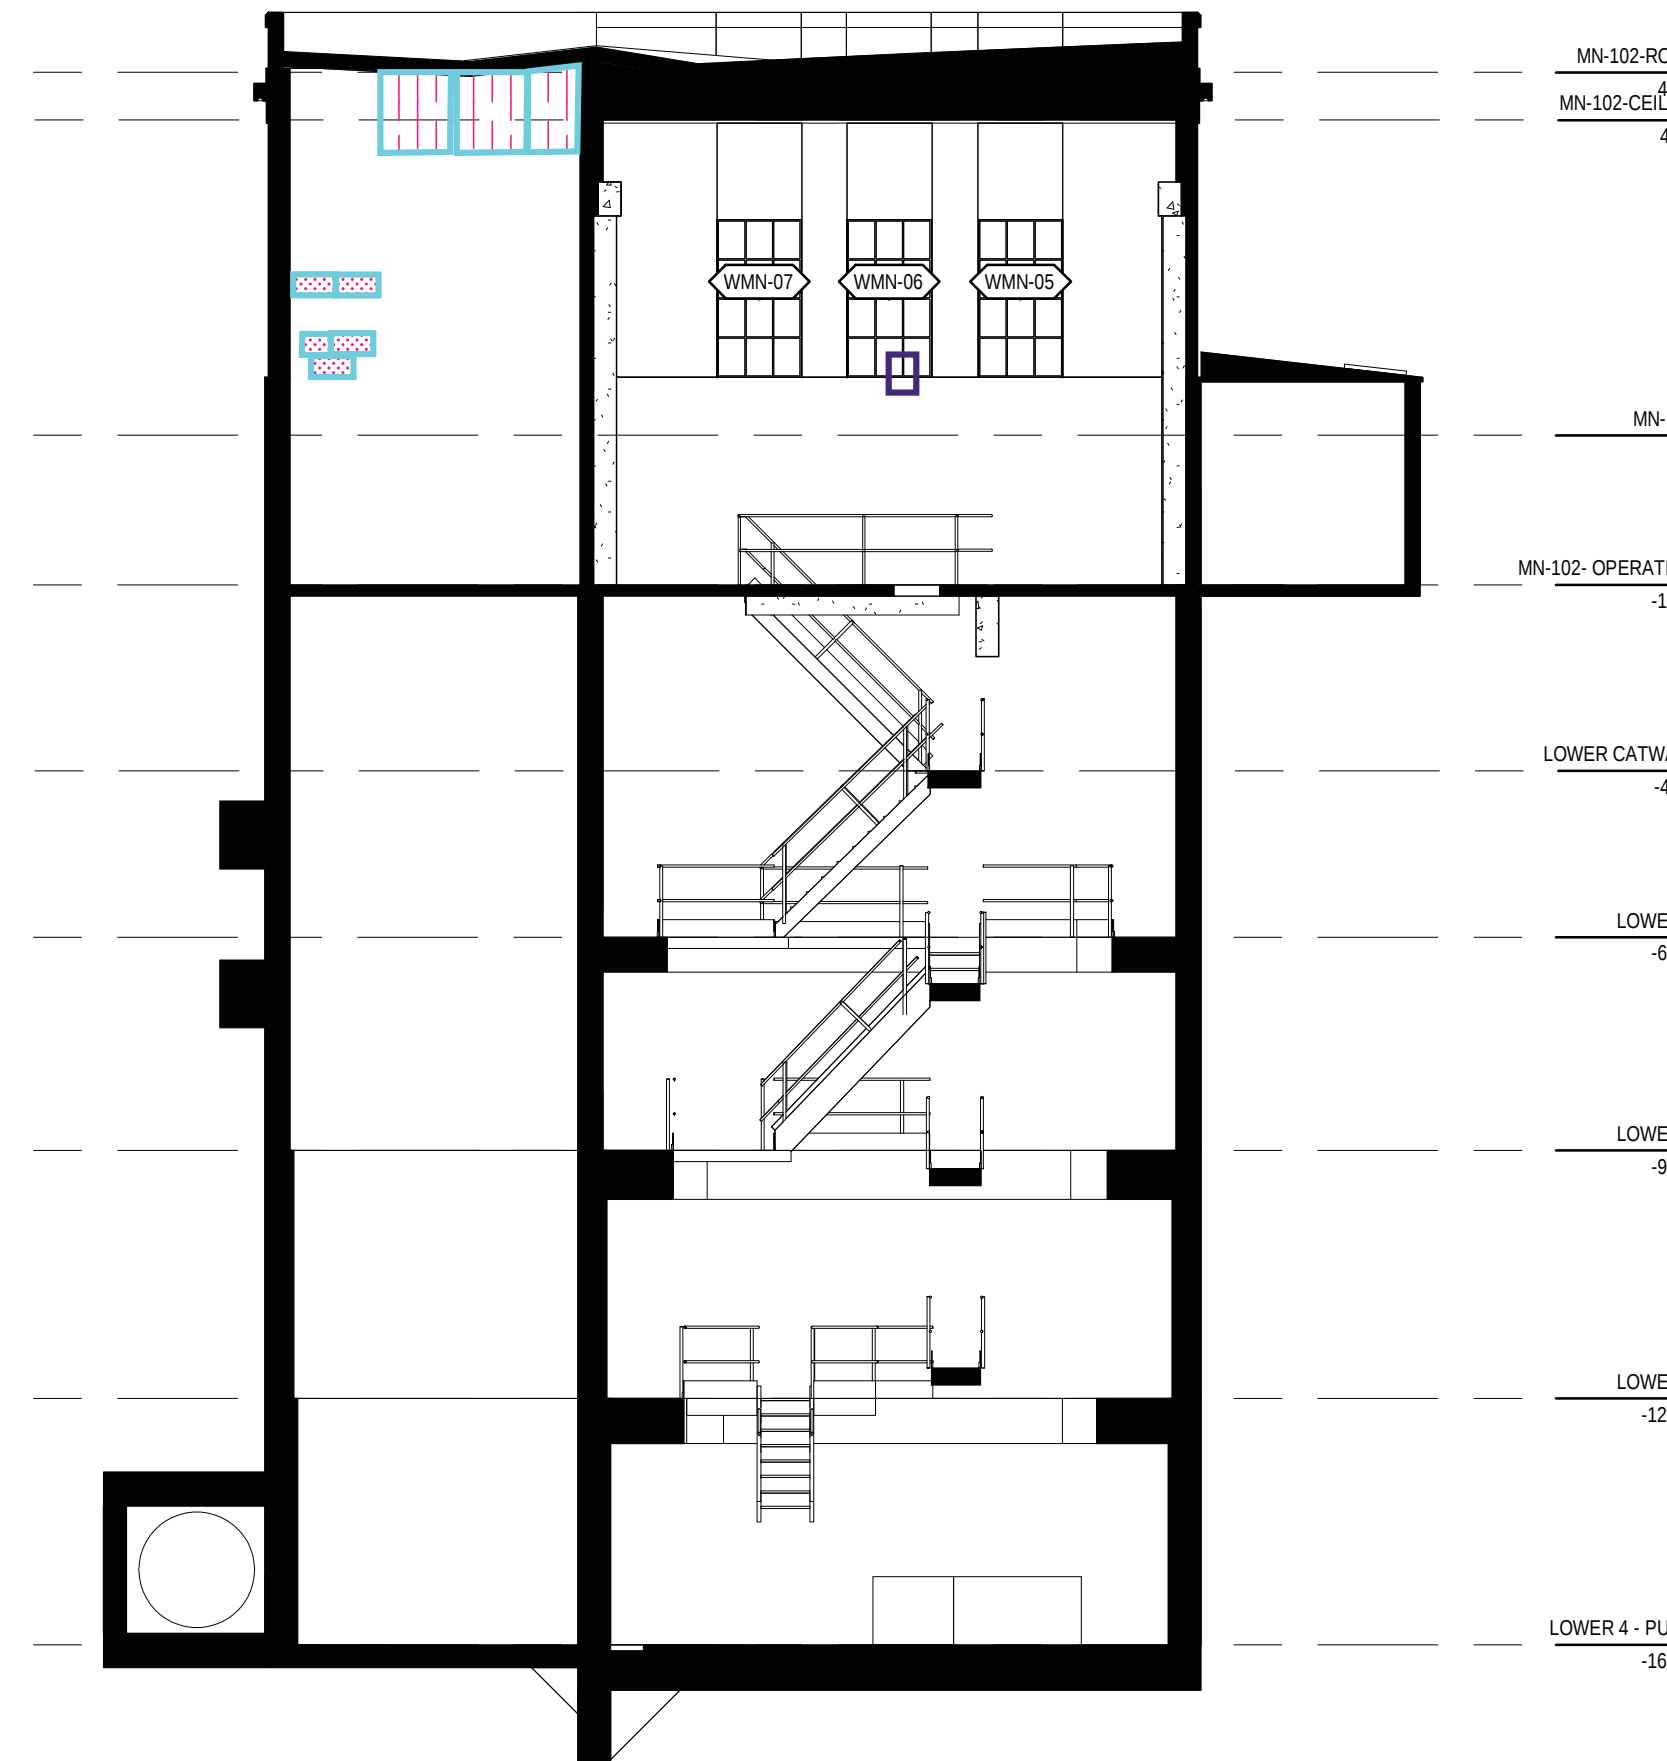

4 INTERIOR WEST
1 : 100

HATCH LEGEND

- CONCRETE
- METAL
- PLYWOOD
- OPEN TO BELOW
- MASKED REGION
- PROJECTING SURFACE
- CUT SURFACE

Consultant

PRIME CONSULTANT/ARCHITECTURAL
the marc boutin architectural collaborative inc.
205 9th Avenue SE, Suite 100
Calgary, AB, T2C 0R3
Contact: Richard Coder

MECHANICAL/ELECTRICAL
Williams Engineering Canada Inc.
10085 Jasper Ave #200,
Edmonton, AB T5J 3B1
Contact: Sheldon Samborsky (M), Ben Rajewski (E)

HERITAGE
DPS Inc. Architecture & Design
400 Boulevard de Maisonneuve O,
Montreal, QC H3A 1L4
Contact: Evan Ostend

ARCHITECTURAL
Saucier + Perrotte Architectes
7043 Waverly St.
Montreal, QC H2S 3J1
Contact: Anne-Marie Saucier

STRUCTURAL/CIVIL/BUILDING ENVELOPE
Reed Jones Christofferson Ltd
17415 102 Ave NW #100,
Edmonton, AB T5S 1J6
Contact: Frank Cavaliere (S), John Balla (C),
Nick Trovati (RE)

BUILDING/FIRE CODE
Jensen Hughes
5855 9 St SE #106,
Calgary, AB T2H 1Z9
Contact: Nyle Duckworth

COST
BTY Group
404 8 Ave SW #645,
Calgary, AB T2P 0R9
Contact: Michael Giesbert

INDIGENITY
Nahayewit
1205 - 10903 103 Ave NW,
Edmonton, Alberta, T5K 2X6
Contact: Hunter Cardinal

CONSULTANT PROJECT 20008

Seal

Permit

PRELIMINARY NOT FOR CONSTRUCTION

ROSSDALE POWER PLANT
ADVANCED ASSESSMENT AND
PRIORITY REHABILITATION -
HISTORIC BUILDING RECORD

CP-9496

Department INTEGRATED INFRASTRUCTURE SERVICES

No.	Description	Date
3	CORRECTION	2021-03-04
4	CORRECTION	2021-04-29

Location ID ROS 108

Description PUMP HOUSE #1
CONDITION ASSESSMENT

Drawing
Title INTERIOR ELEVATIONS

Discipline	HERITAGE	Drawn	KC
Volume		Drawing Number	
Sheet	H650		
File			