 
 



SYMBOLS LEGEND




NORTH ARROW



 INTERIOR ELEVATION MARKER



EXTERIOR ELEVATION MARKER

 

SECTION HEAD

Name
Elevation

 


LEVEL MARKER - BELOW GROUND


Name
Elevation



LEVEL MARKER - ABOVE GROUND



WINDOW TAG

 

DOOR TAG



ROOM TAG



BREAK LINE

HATCHES LEGEND



METAL



PLASTER



OPEN BELOW



MASKED REGION



PROJECTING SURFACE





CUT SURFACE

DRAWING LIST	
Sheet Name	Sheet Number
PUMP HOUSE #1 TITLE SHEET	H000
SITE PLAN	H100
PLANS	H200
EXTERIOR ELEVATIONS	H300
INTERIOR ELEVATIONS	H600

SITE PLAN BUILDING LIST

ROS104.....Rossdale Burial Grounds
ROS105.....Rossdale LP Power Plant - Switch House
ROS106.....Rossdale LP Power Plant - Turbine Hall
ROS107.....Rossdale LP Power Plant - Boiler Hall
ROS108.....Rossdale Pump House #1
ROS109.....Rossdale Pump House #2
ROS111.....Rossdale EPCOR Administration Building
ROS112.....Rossdale Power Plant ATCO Gas Building

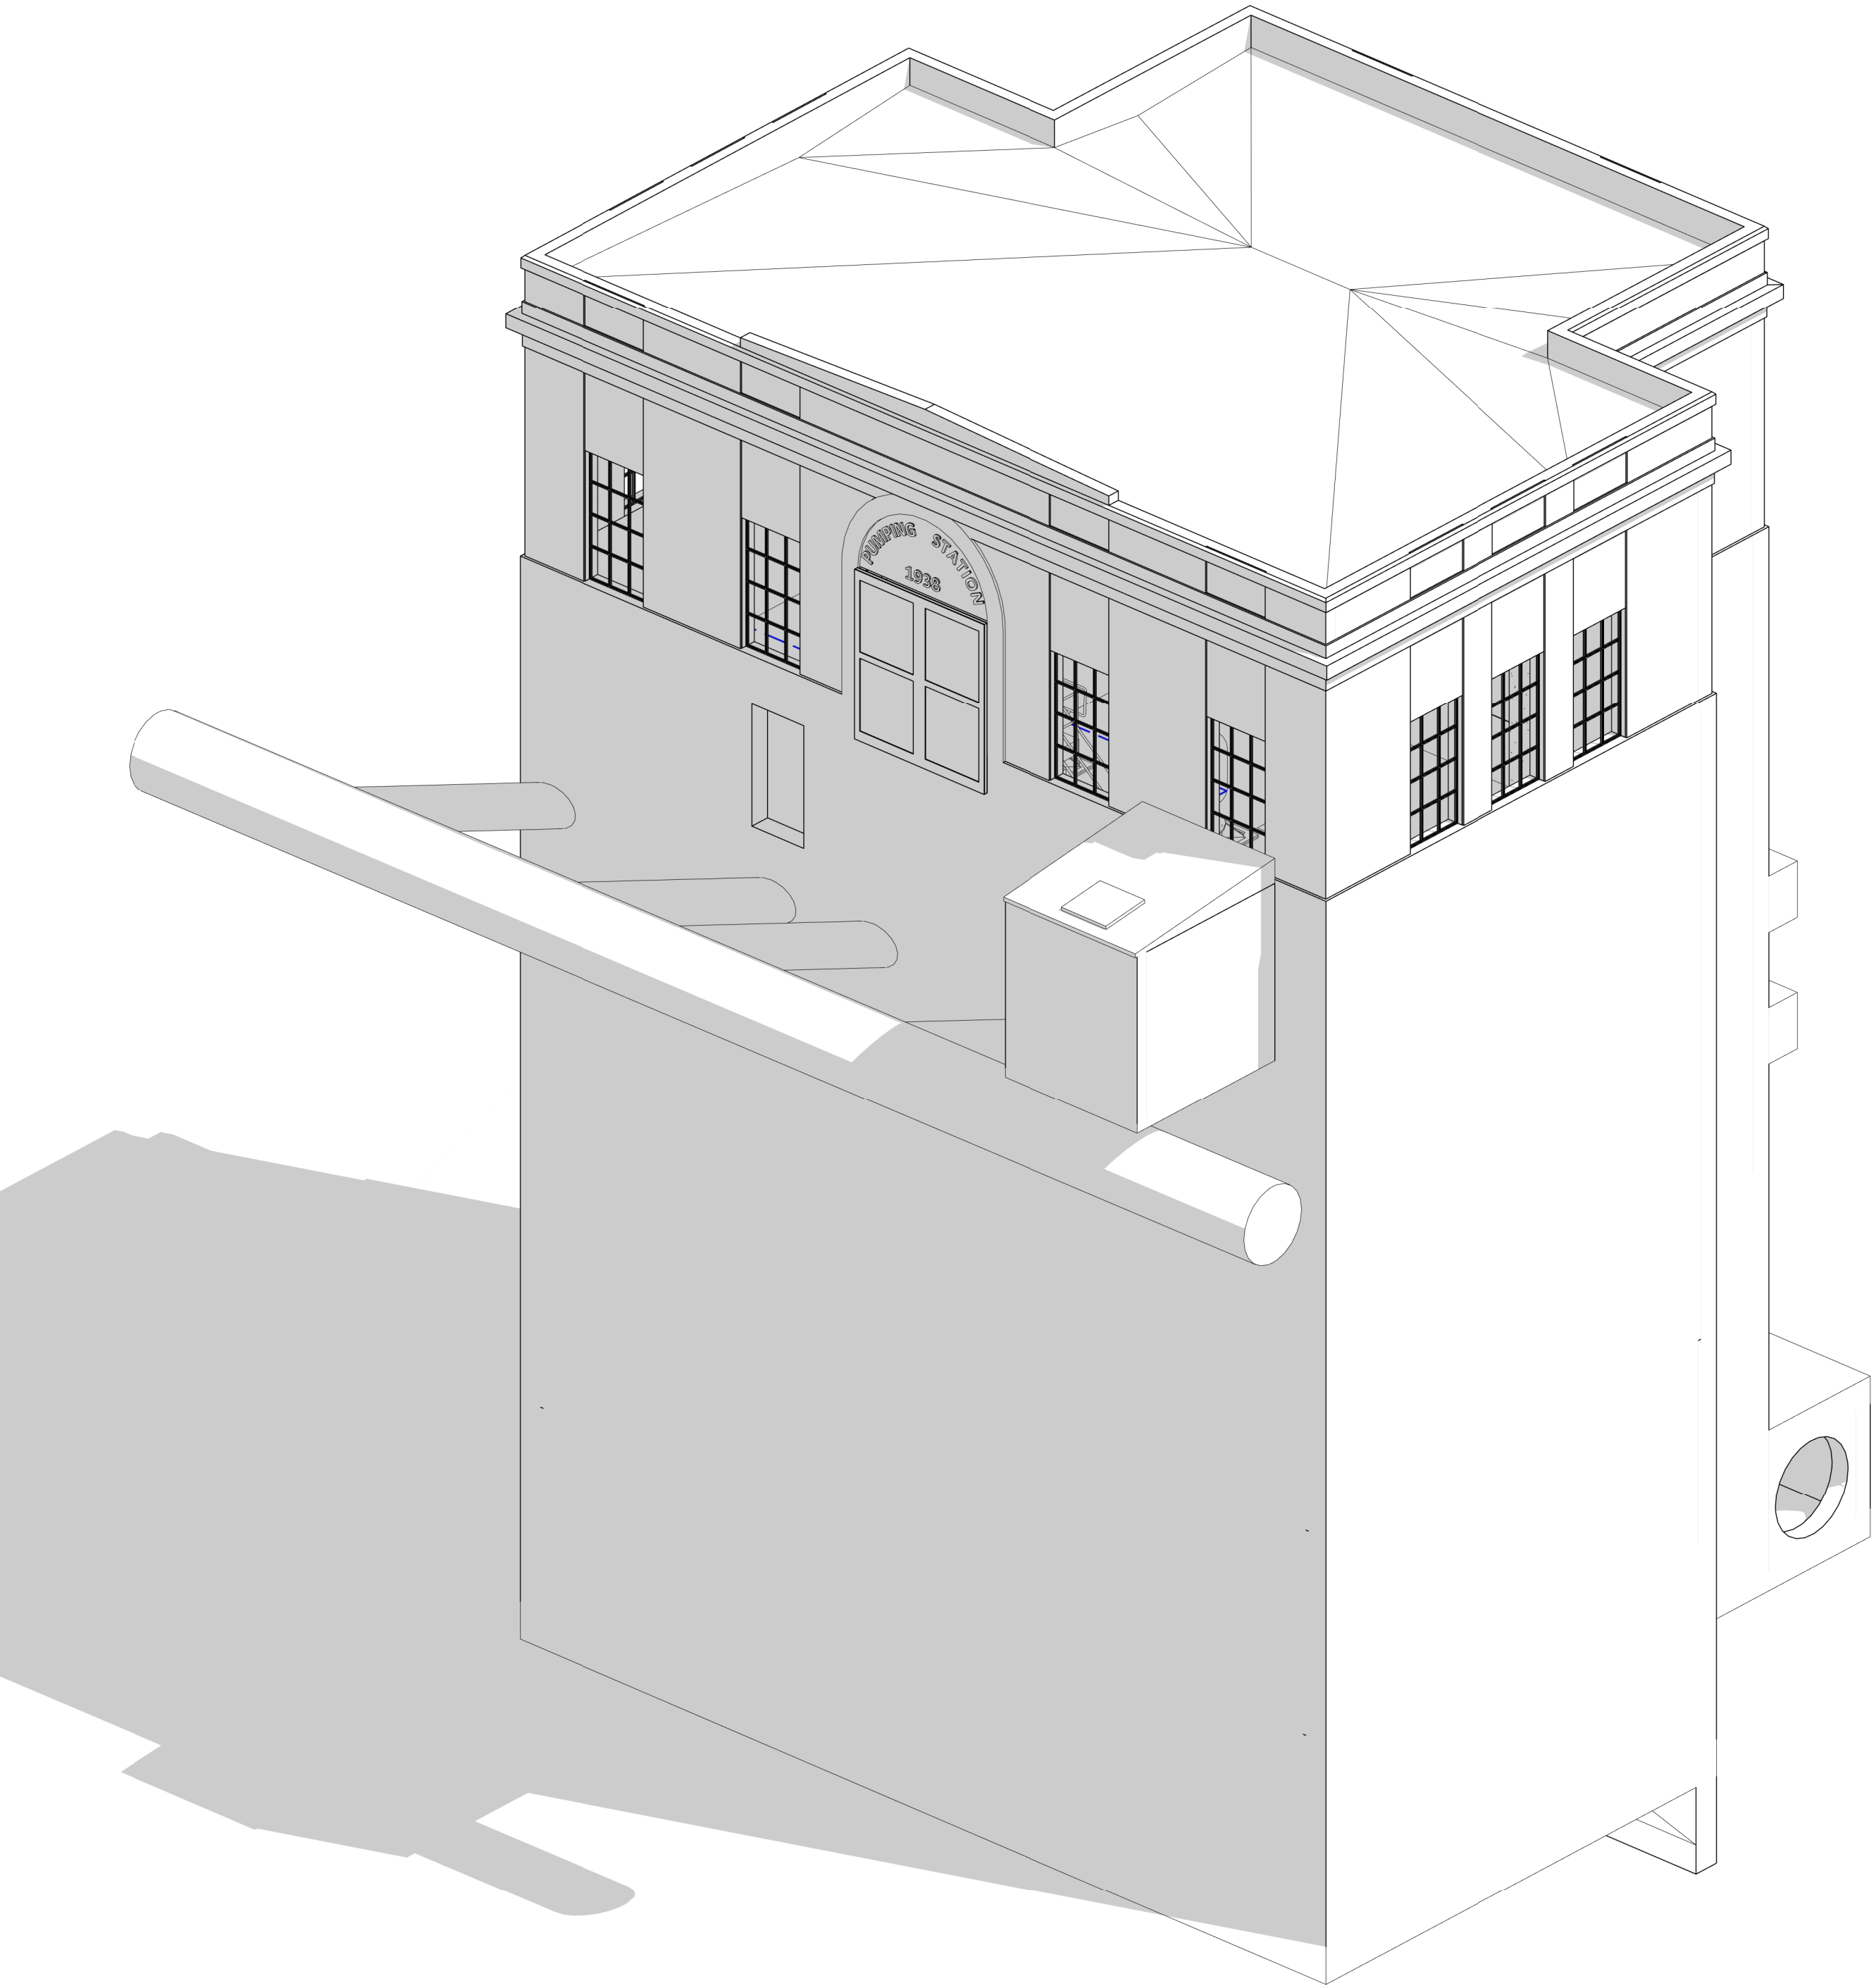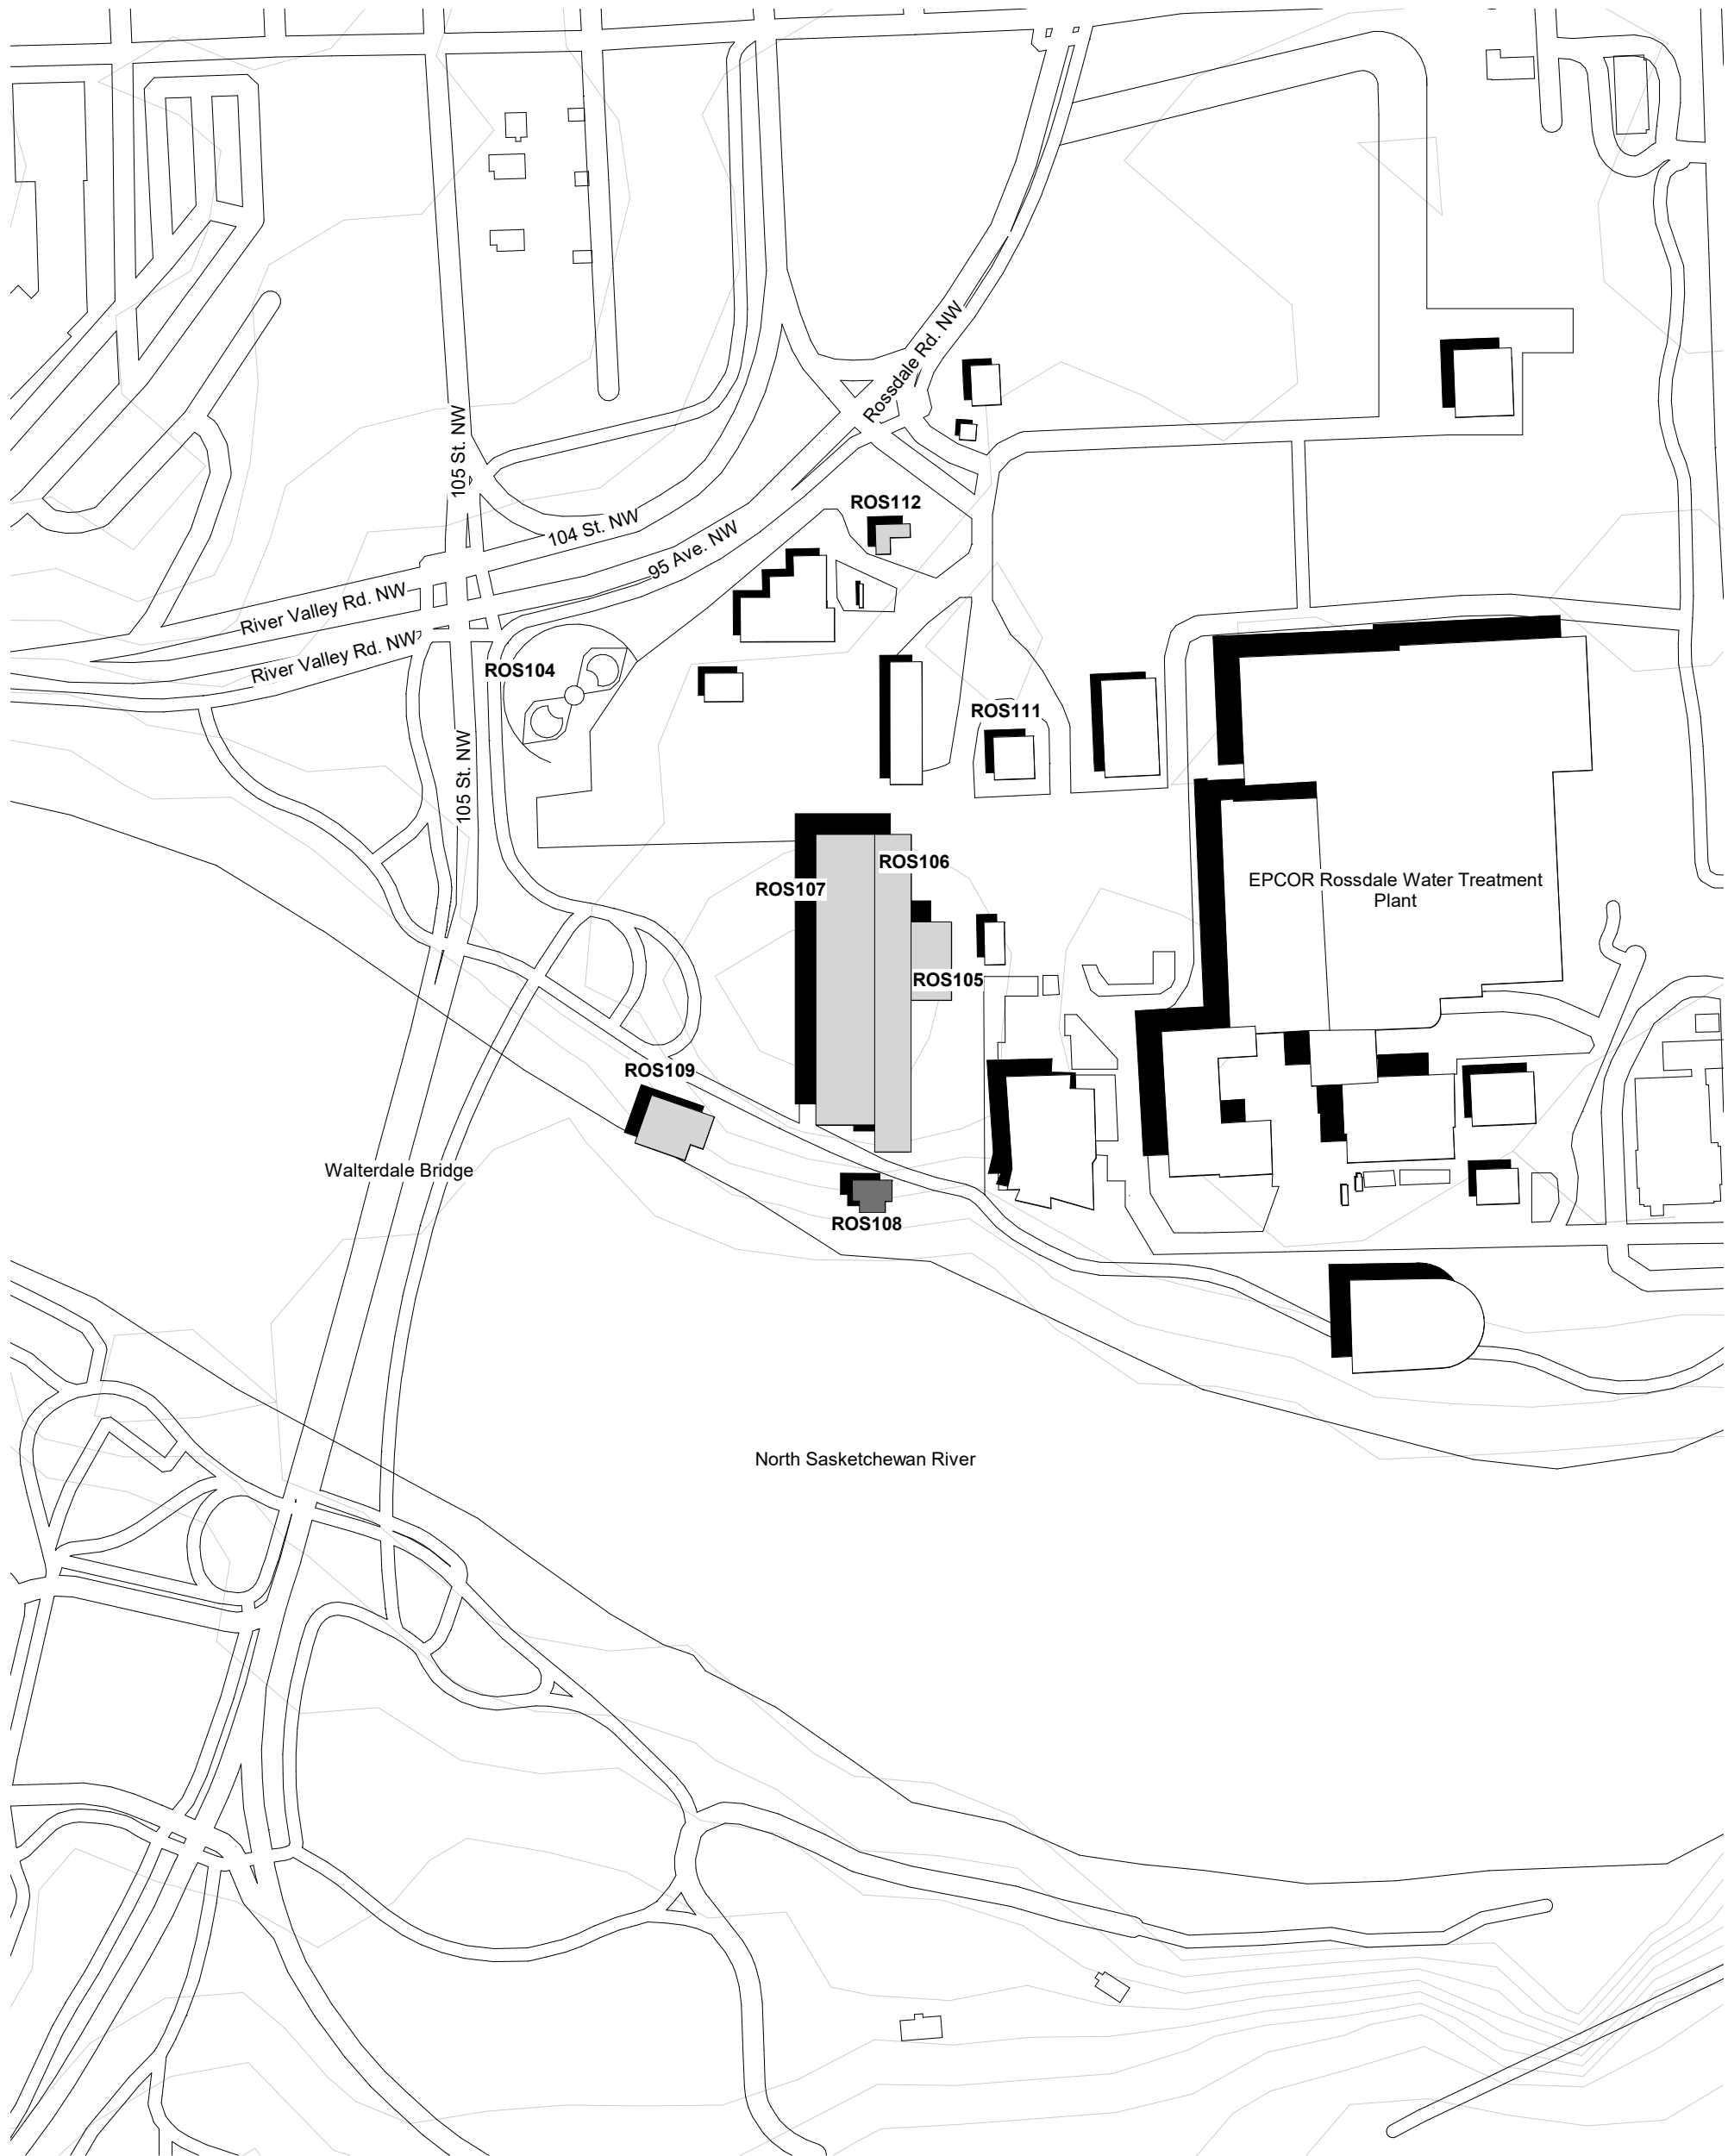

DRAWING SET NOTES

Pump Houe #1 was 2D drafted and 3D modelled in Revit 2020 using data from a variety of sources. The primary source of data was MiraCAD LiDAR scan data from September 16, 2020 and October 23, 2020.A point cloud was generated through terrestrial LiDAR scan data combined with aerial drone photogrammetry. Additional data for Pump House #1 drawing set was gathered from DFS photography, MiraCAD photography, EPCOR'S Rosedale Generating Station (RGS) drawing database, and CADMapper.

Accuracy: 50 mm
Level of Development (LOD): 100

Missing Data from Point Cloud: Wet wells were not accessible for scanning. Point cloud data on south exterior elevation was limited.

Missing Data from 3D Revit Model: Structural, Mechanical, Electrical, Civil, and Landscape components have not been modelled.

Missing Data from 2D Revit Drawings: Structural, Mechanical, Electrical, Civil, and Landscape components have not been drafted.

Consultant

PRIME CONSULTANT/ARCHITECTURAL
the marc boutin architectural collaborative inc.
205 9th Avenue SE, Suite 100
Calgary, AB, T2C 0R3
Contact: Richard Colter

HERITAGE
DFS Inc. Architecture & Design
400 Boulevard de Maisonneuve O,
Montreal, QC H3A 1L4
Contact: Evan Ostend

ARCHITECTURAL
Saucier + Perrotte Architectes
7043 Waverly St.
Montreal, QC H2S 3J1
Contact: Anne-Marie Saucier

STRUCTURAL/CIVIL/BUILDING ENVELOPE
Reed Jones Christofferson Ltd
17415 102 Ave NW #100,
Edmonton, AB T5S 1J6
Contact: Frank Cavaliere (S), John Balla (C),
Nick Trovato (RE)

MECHANICAL/ELECTRICAL
Williams Engineering Canada Inc.
10085 Jasper Ave #200,
Edmonton, AB T5J 3B1
Contact: Sheldon Sambrinsky (M), Ben Rajewski (E)

BUILDING/FIRE CODE
Jensen Hughes
5855 9 St SE #106,
Calgary, AB T2H 1Z9
Contact: Nyle Duckworth

COST
BTY Group
404 8 Ave SW #645,
Calgary, AB T2P 0R9
Contact: Michael Giesert

INDIGENITY
Nahwegahnee
1205 - 10903 103 Ave NW,
Edmonton, Alberta, T5K 2K6
Contact: Hunter Cardinal



Seal	Permit
PRELIMINARY NOT FOR CONSTRUCTION	



ROSSDALE POWER PLANT
ADVANCED ASSESSMENT AND
PRIORITY REHABILITATION -
HISTORIC BUILDING RECORD

CP-9496

Department	INTEGRATED INFRASTRUCTURE SERVICES
------------	------------------------------------

No.	Description	Date

Location ID


Description

PUMP HOUSE #1
BUILDING RECORD

Drawing Title

PUMP HOUSE #1 TITLE SHEET

Discipline	HERITAGE	Drawn	KC
Volume	H000	Drawing	Number
Sheet			
File			

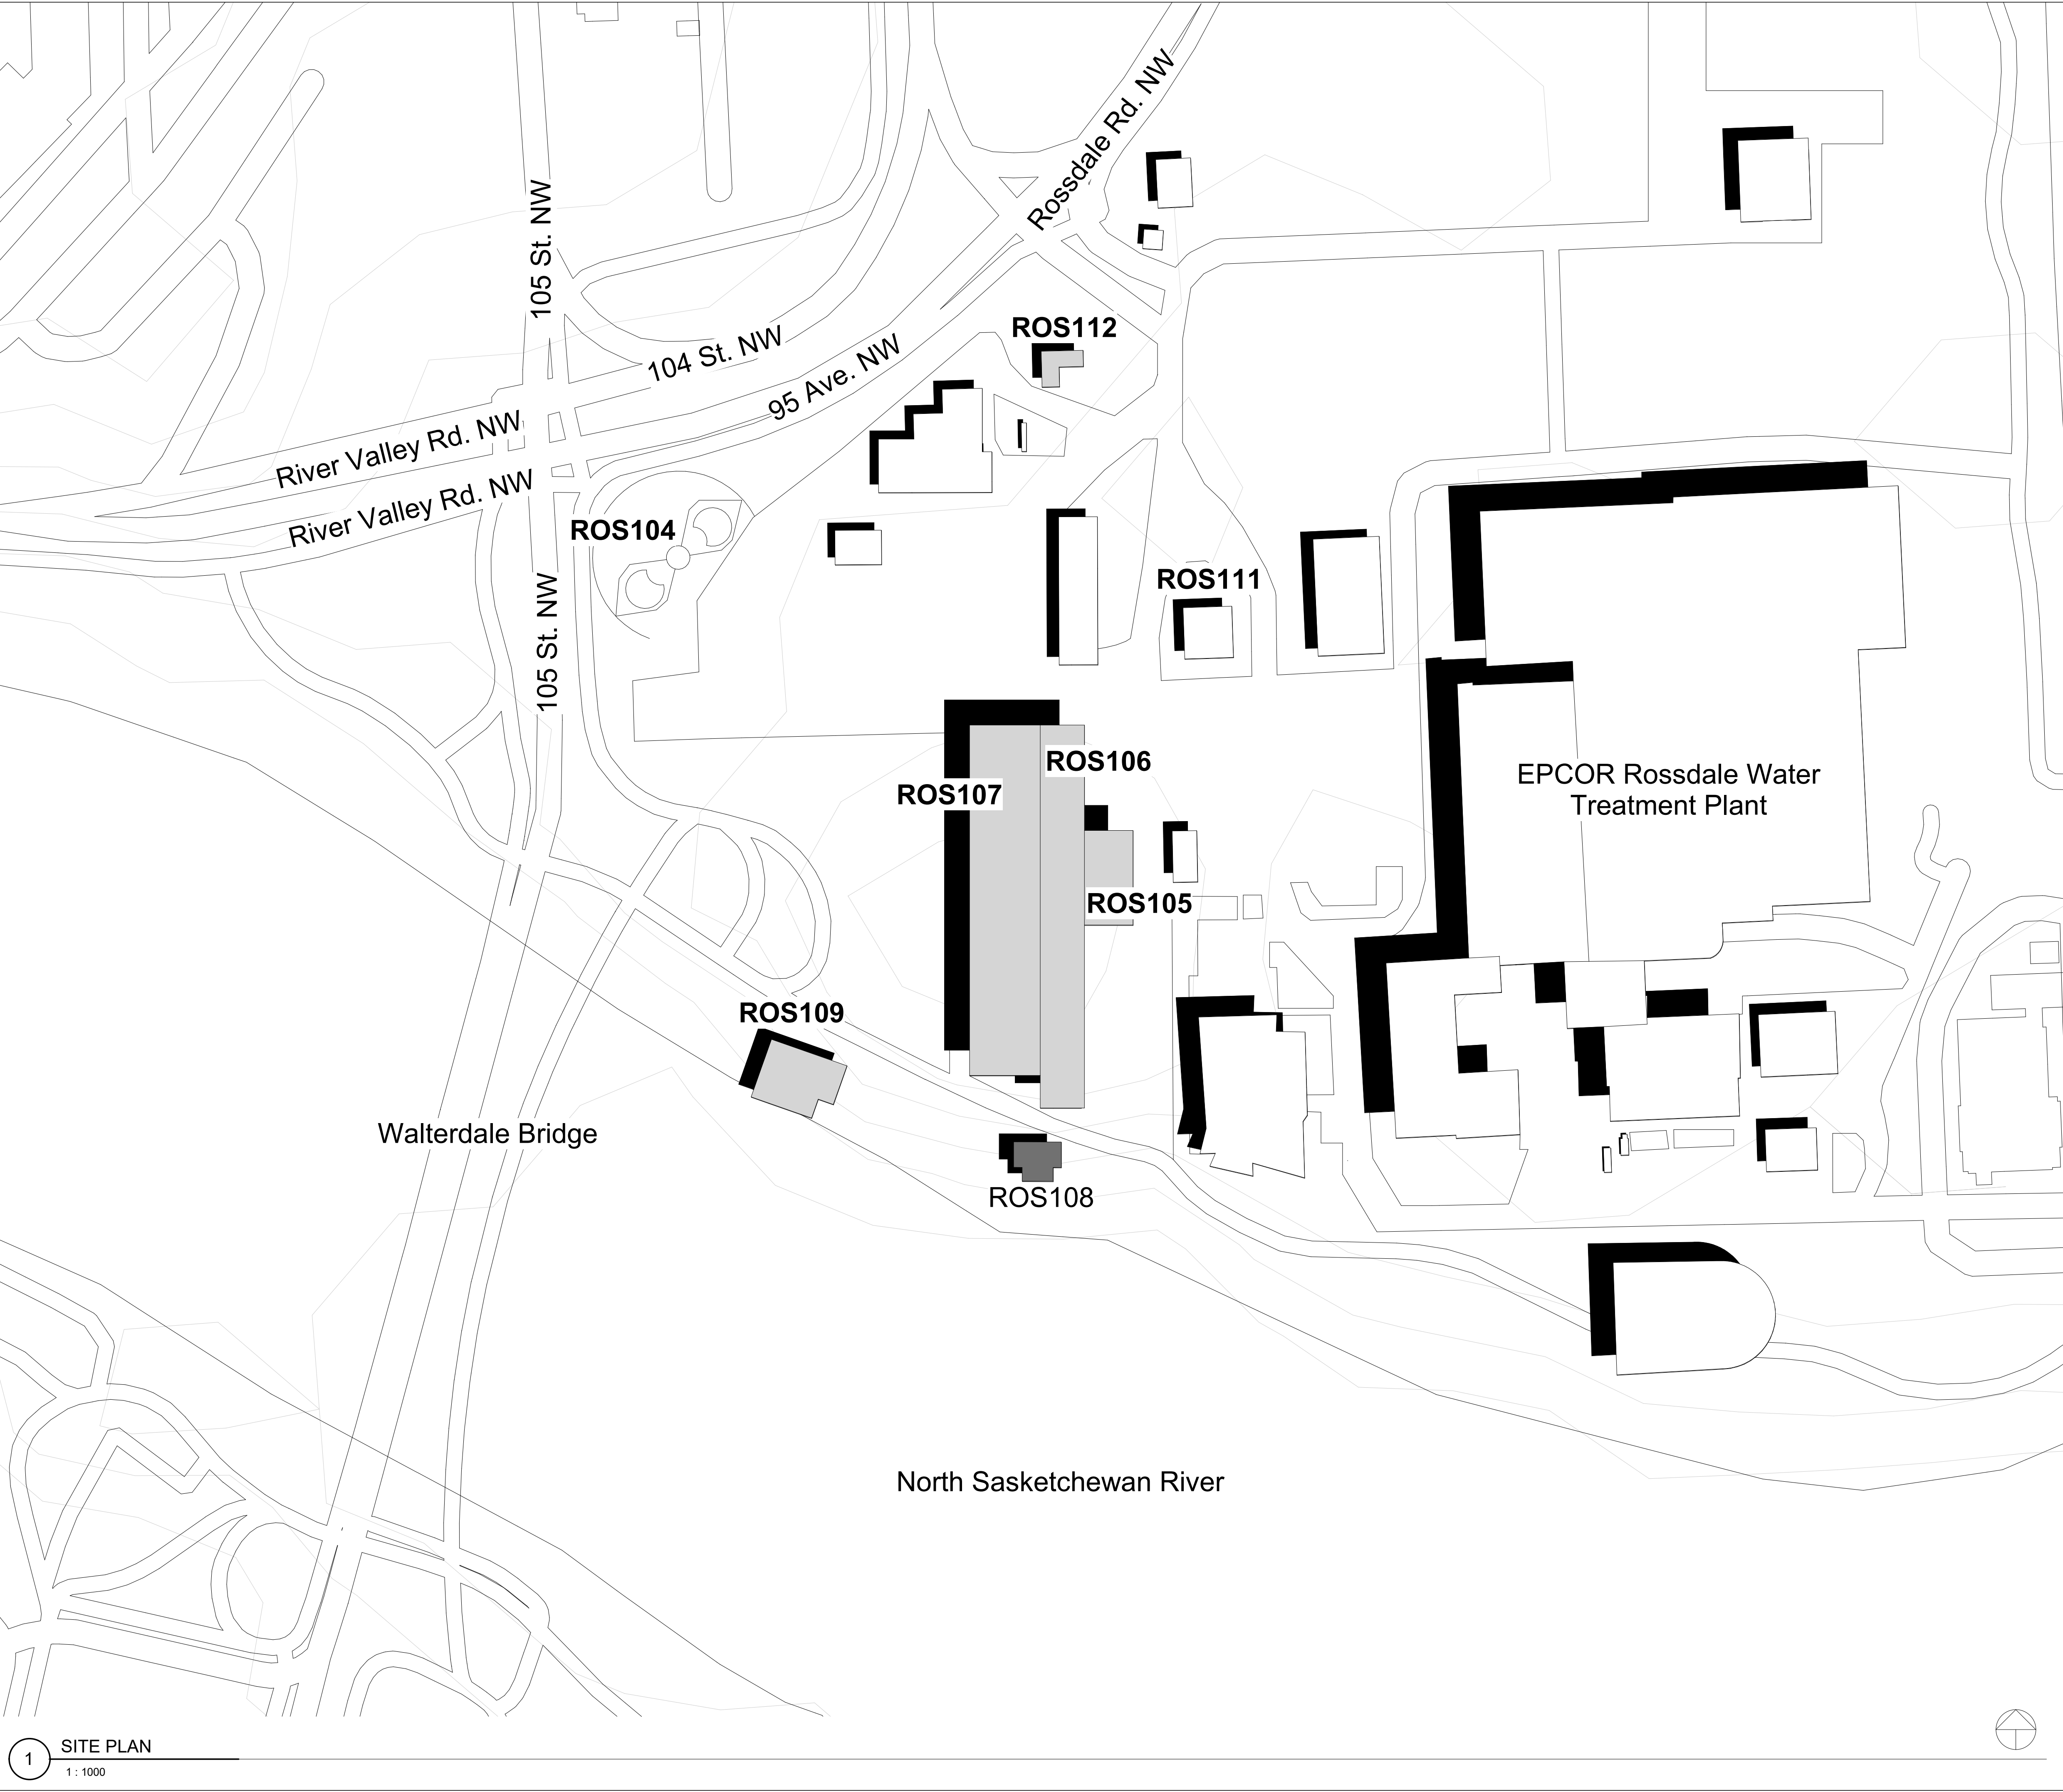

- ROS104.....Rosedale Burial Grounds
- ROS105.....Rosedale LP Power Plant - Switch House
- ROS106.....Rosedale LP Power Plant - Turbine Hall
- ROS107.....Rosedale LP Power Plant - Boiler Hall
- ROS108.....Rosedale Pump House #1
- ROS109.....Rosedale Pump House #2
- ROS111.....Rosedale EPCOR Administration Building
- ROS112.....Rosedale Power Plant ATCO Gas Building

Consultant

PRIME CONSULTANT/ARCHITECTURAL
the marc boutin architectural collaborative inc.
10085 Jasper Ave #200,
Edmonton, AB T5J 3B1
Contact: Richard Coder

MECHANICAL/ELECTRICAL
Williams Engineering Canada Inc.
10085 Jasper Ave #200,
Edmonton, AB T5J 3B1
Contact: Sheldon Samborsky (M), Ben Rajewski (E)

HERITAGE
DFS Inc. Architecture & Design
400 Boulevard de Maisonneuve O,
Montreal, QC H3A 1L4
Contact: Evan Ostend

ARCHITECTURAL
Saucier + Perrotte Architectes
7043 Waverly St,
Montreal, QC H2S 3J1
Contact: Anne-Marie Saucier

STRUCTURAL/CIVIL/BUILDING ENVELOPE
Reed Jones Christofferson Ltd
17415 102 Ave NW #100,
Edmonton, AB T5S 1J6
Contact: Frank Cavalliere (S), John Balla (C),
Nick Trovati (BE)

BUILDING/FIRE CODE
Jensen Hughes
5855 9 St SE #106,
Calgary, AB T2H 1Z9
Contact: Kyle Duckworth

COST
BTY Group
404 8 Ave SW #645,
Calgary, AB T2P 0R9
Contact: Michael Giesert

INDIGENITY
Nahwegahnee
1205 - 10903 103 Ave NW,
Edmonton, Alberta, T5K 2K6
Contact: Hunter Cardinal



Seal	Permit
	PRELIMINARY NOT FOR CONSTRUCTION



ROSSDALE POWER PLANT
ADVANCED ASSESSMENT AND
PRIORITY REHABILITATION -
HISTORIC BUILDING RECORD

CP-9496

Department INTEGRATED INFRASTRUCTURE SERVICES


No.	Description	Date

Location ID


Description **PUMP HOUSE #1
BUILDING RECORD**

Drawing
Title **SITE PLAN**


Discipline	HERITAGE	Drawn	BH
Volume		Drawing Number	
Sheet	H100		
File			

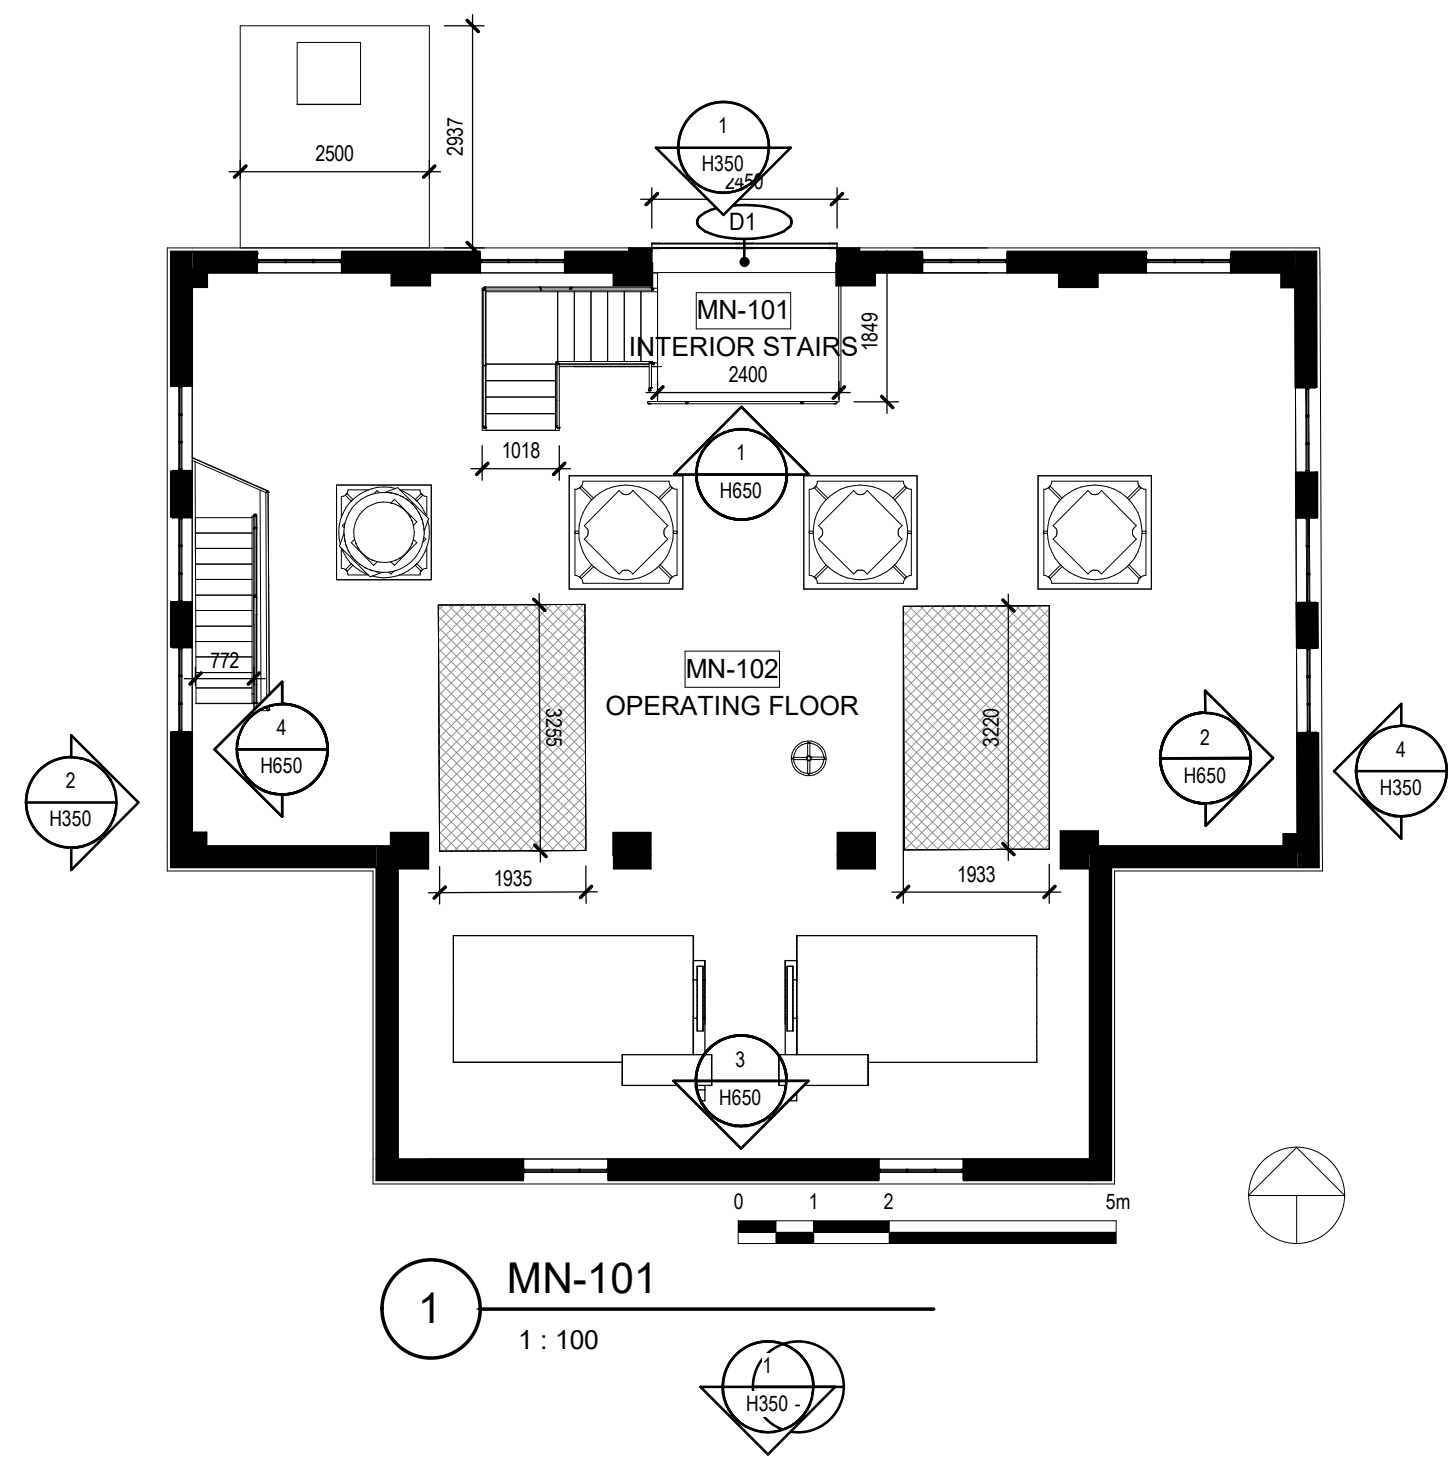


1 MN-101
1 : 100

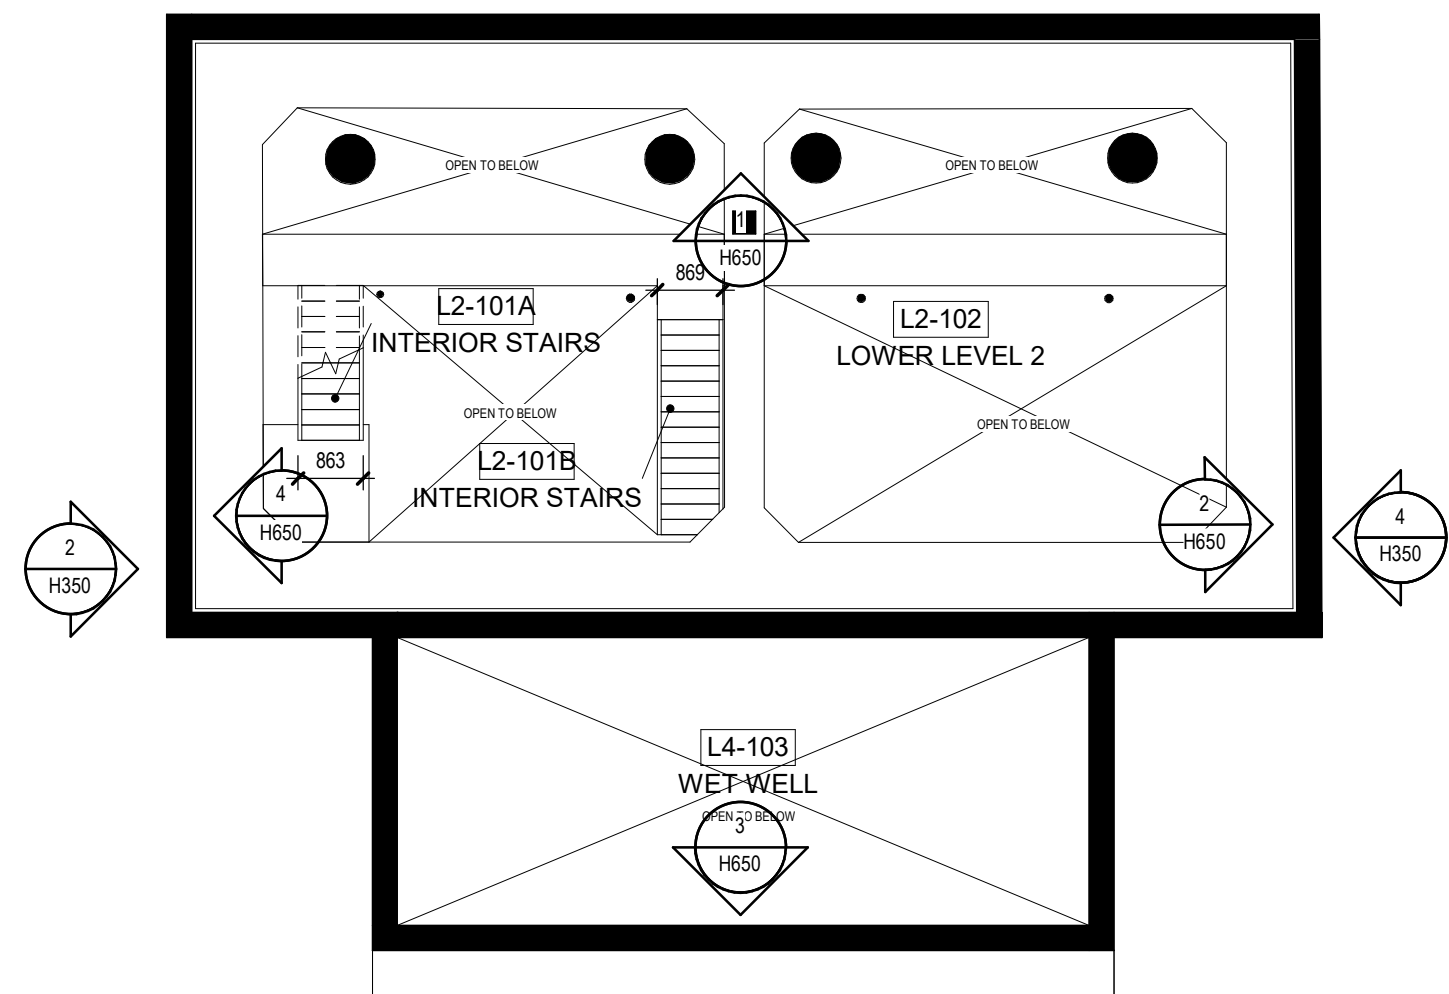


3 LOWER 2
1 : 100

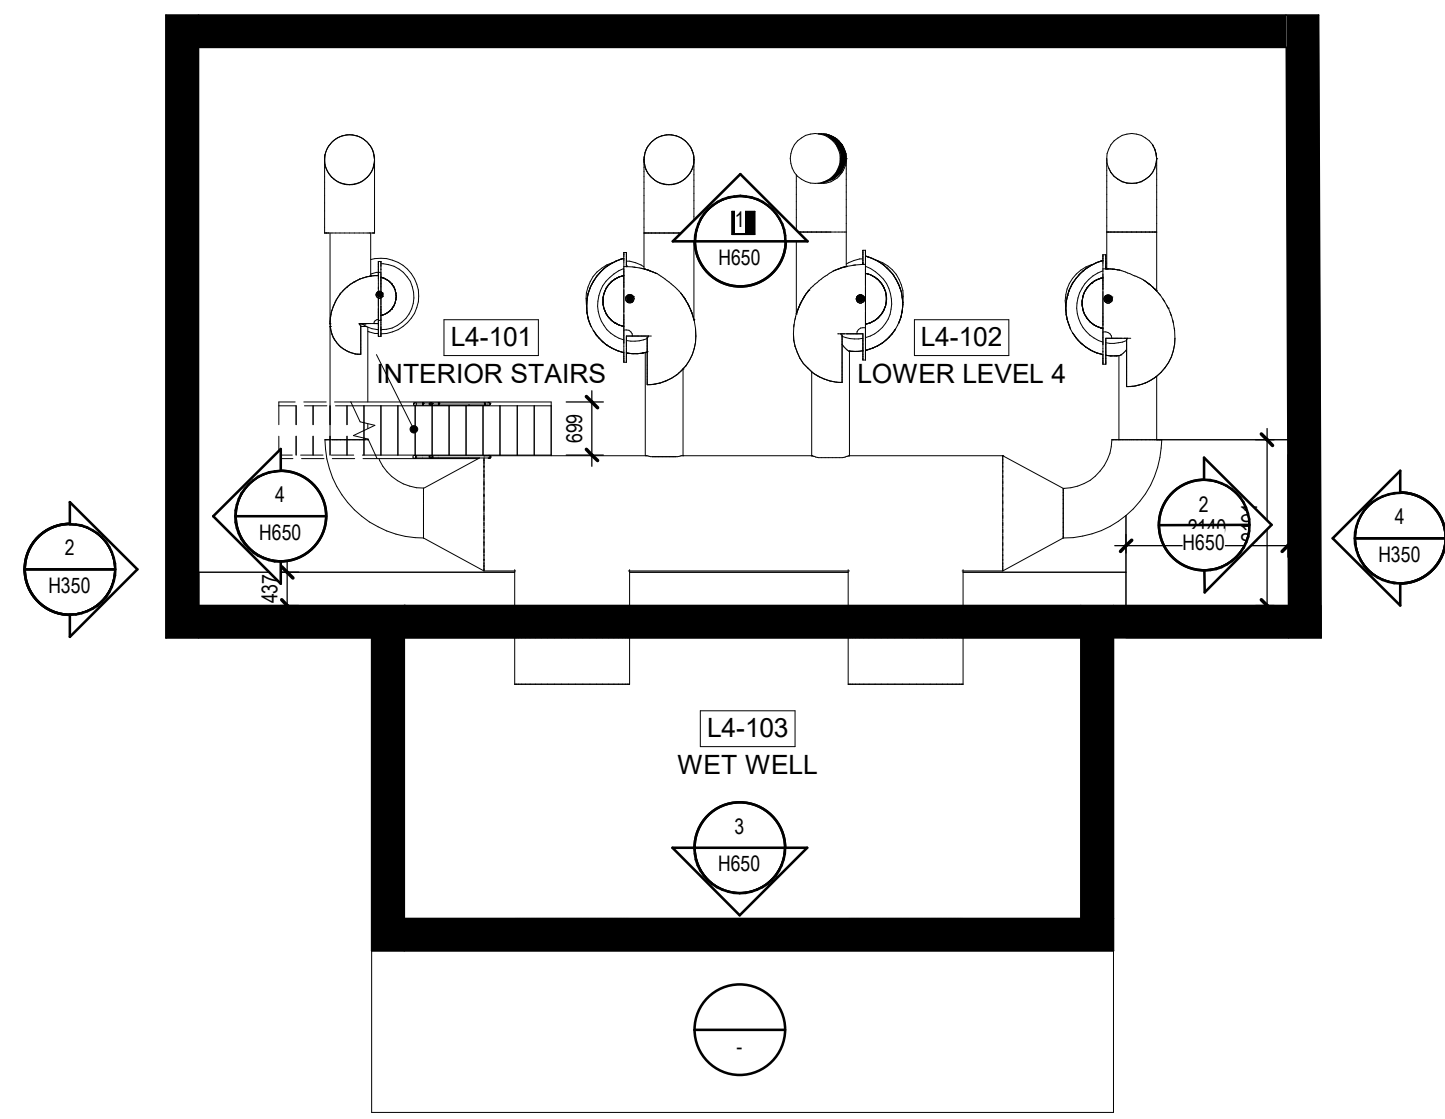


5 LOWER 4 - PUMP
1 : 100

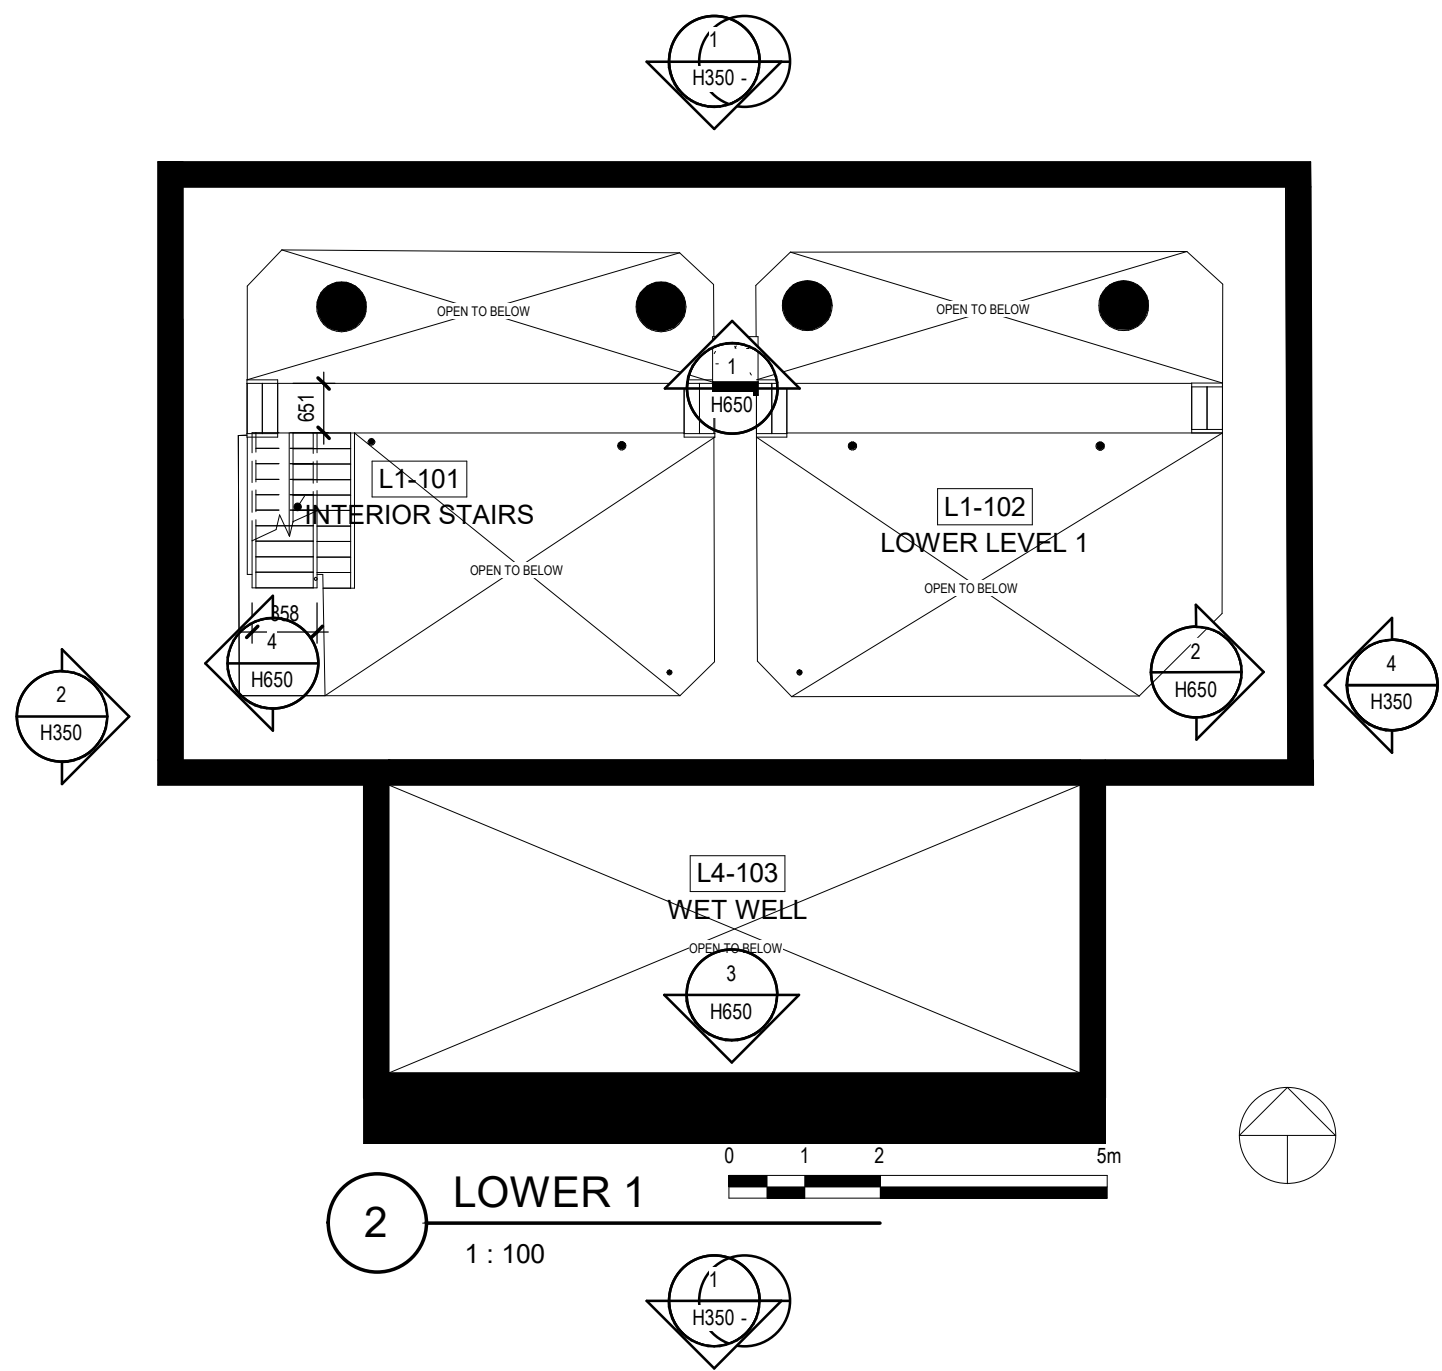


2 LOWER 1
1 : 100

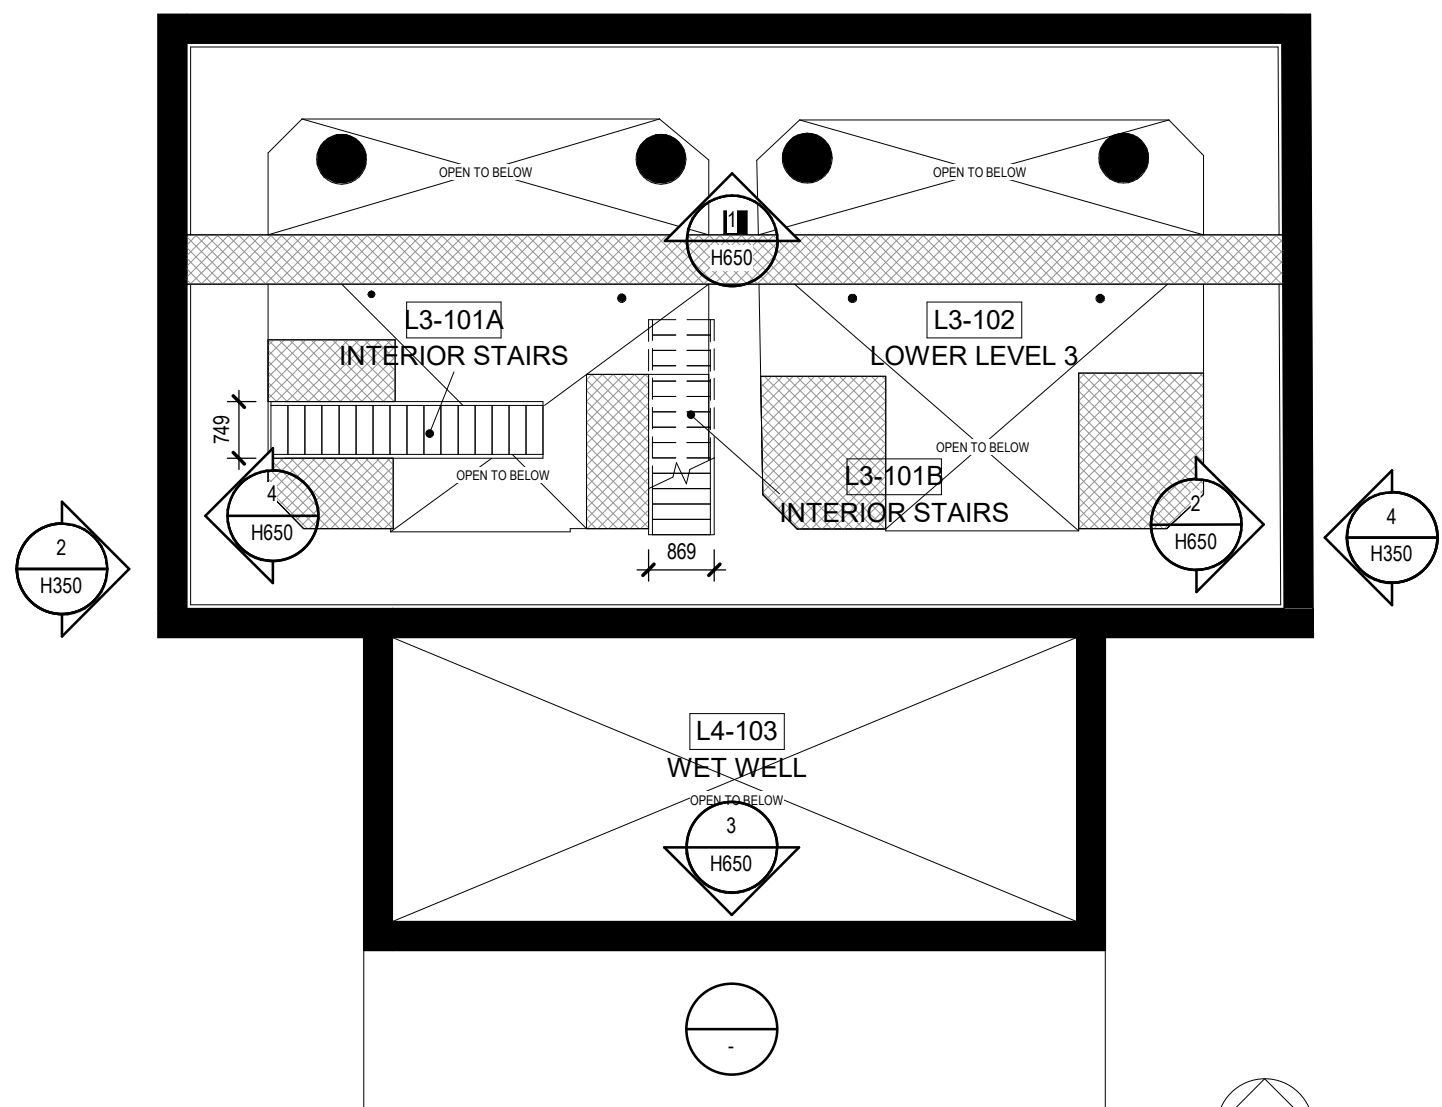

4 LOWER 3
1 : 100

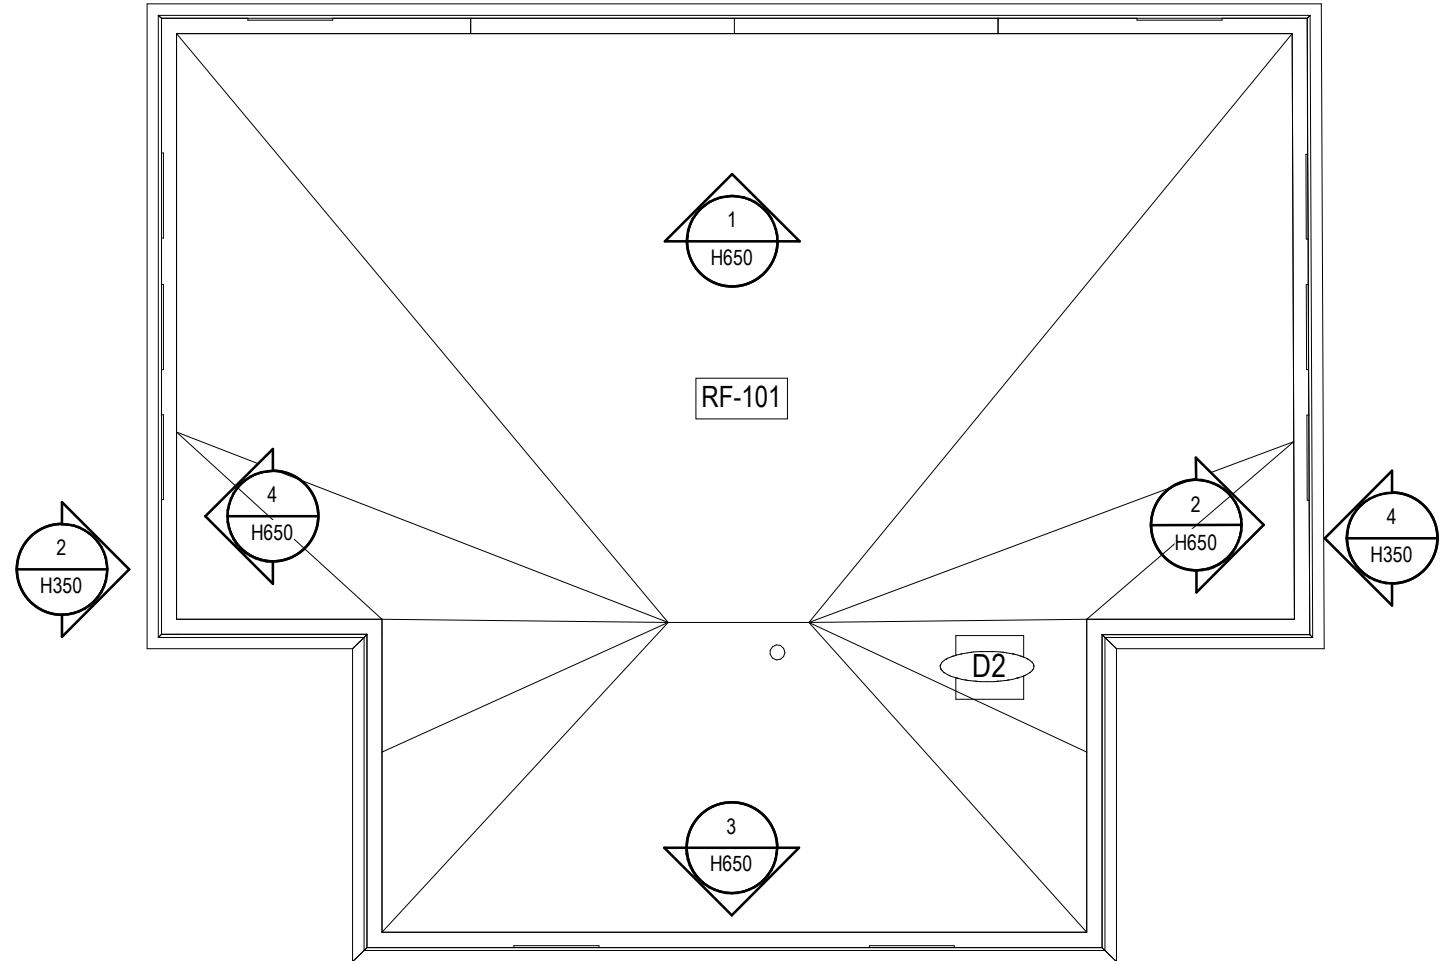

6 MN-102-ROOF
1 : 100

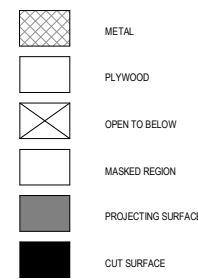

Consultant

PRIME CONSULTANT/ARCHITECTURAL
the marc boutin architectural collaborative inc.
205 9th Avenue SE, Suite 100
Calgary, AB, T2C 0R3
Contact: Richard Collier

HERITAGE
DFS Inc. Architecture & Design
400 Boulevard de Maisonneuve O.
Montreal, QC H3A 1L4
Contact: Evan Ostlund

ARCHITECTURAL
Saucier + Perrotte Architectes
7043 Waverly St.
Montreal, QC H2S 3J1
Contact: Anne-Marie Saucier

STRUCTURAL/CIVIL/BUILDING ENVELOPE
Reed Jones Christofferson Ltd
17415 102 Ave NW #100,
Edmonton, AB T5S 1J6
Contact: Frank Cavalliere (S), John Balla (C),
Nick Trovato (BE)

MECHANICAL/ELECTRICAL
Williams Engineering Canada Inc.
10085 Jasper Ave #200,
Edmonton, AB T5J 3B1
Contact: Sheldon Samborsky (M), Ben Rajewski (E)

BUILDING/FIRE CODE
Jensen Hughes
5855 9 St SE #106,
Calgary, AB T2H 1Z9
Contact: Kyle Duckworth

COST
BTY Group
404 8 Ave SW #645,
Calgary, AB T2P 0R9
Contact: Michael Giesert

INDIGENITY
Nahwegahnee
1205 - 10903 103 Ave NW,
Edmonton, Alberta, T5K 2X6
Contact: Hunter Cardinal

CONSULTANT PROJECT 20008

Seal

Permit

PRELIMINARY NOT FOR CONSTRUCTION



ROSSDALE POWER PLANT
ADVANCED ASSESSMENT AND
PRIORITY REHABILITATION -
HISTORIC BUILDING RECORD

CP-9496

Department INTEGRATED INFRASTRUCTURE SERVICES

No.	Description	Date
1	EXAMPLE	2021-01-13
2	DRAFT	2021-02-12
3	CORRECTION	2021-03-04

Location ID ROS108


Description

PUMP HOUSE #1
BUILDING RECORD


Drawing
Title

PLAN


Discipline	HERITAGE	Drawn	KC
Volume		Drawing Number	
Sheet	H200		
File			

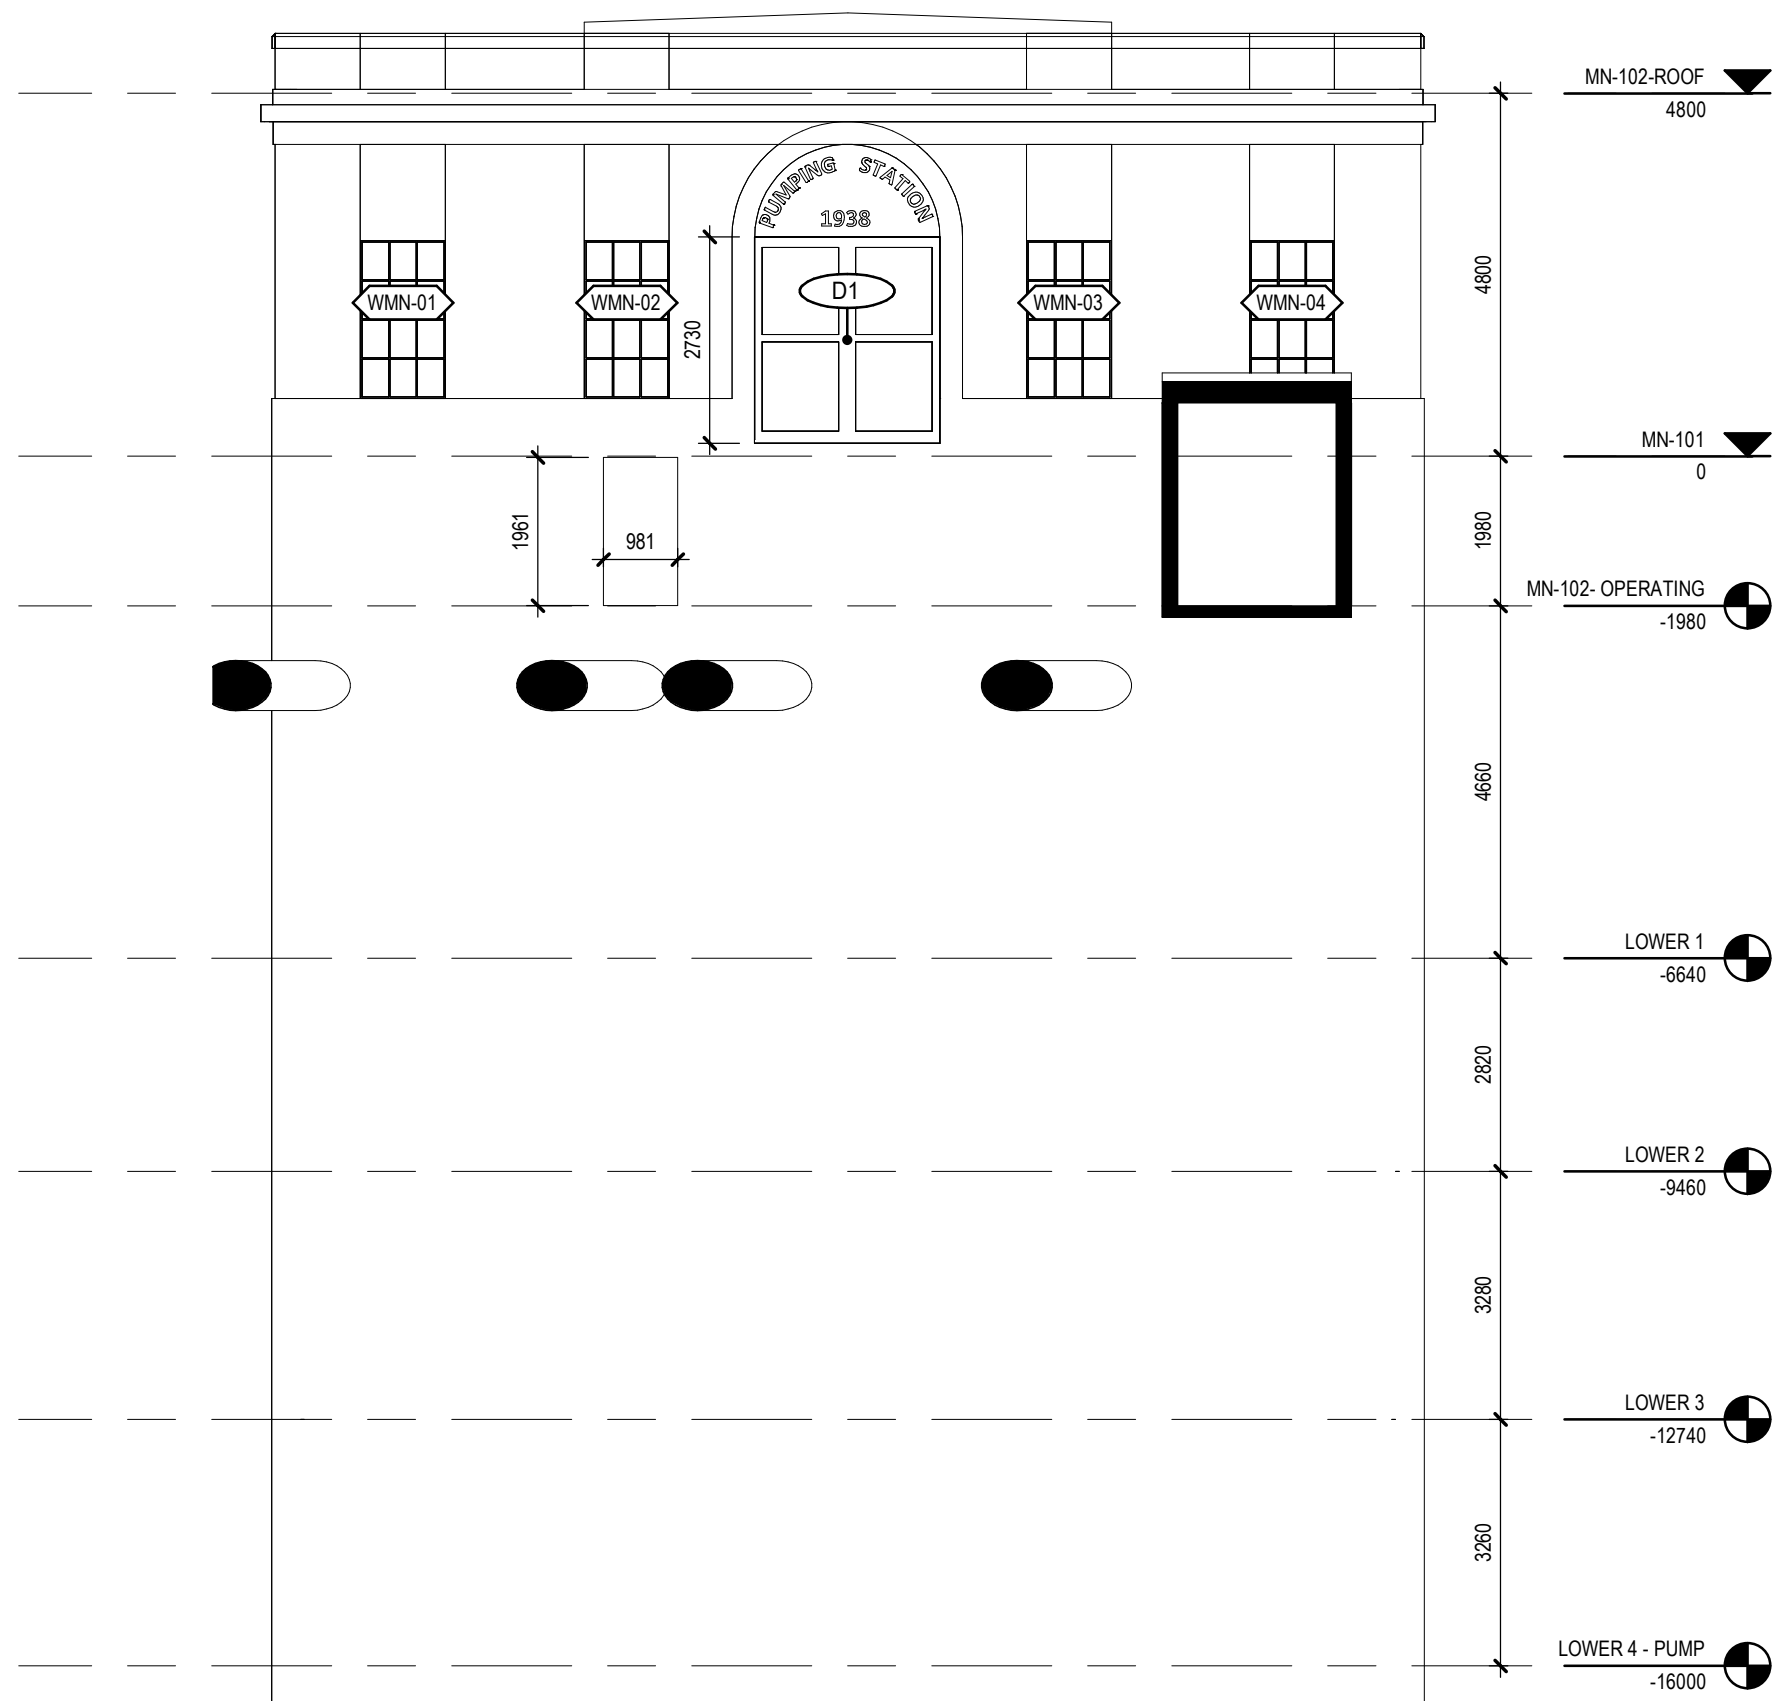


1 ELEVATION NORTH
1 : 100

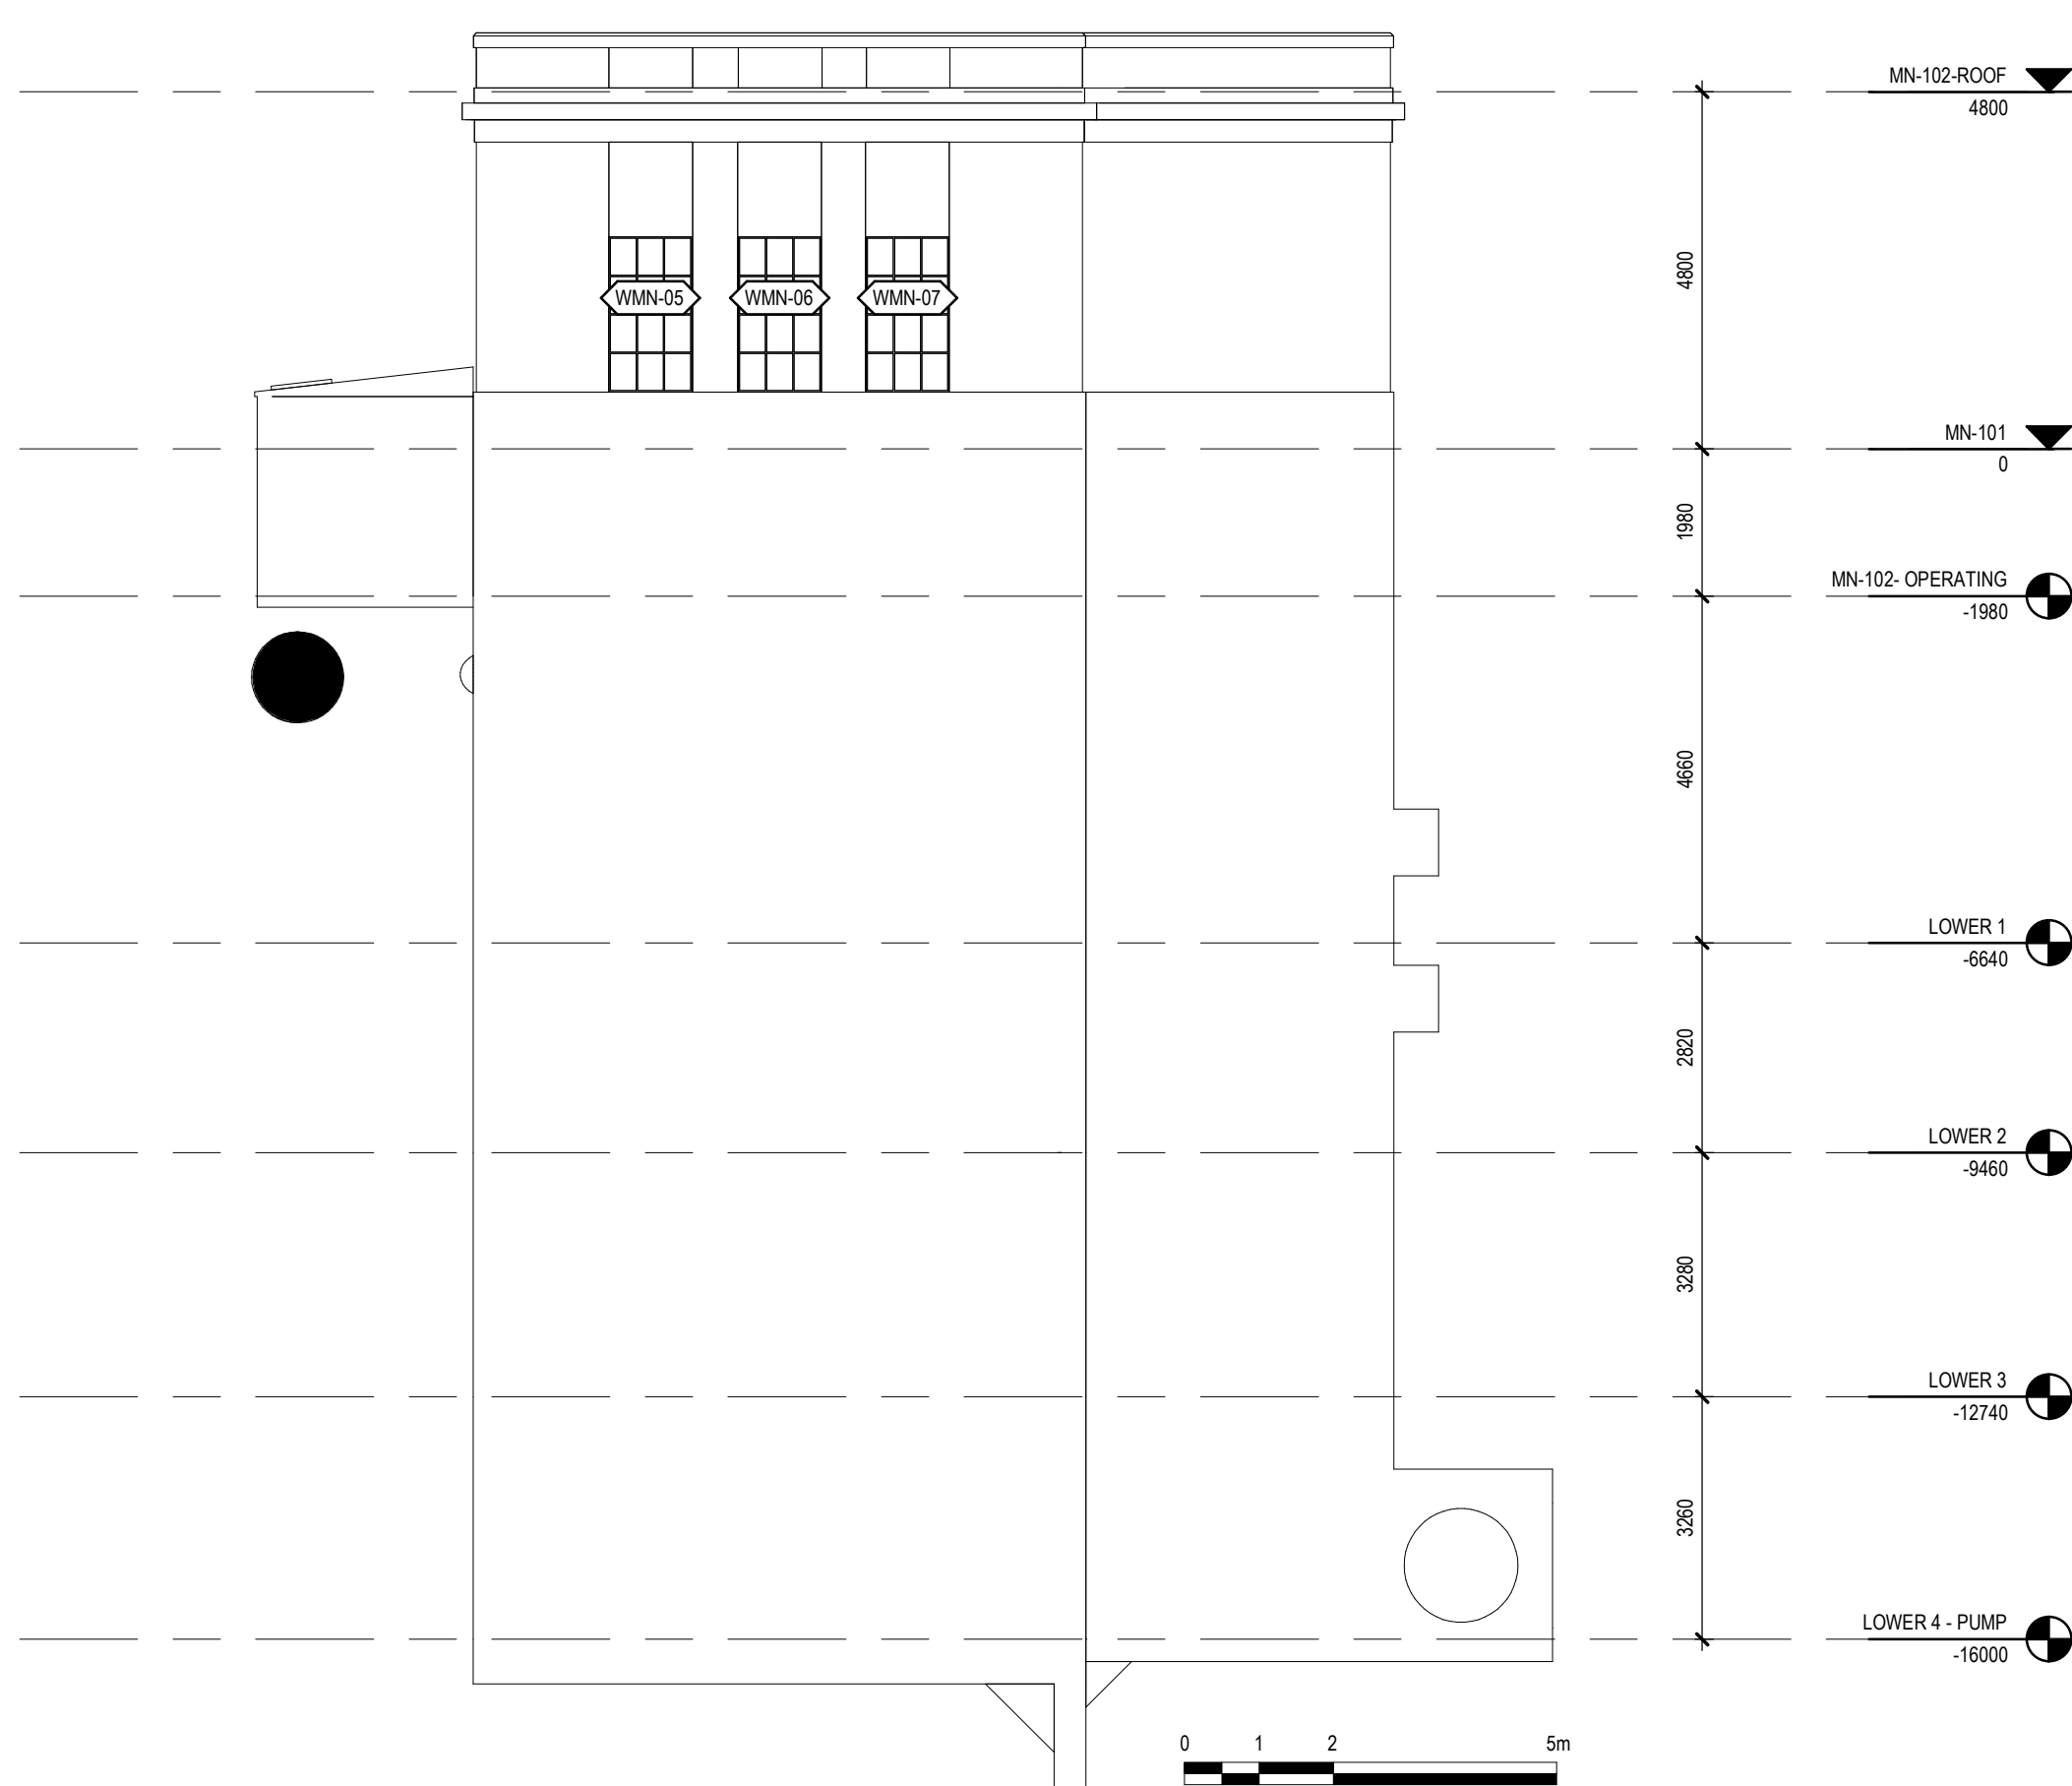


2 ELEVATION EAST
1 : 100

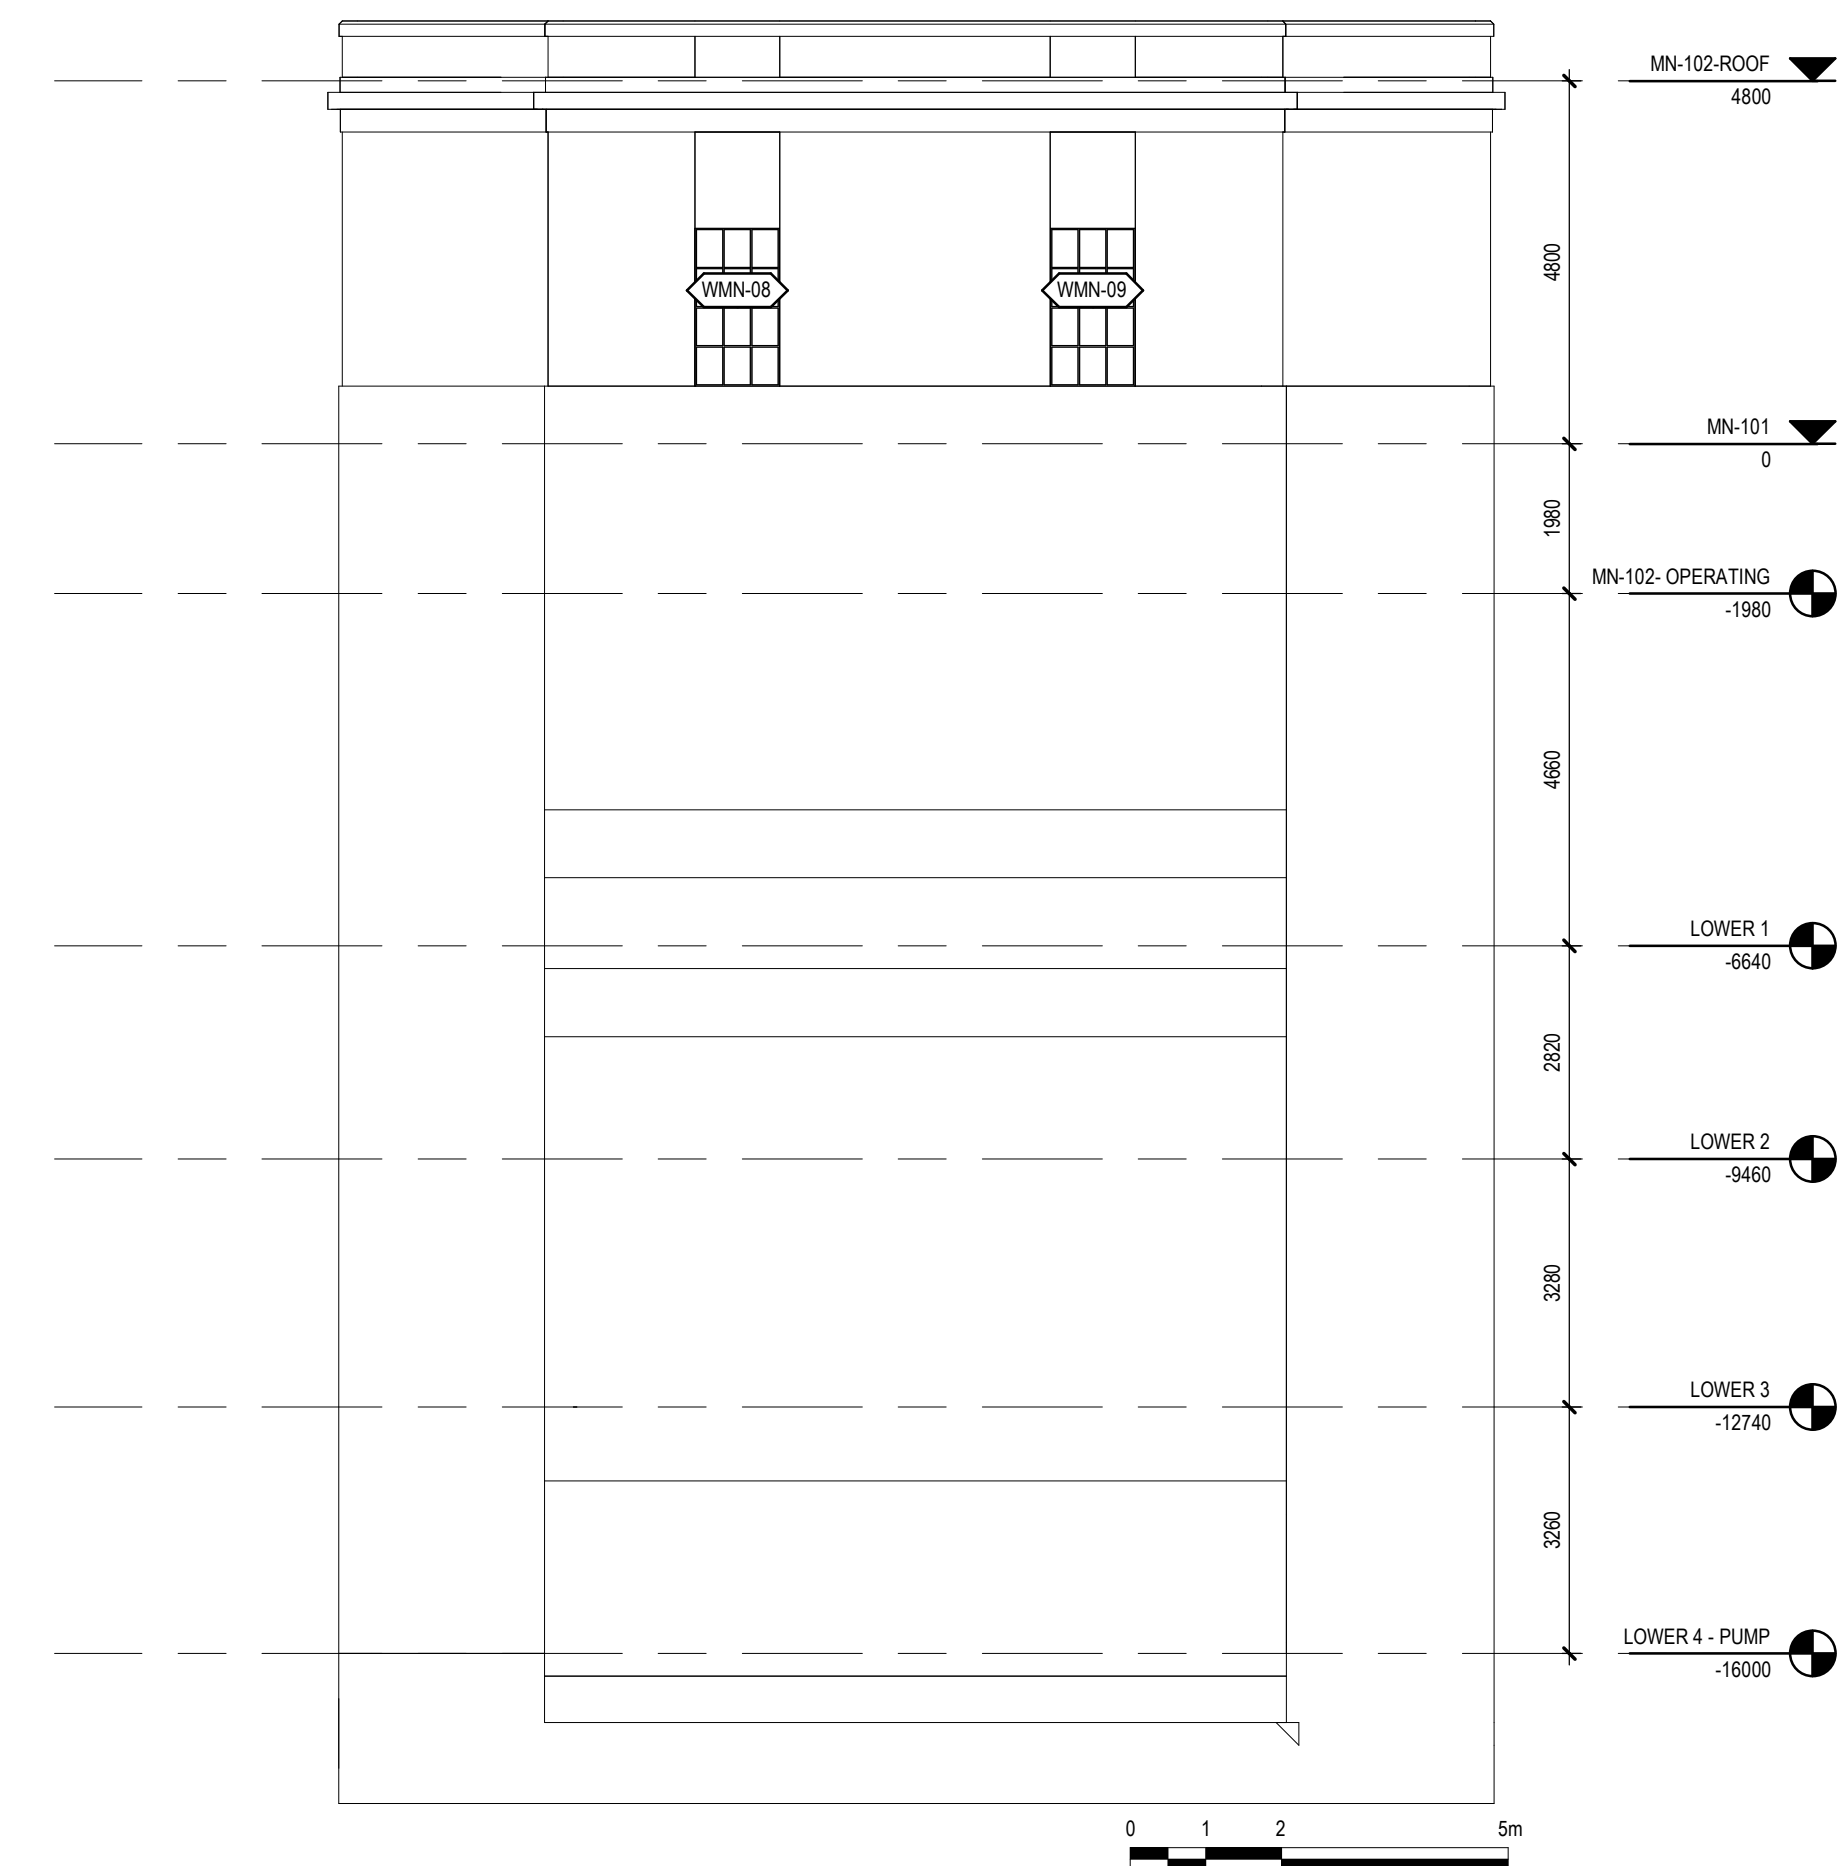

3 ELEVATION SOUTH
1 : 100

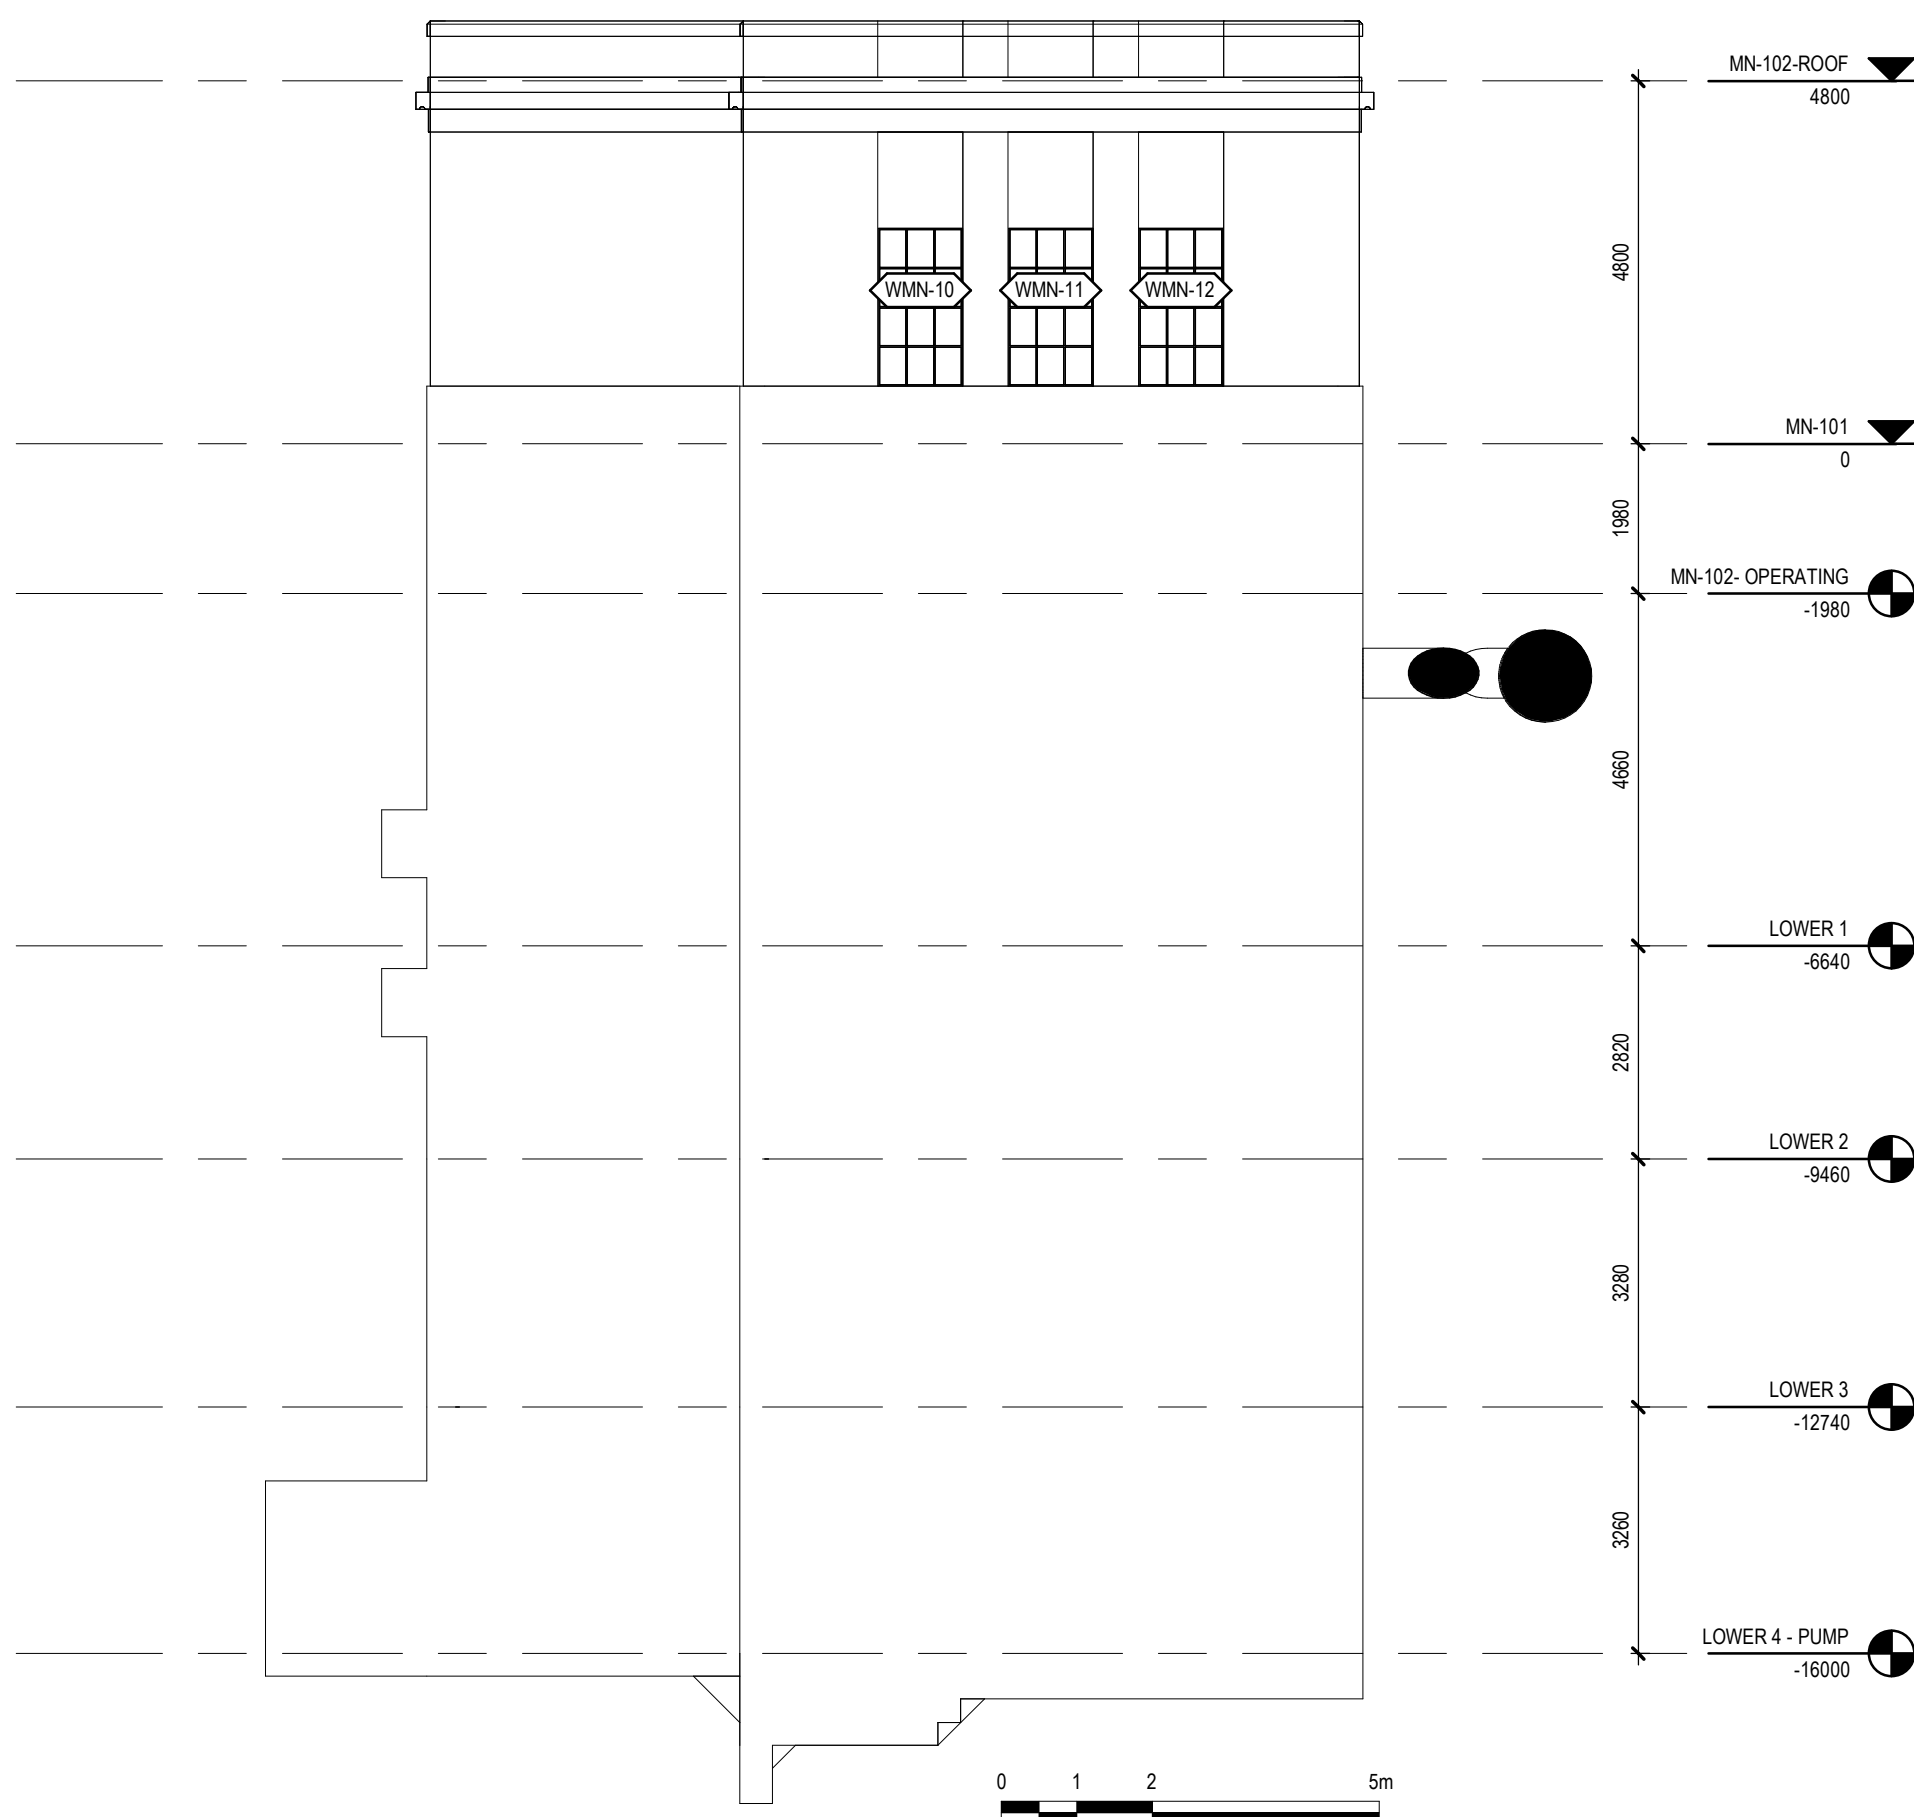

4 ELEVATION WEST
1 : 100

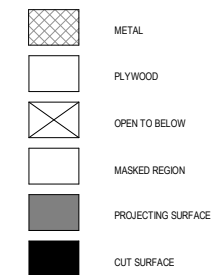

Consultant

PRIME CONSULTANT/ARCHITECTURAL
the marc boutin architectural collaborative inc.
205 9th Avenue SE, Suite 100
Calgary, AB, T2C 0R3
Contact: Richard Colter

HERITAGE
DFS Inc. Architecture & Design
400 Boulevard de Maisonneuve O,
Montreal, QC H3A 1L4
Contact: Evan Ostend

ARCHITECTURAL
Saucier + Perrotte Architectes
7043 Waverly St.
Montreal, QC H2S 3J1
Contact: Anne-Marie Saucier


STRUCTURAL/CIVIL/BUILDING ENVELOPE
Reed Jones Christofferson Ltd
17415 102 Ave NW #100,
Edmonton, AB T5S 1J6
Contact: Frank Cavaliere (S), John Balla (C),
Nick Trovati (RE)

MECHANICAL/ELECTRICAL
Williams Engineering Canada Inc.
10085 Jasper Ave #200,
Edmonton, AB T5J 3B1
Contact: Sheldon Samborsky (M), Ben Rajewski (E)

BUILDING/FIRE CODE
Jensen Hughes
5855 9 St SE #106,
Calgary, AB T2H 1Z9
Contact: Kyle Duckworth

COST
BTY Group
404 8 Ave SW #645,
Calgary, AB T2P 0R9
Contact: Michael Gabelt

INDIGENITY
Nahwegahnee
1205 - 10903 103 Ave NW,
Edmonton, Alberta, T5K 2X6
Contact: Hunter Cardinal

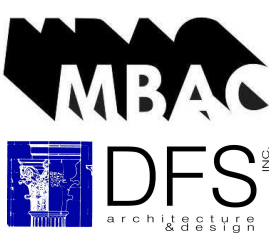

CONSULTANT PROJECT 20008

Seal	Permit
PRELIMINARY NOT FOR CONSTRUCTION	

ROSSDALE POWER PLANT
ADVANCED ASSESSMENT AND
PRIORITY REHABILITATION -
HISTORIC BUILDING RECORD

CP-9496


Department INTEGRATED INFRASTRUCTURE SERVICES

No.	Description	Date
1	EXAMPLE	2021-01-13
2	DRAFT	2021-02-12
3	CORRECTION	2021-03-04


Location ID ROS108
Description PUMP HOUSE #1
BUILDING RECORD

Drawing
Title EXTERIOR ELEVATIONS


Discipline	HERITAGE	Drawn	KC
Volume			
Sheet	H300	Drawing Number	
File			

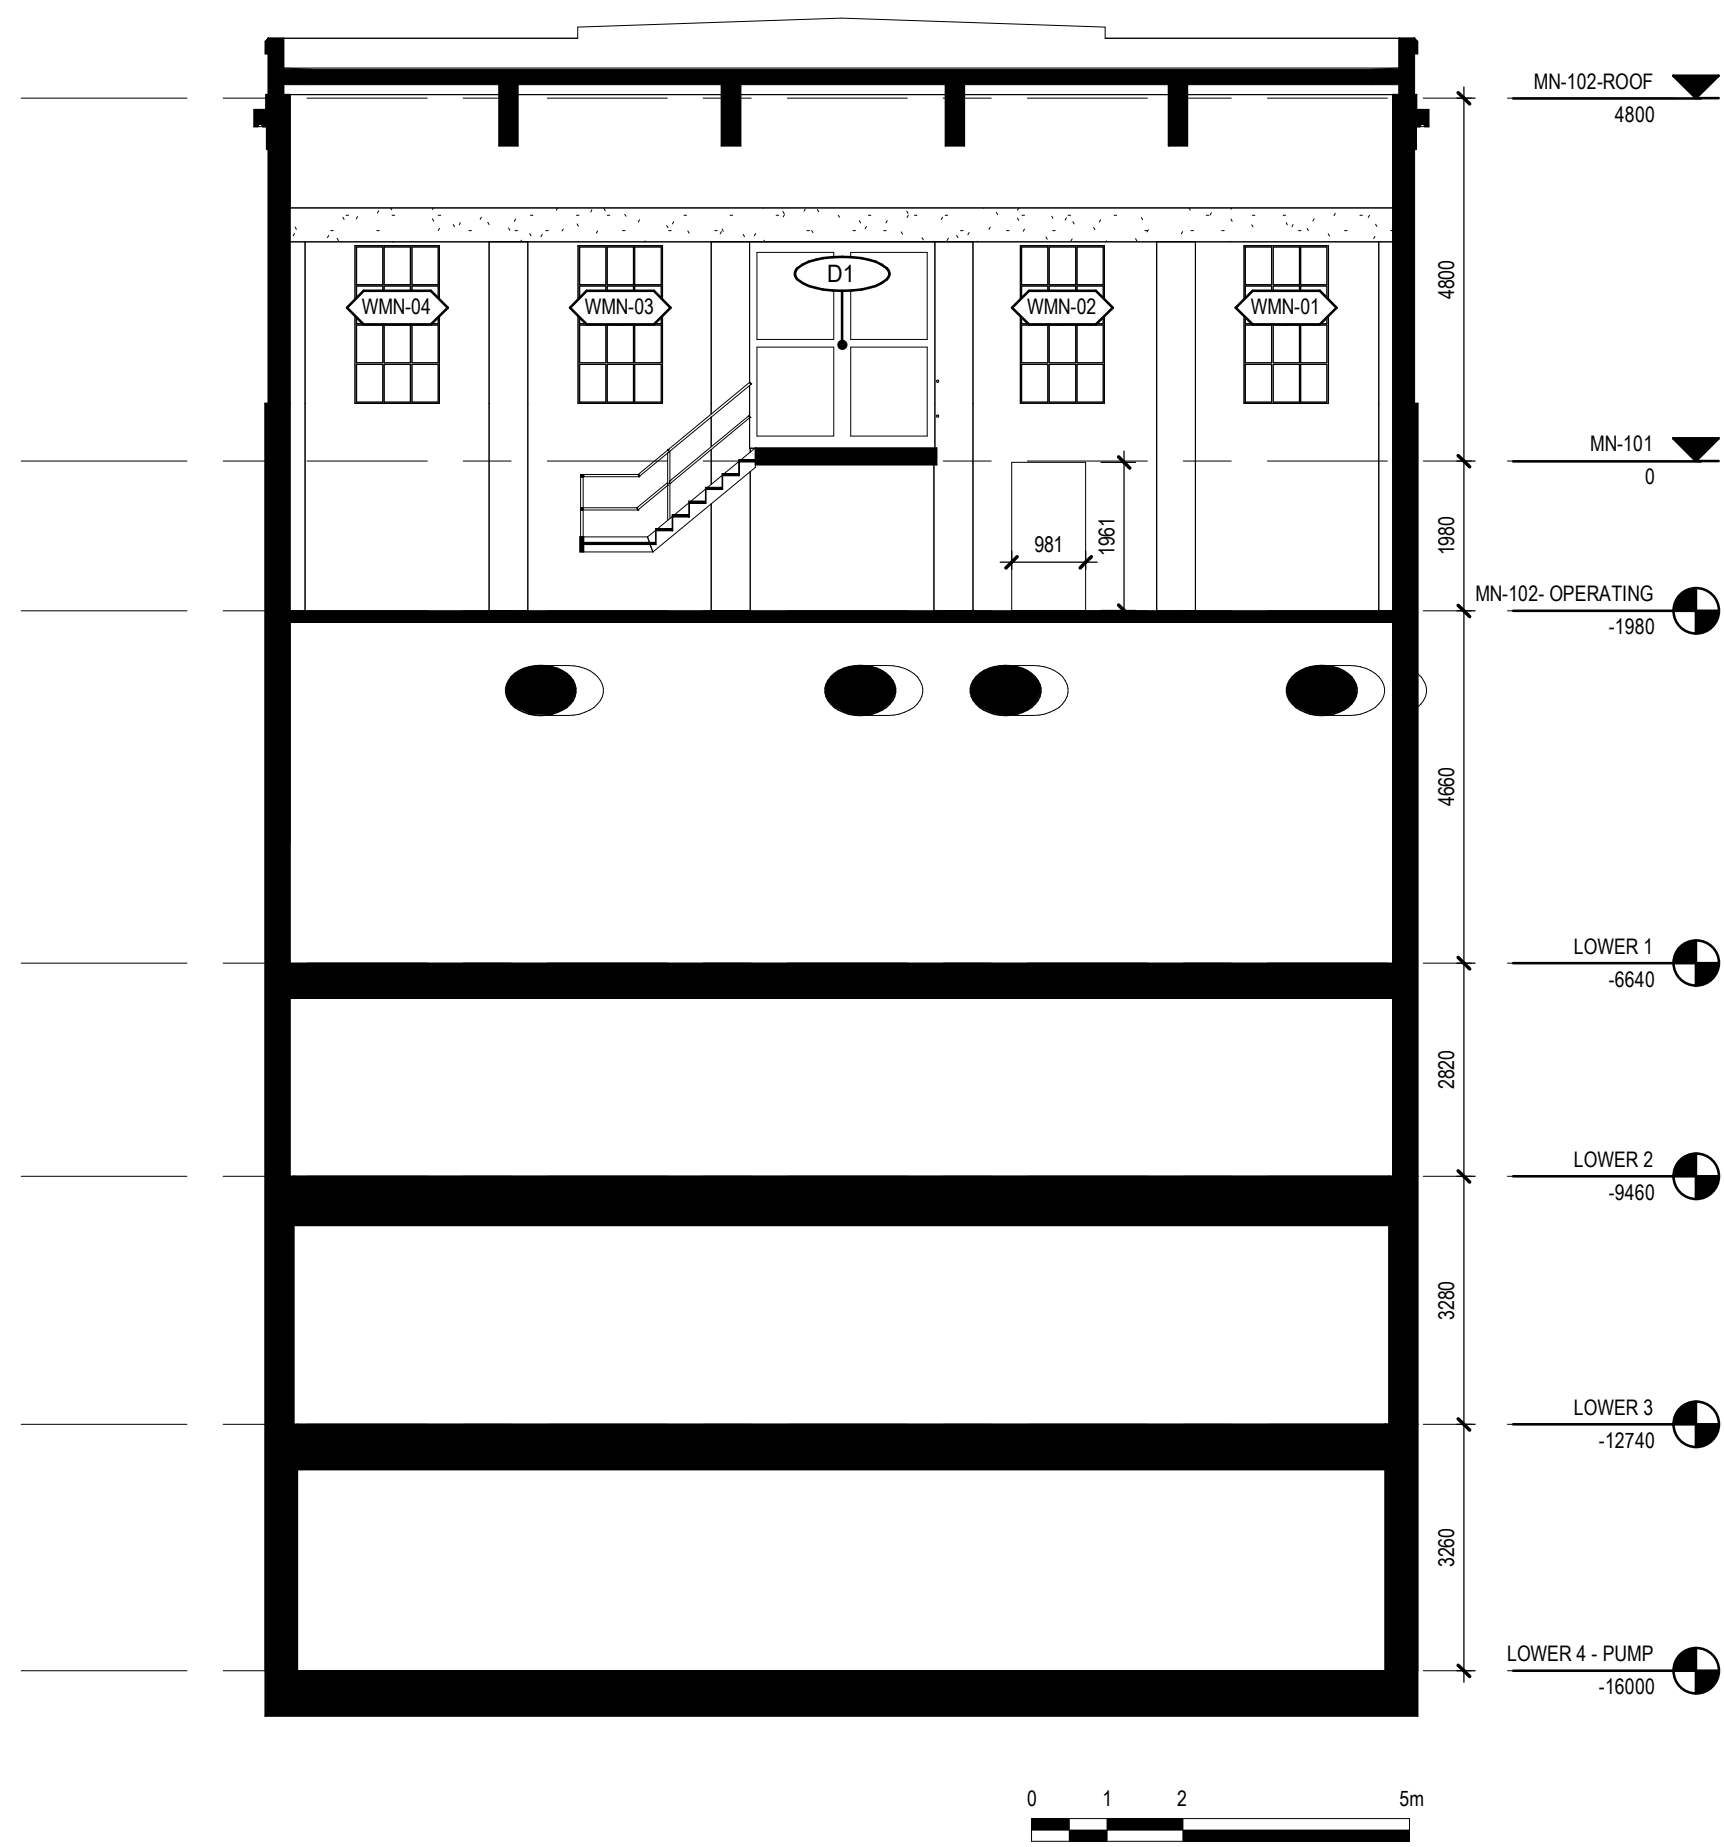


1 INTERIOR NORTH
1 : 100

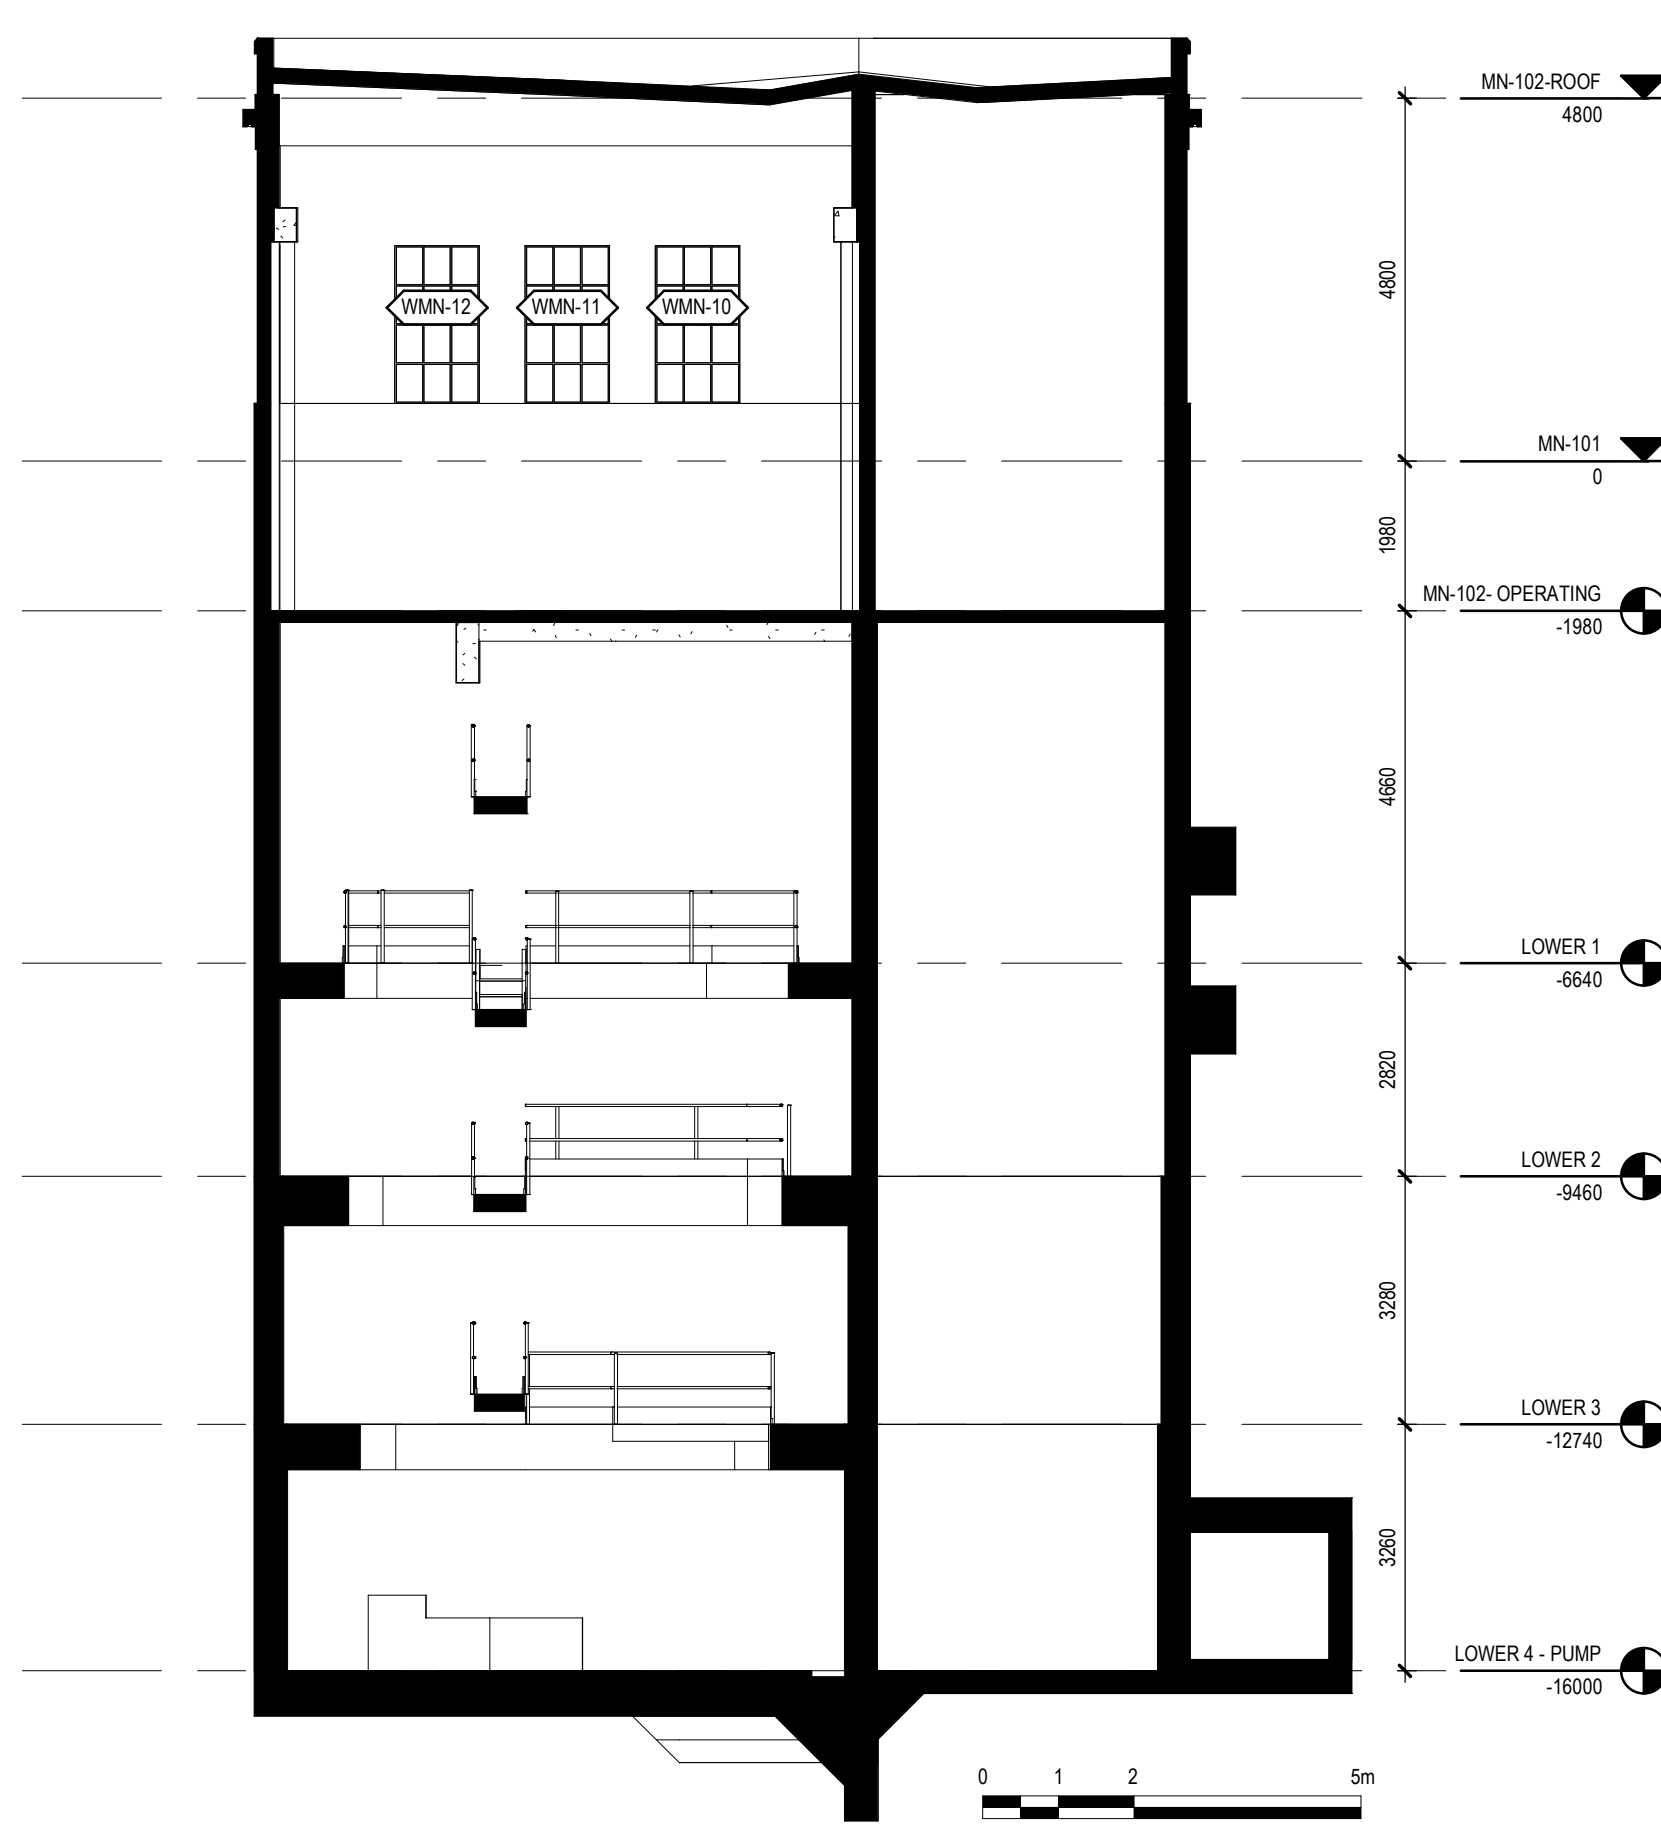


2 INTERIOR EAST
1 : 100

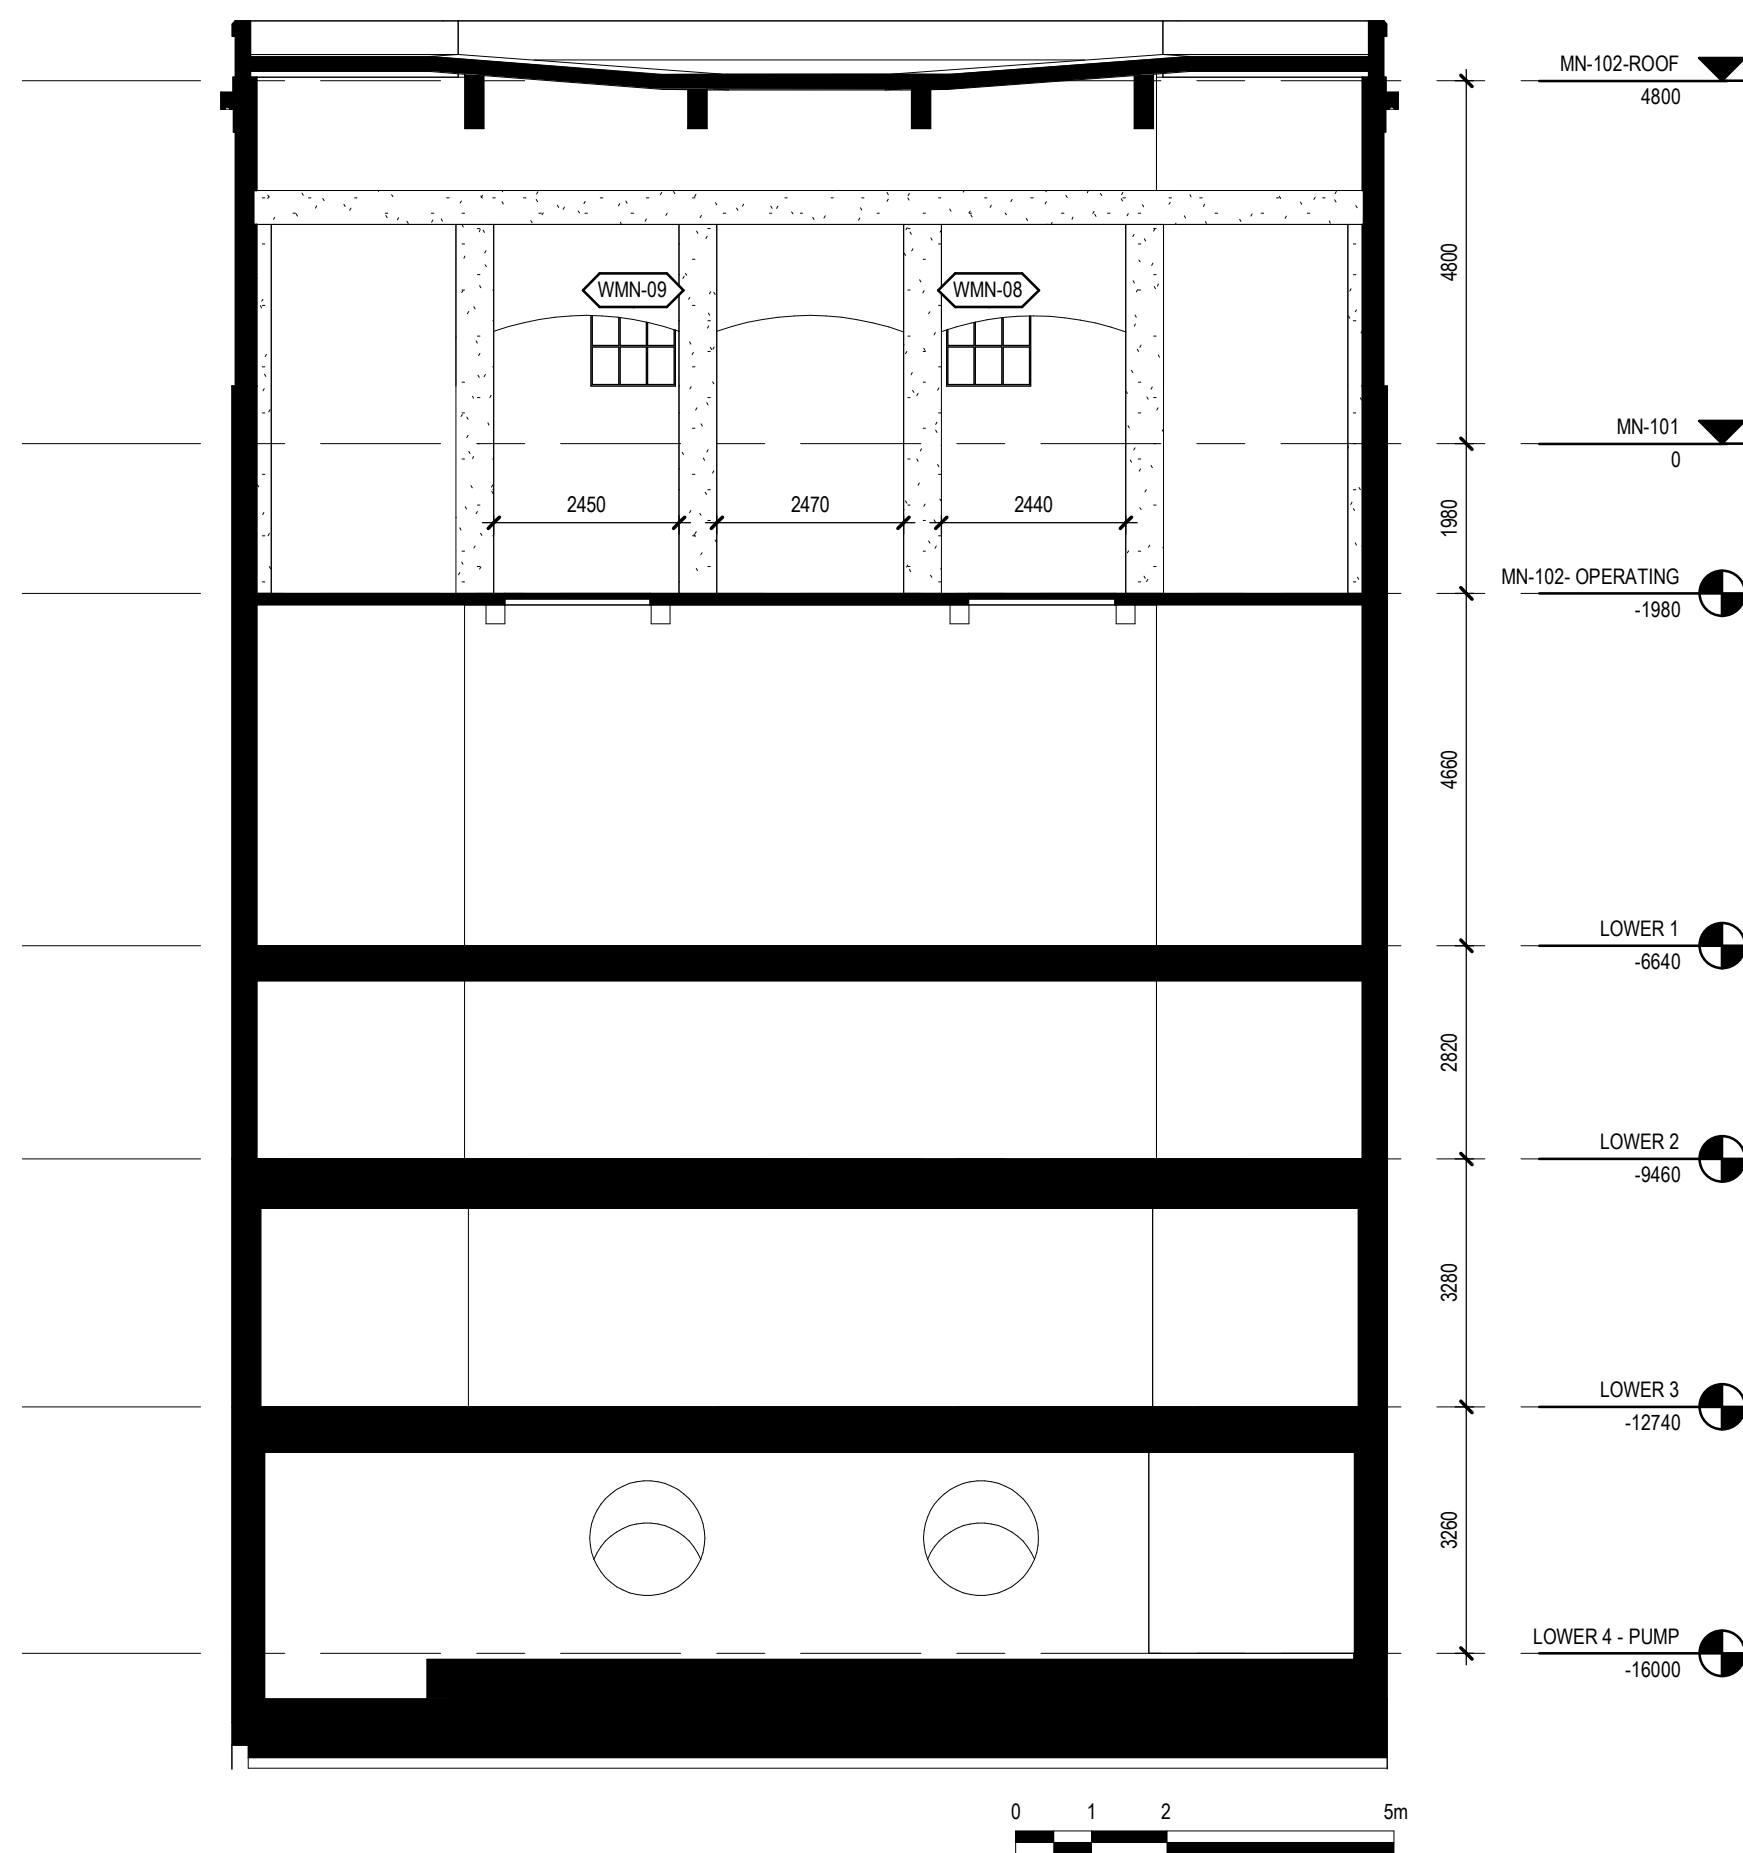

3 INTERIOR SOUTH
1 : 100

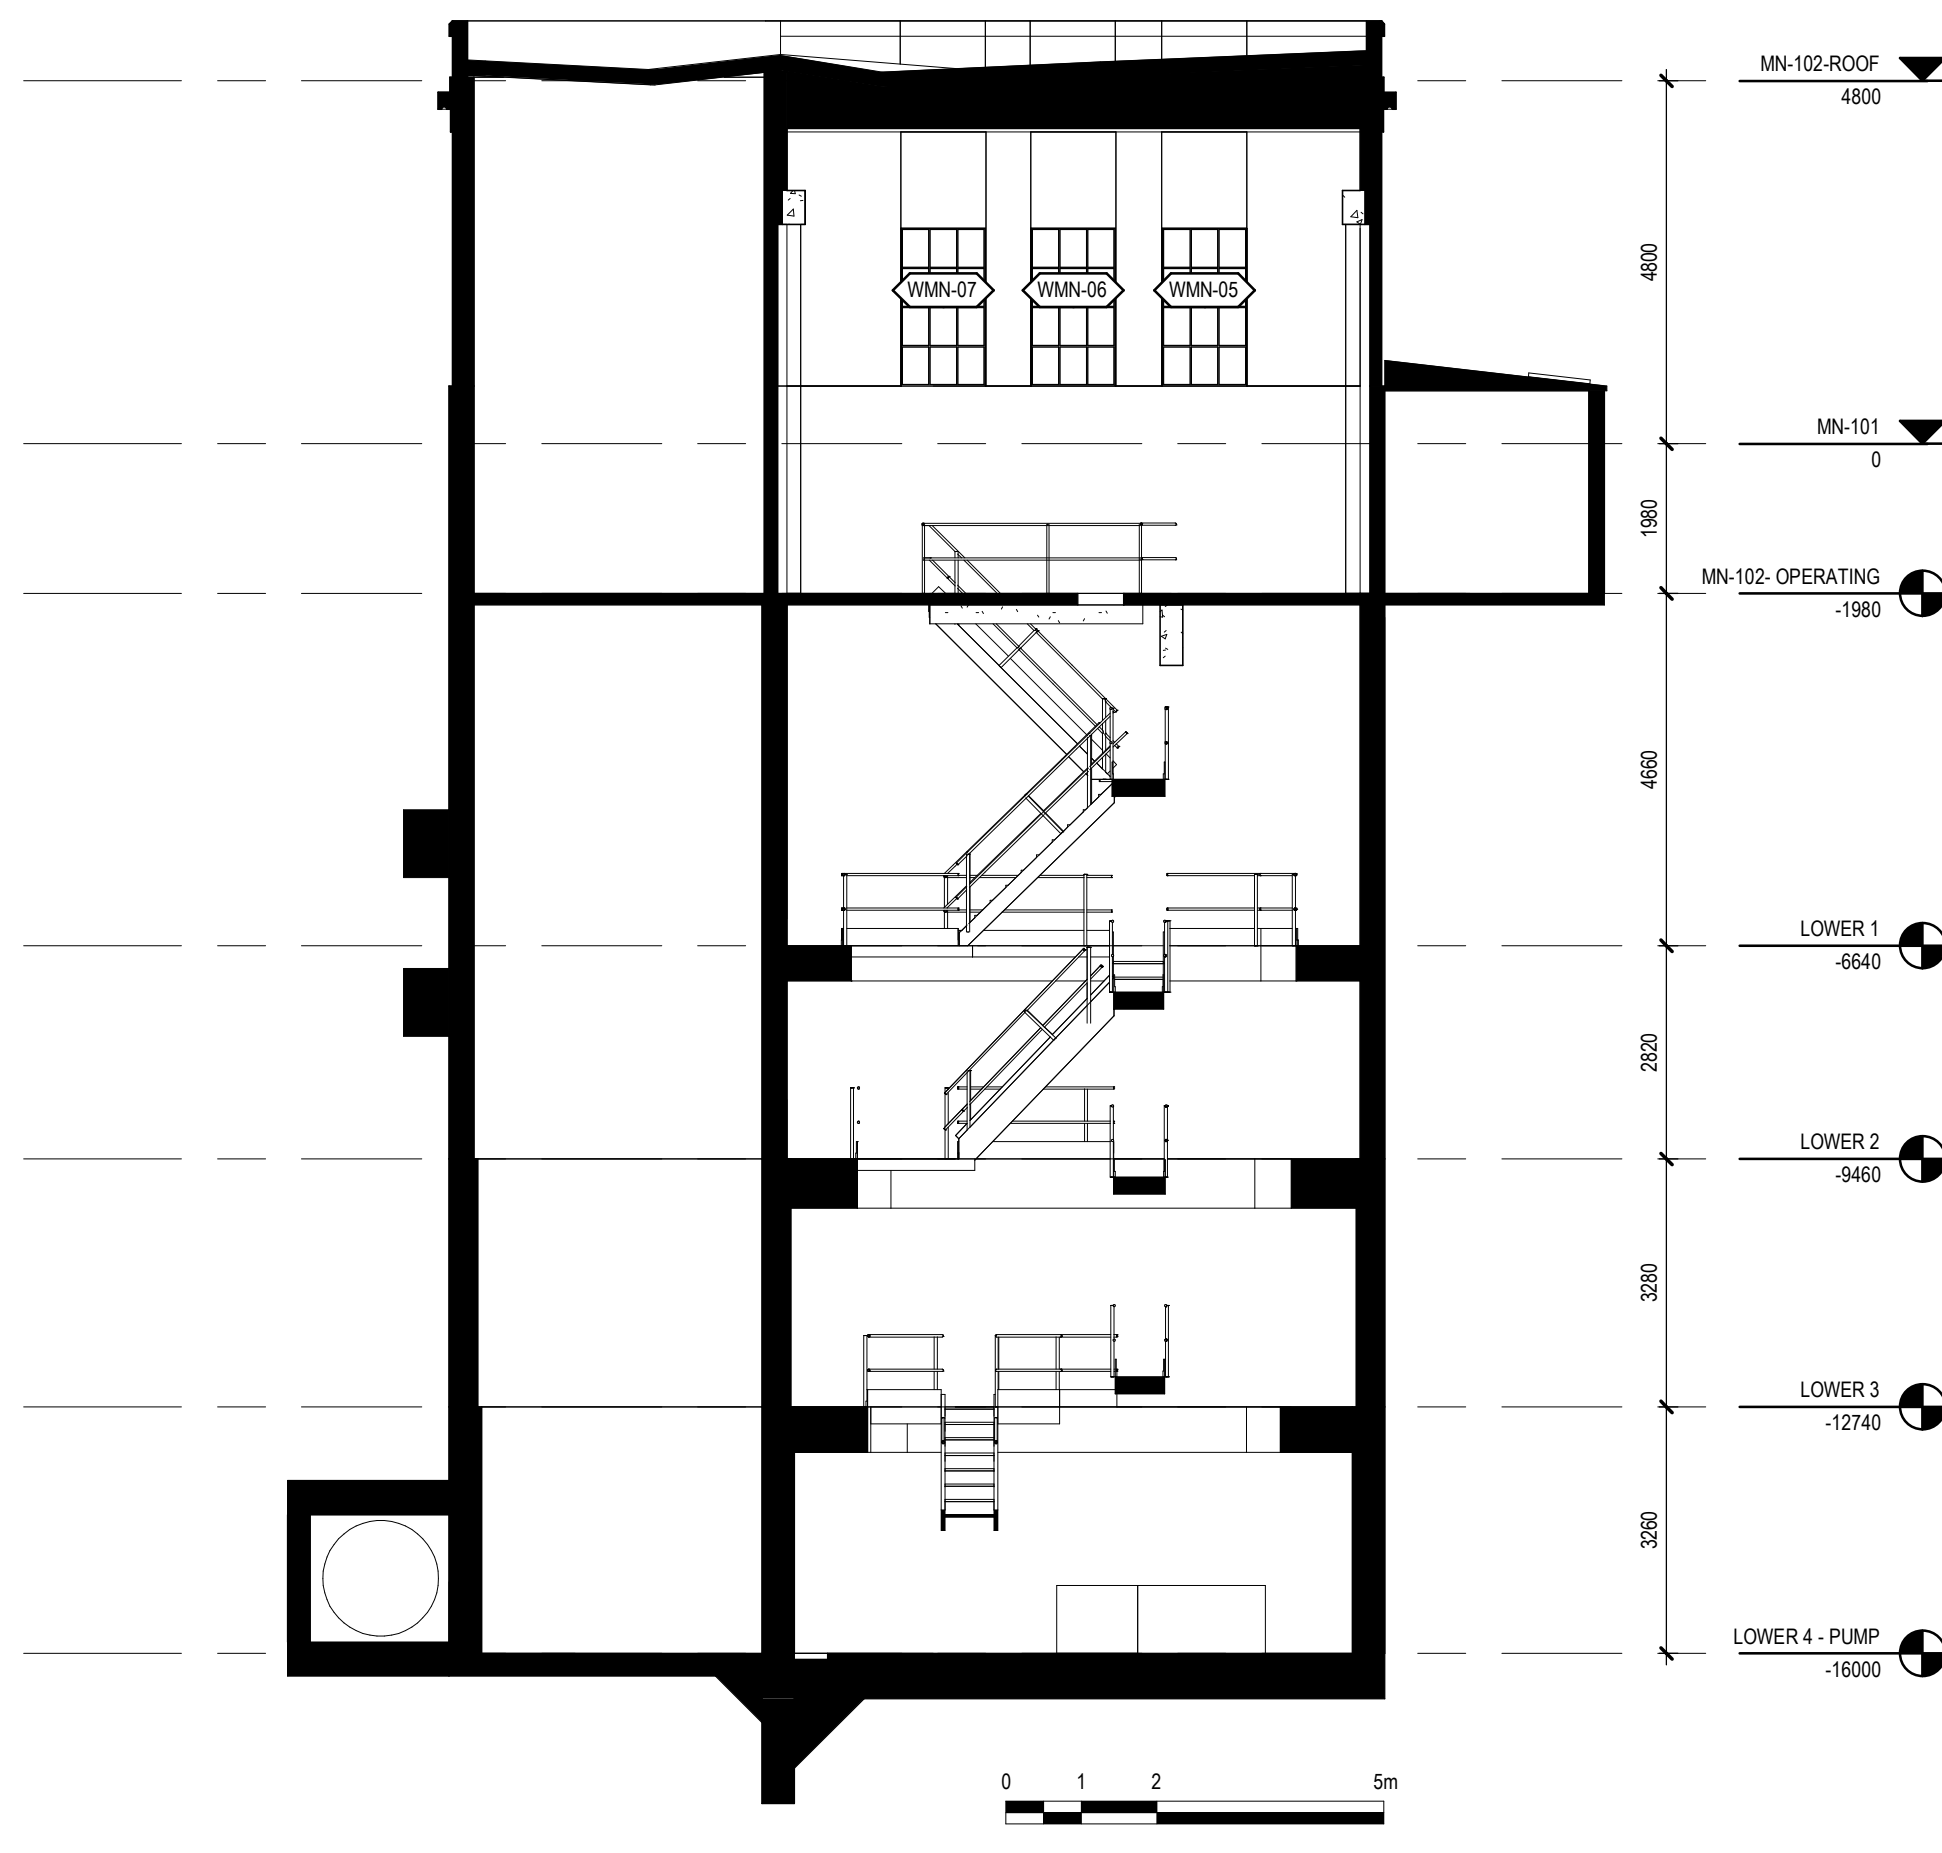

4 INTERIOR WEST
1 : 100

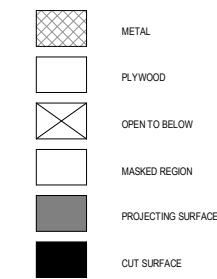

Consultant

PRIME CONSULTANT/ARCHITECTURAL
the marc boutin architectural collaborative inc.
205 9th Avenue SE, Suite 100
Calgary, AB, T2C 0R3
Contact: Richard Collier

MECHANICAL/ELECTRICAL
Williams Engineering Canada Inc.
10085 Jasper Ave #200,
Edmonton, AB T5J 3B1
Contact: Sheldon Samborsky (M), Ben Rajewski (E)

HERITAGE
DFS Inc. Architecture & Design
400 Boulevard de Maisonneuve O,
Montreal, QC H3A 1L4
Contact: Evan Ostend

ARCHITECTURAL
Saucier + Perrotte Architectes
7043 Waverly St,
Montreal, QC H2S 3J1
Contact: Anne-Marie Saucier

STRUCTURAL/CIVIL/BUILDING ENVELOPE
Reed Jones Christofferson Ltd
17415 102 Ave NW #100,
Edmonton, AB T5S 1J6
Contact: Frank Cavalliere (S), John Balla (C),
Nick Trovati (RE)

BUILDING/FIRE CODE
Jensen Hughes
5855 9 St SE #106,
Calgary, AB T2H 1Z9
Contact: Kyle Duckworth

COST
BTY Group
404 8 Ave SW #645,
Calgary, AB T2P 0R9
Contact: Michael Giesert

INDIGENITY
Nahayewin
1205 - 10903 103 Ave NW,
Edmonton, Alberta, T5K 2X6
Contact: Hunter Cardinal

CONSULTANT PROJECT 20008

Seal	Permit
	PRELIMINARY NOT FOR CONSTRUCTION

Edmonton

ROSSDALE POWER PLANT
ADVANCED ASSESSMENT AND
PRIORITY REHABILITATION -
HISTORIC BUILDING RECORD

CP-9496

Department INTEGRATED INFRASTRUCTURE SERVICES

No.	Description	Date
1	EXAMPLE	2021-01-13
2	DRAFT	2021-02-12
3	CORRECTION	2021-03-04

Location ID

Description

**PUMP HOUSE #1
BUILDING RECORD**

Drawing Title

INTERIOR ELEVATIONS

Discipline	HERITAGE	Drawn	KC
Volume		Drawing Number	
Sheet	H600		
File			