

Conditions Legend


Concrete Deterioration

- Missing Section
- Soil Deposits

Masonry Deterioration



- Terrazzo Spall
- Terrazzo Crack
- Cementitious Patch

The Conditions Legend is specific to the subject building of each report and conditions drawing set

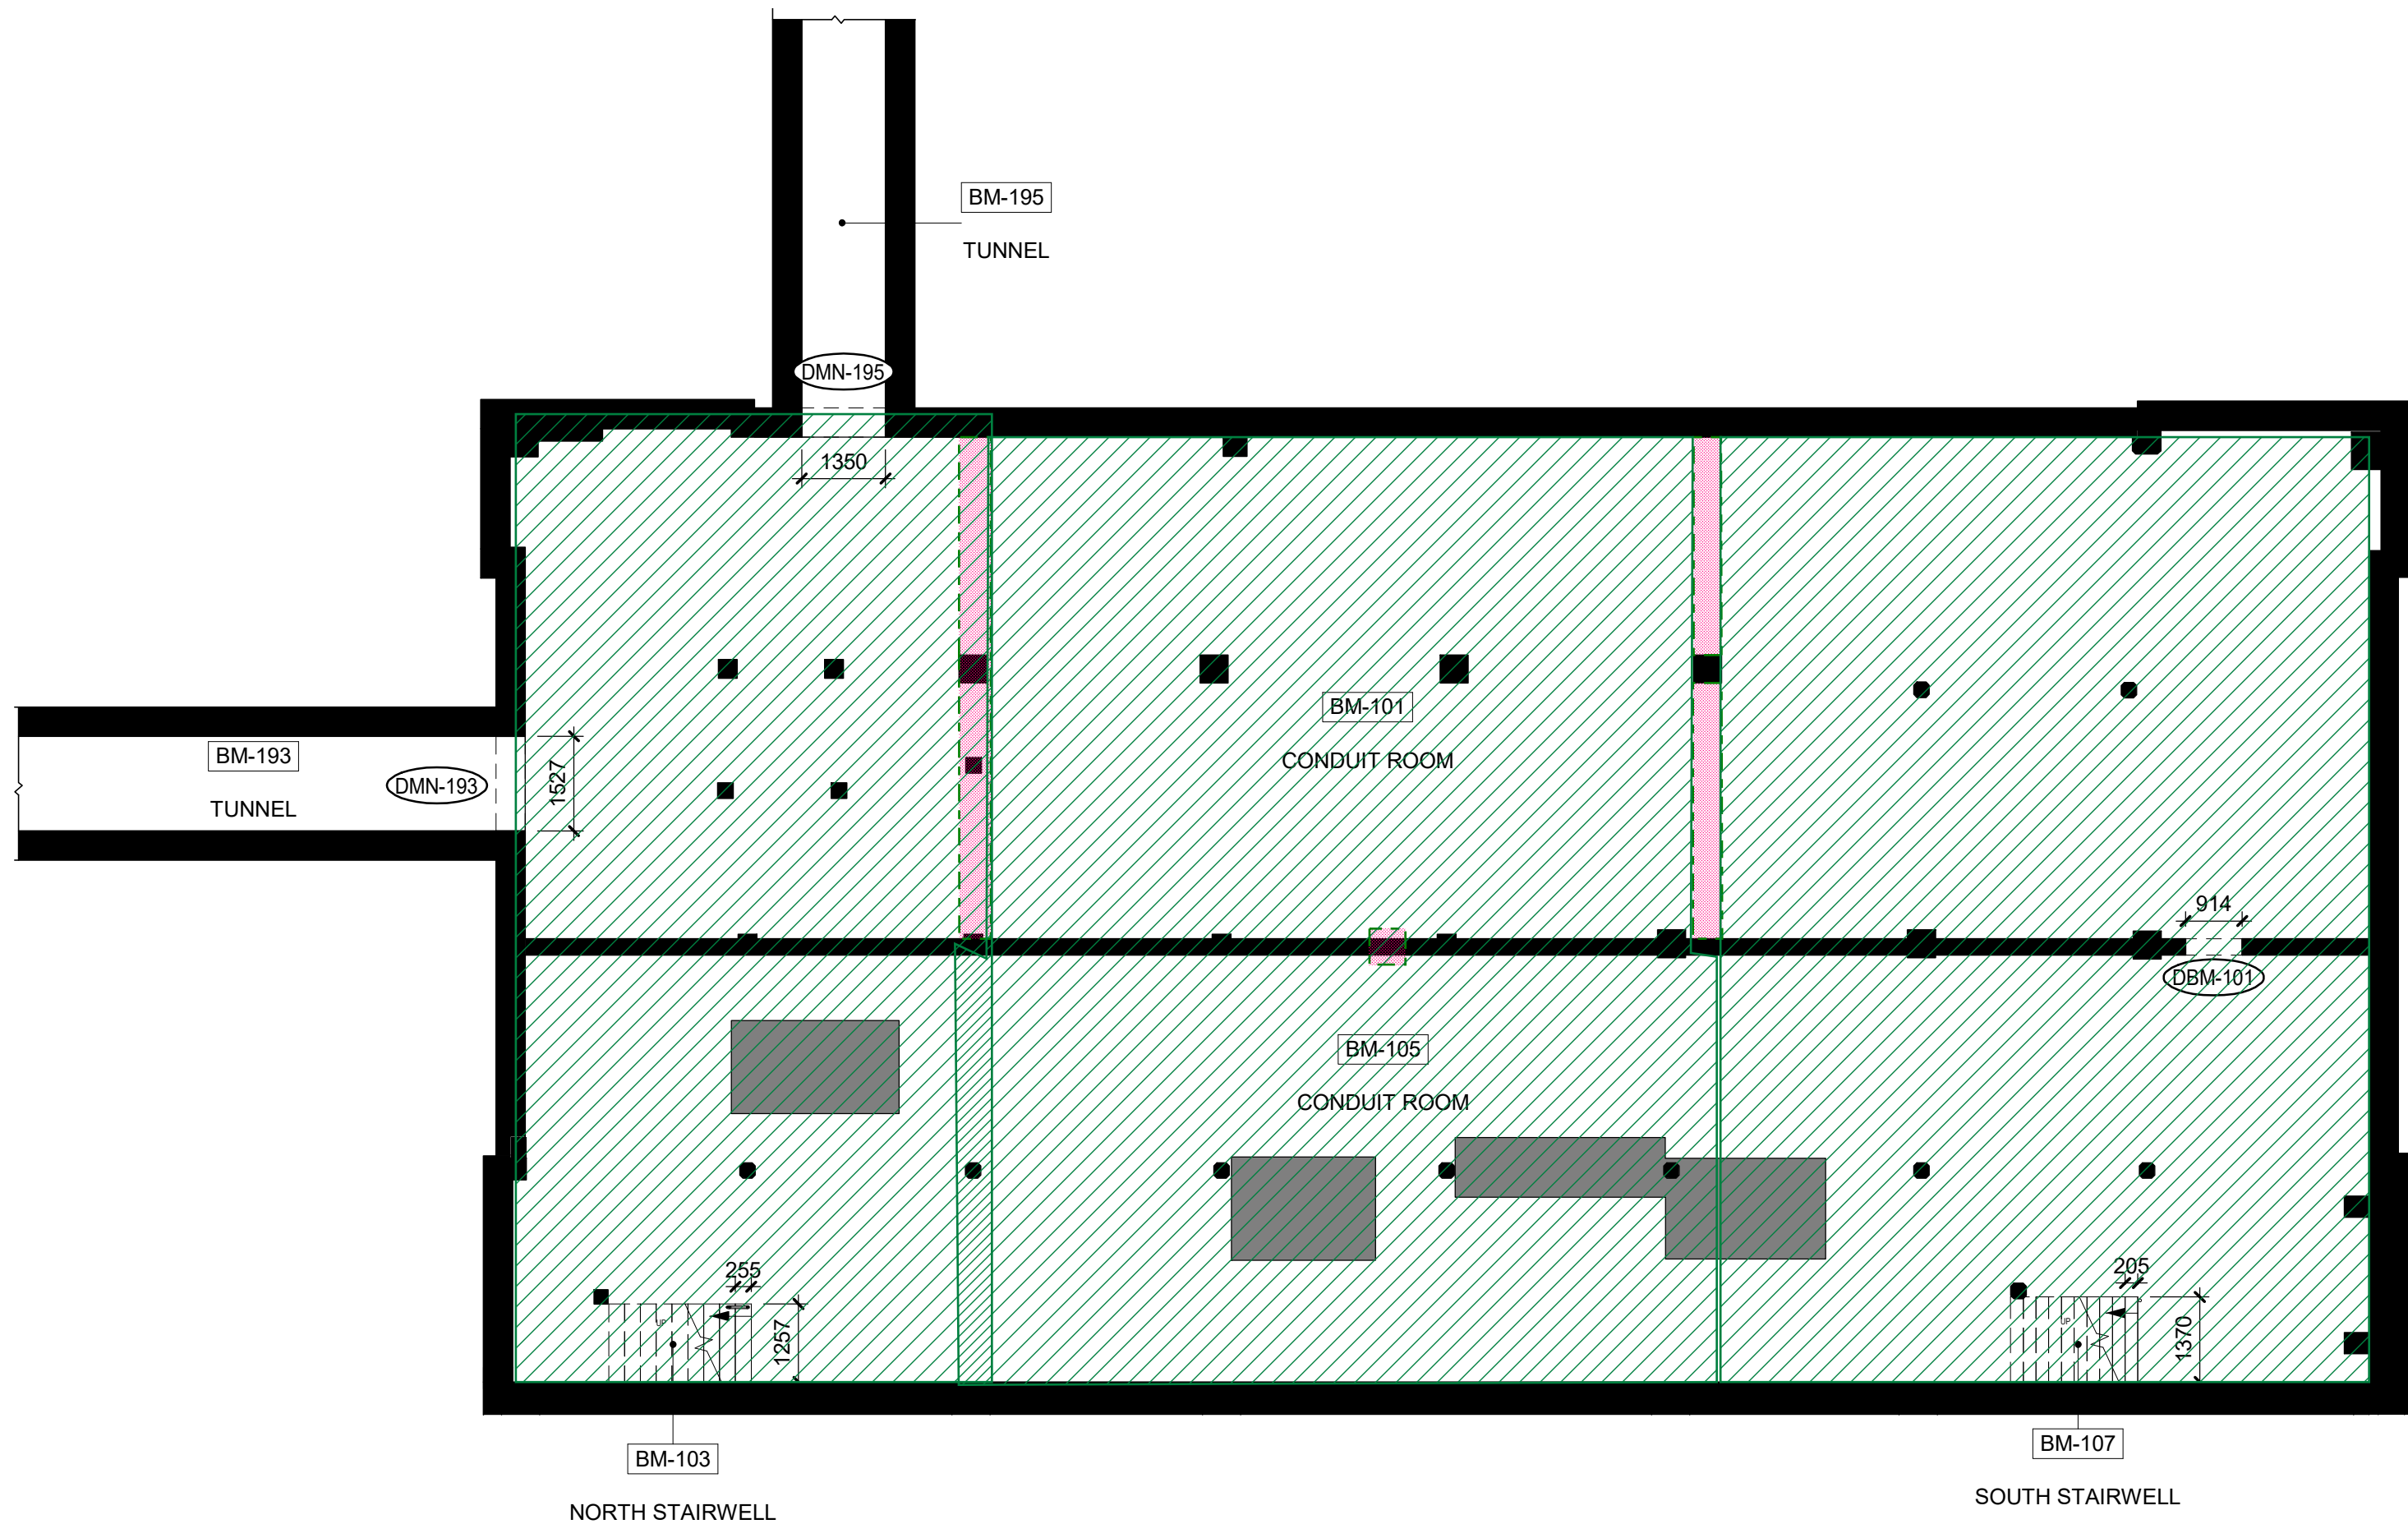


1 BM - SWITCH HOUSE
1 : 100

 0 1 2 5m

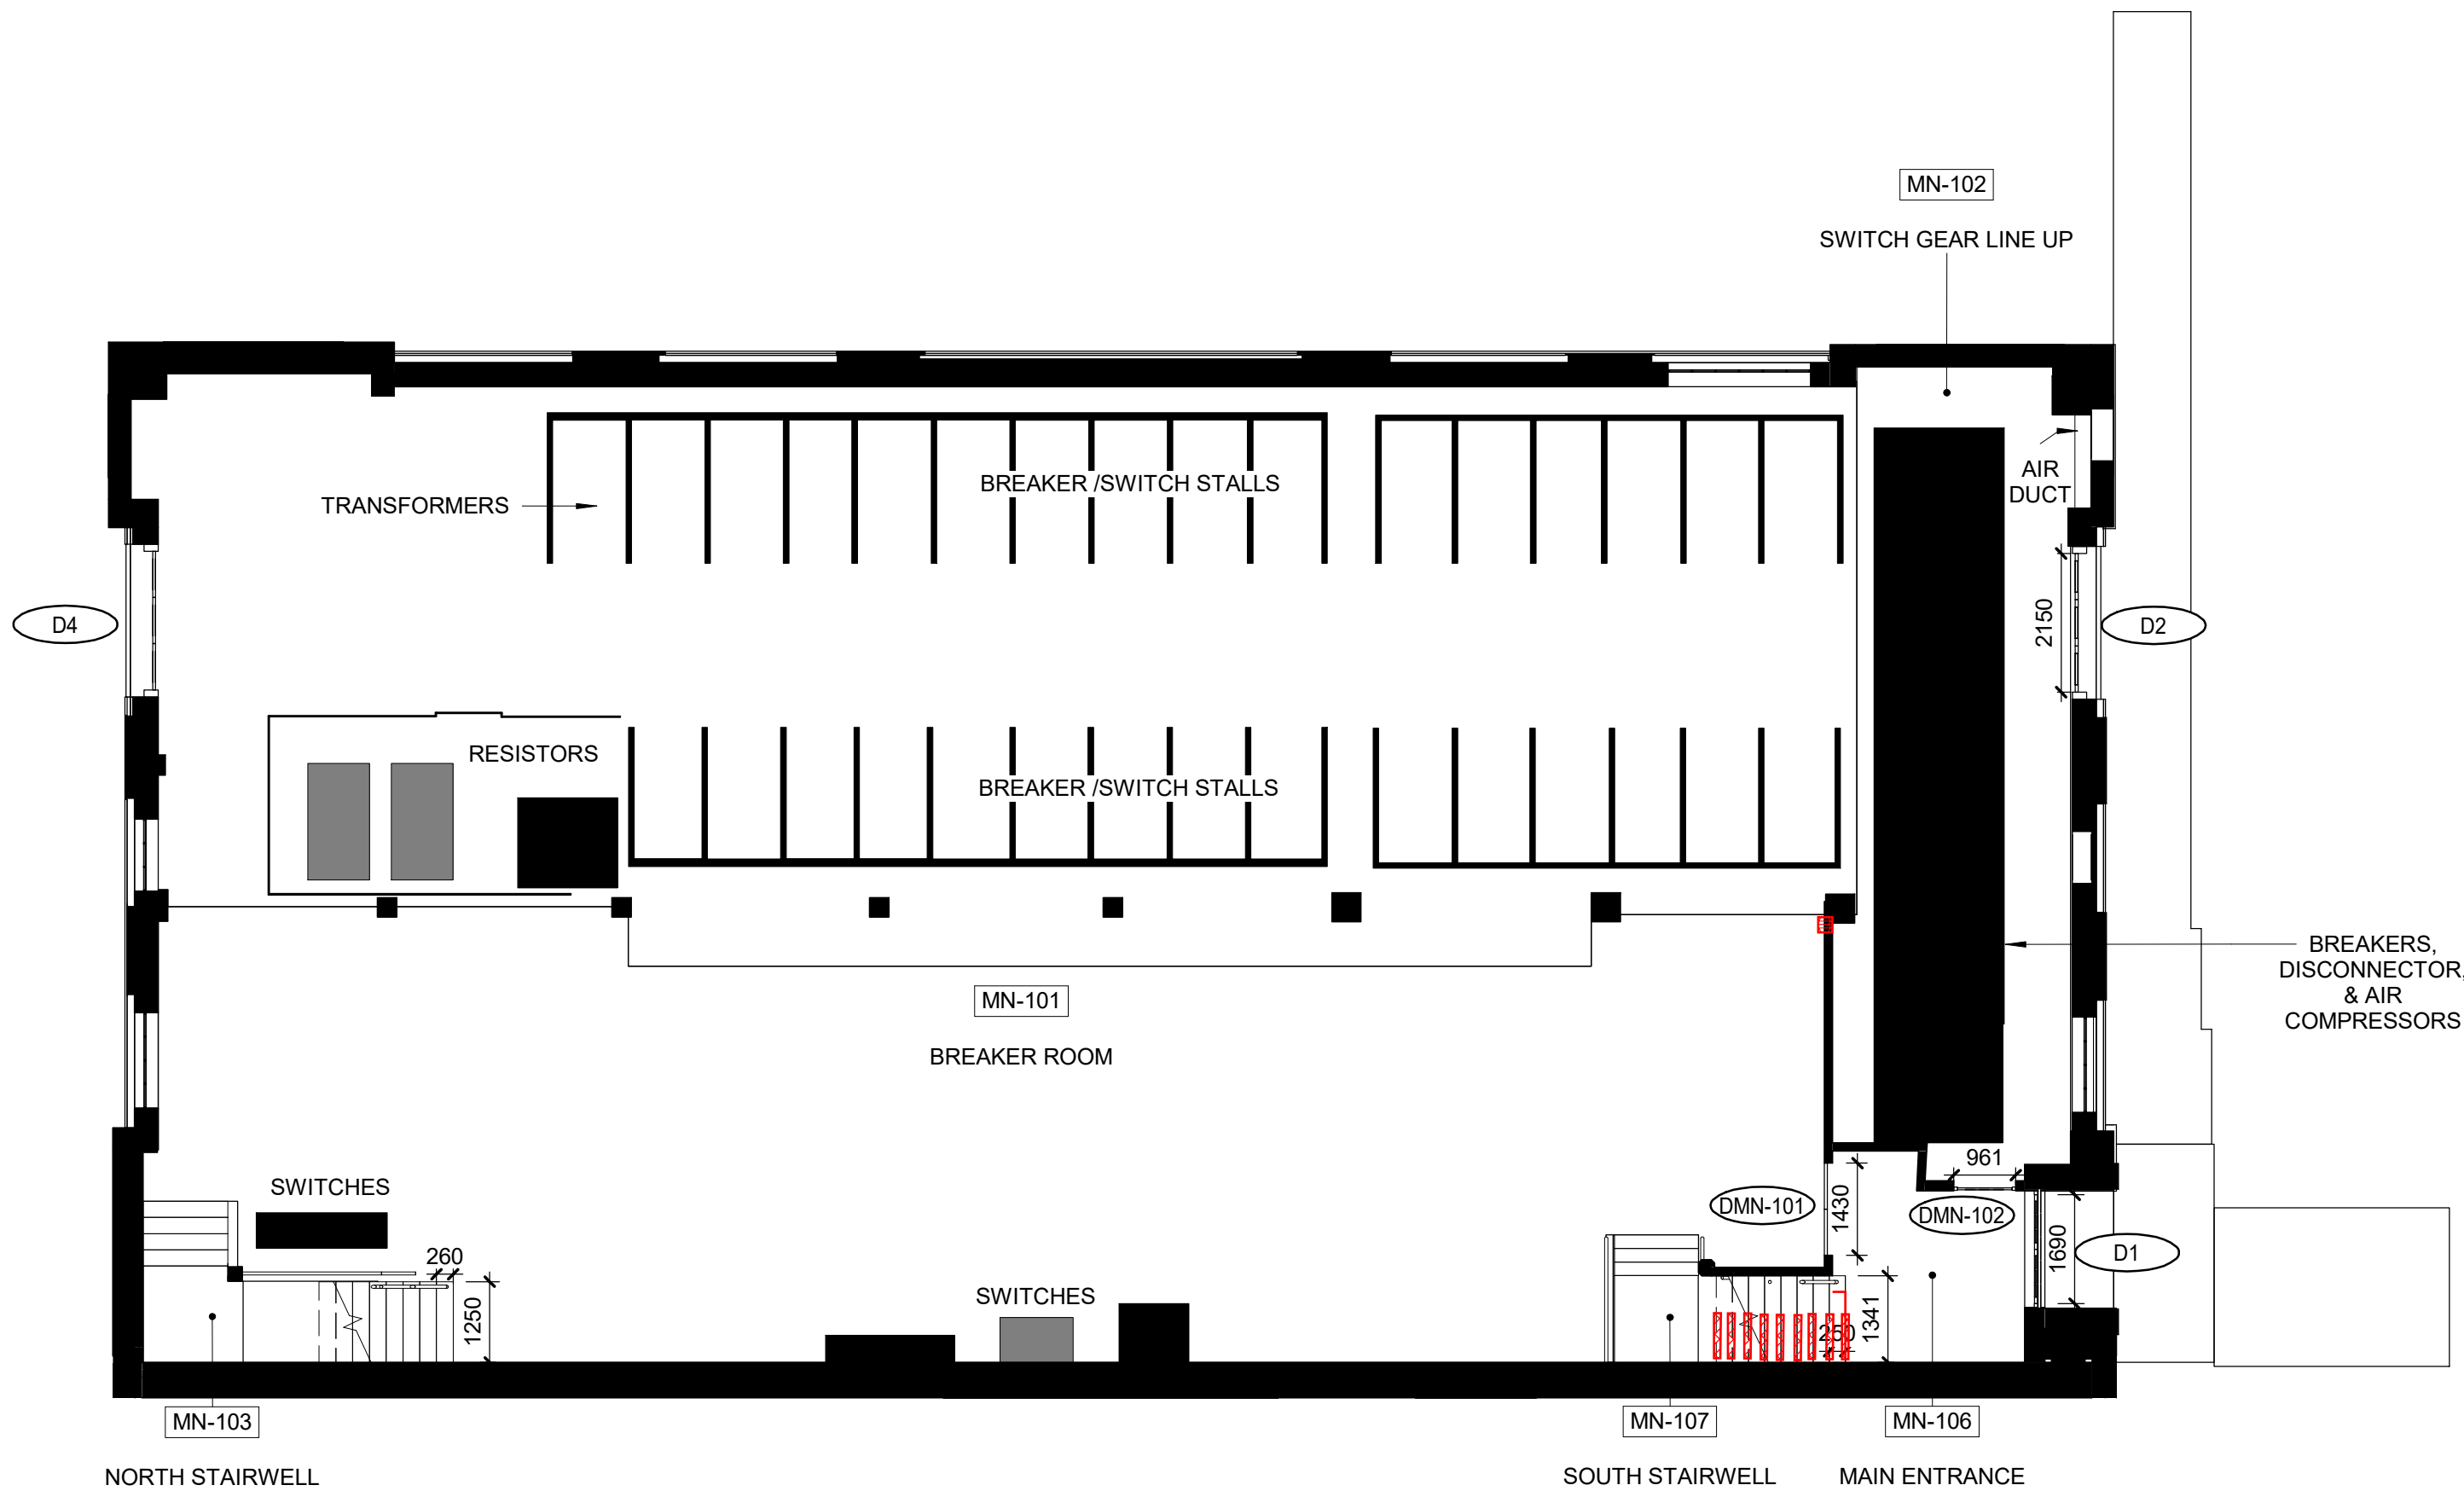

2 MN - SWITCH HOUSE
1 : 100

 0 1 2 5m



HATCH LEGEND

- CONCRETE
- METAL
- PLYWOOD
- OPEN TO BELOW
- MASKED REGION
- PROJECTING SURFACE
- CUT SURFACE

Consultant

PRIME CONSULTANT/ARCHITECTURAL
the marc boutin architectural collaborative inc.
205 9th Avenue SE, Suite 100
Calgary, AB, T2C 0R3
Contact: Richard Cotter

HERITAGE
DPS Inc. Architecture & Design
400 Boulevard de Maisonneuve O.
Montreal, QC H3A 1L4
Contact: Evan Oland

ARCHITECTURAL
Saucier + Perrotte Architectes
7043 Waverly St.
Montreal, QC H2S 3J1
Contact: Anne-Marie Saucier

STRUCTURAL/CIVIL/BUILDING ENVELOPE
Reed Jones Christofferson Ltd
17415 102 Ave NW #100,
Edmonton, AB T5S 1J6
Contact: Frank Cavaliere (S), John Balla (C),
Nick Trovati (RE)

MECHANICAL/ELECTRICAL
Williams Engineering Canada Inc.
10065 Jasper Ave #200,
Edmonton, AB T5J 3B1
Contact: Sheldon Samborsky (M), Ben Rajewski (E)

BUILDING/FIRE CODE
Jensen Hughes
5855 9 St SE #106,
Calgary, AB T2H 1Z9
Contact: Kyle Duckworth

COST
BTY Group
404 8 Ave SW #645,
Calgary, AB T2P 0R9
Contact: Michael Gabet

INDIGENITY
Nahayewit
1205 - 10903 103 Ave NW,
Edmonton, Alberta, T5K 2X6
Contact: Hunter Cardinal



CONSULTANT PROJECT 20008

Seal

Permit

PRELIMINARY NOT FOR CONSTRUCTION



ROSSDALE POWER PLANT
ADVANCED ASSESSMENT AND
PRIORITY REHABILITATION -
HISTORIC BUILDING RECORD

CP-9496

Department INTEGRATED INFRASTRUCTURE SERVICES

No.	Description	Date
1	BUILDING RECORD	2021-01-19
2	BUILDING RECORD	2021-01-27
3	BUILDING RECORD	2021-02-09
4	BUILDING RECORD	2021-02-19
5	CONDIONS ASSESSMENT	2021-03-06
6	CONDIONS ASSESSMENT	2021-03-07
7	BUILDING RECORD	2021-03-12
8	BUILDING RECORD	2021-04-23

Location ID ROS 105, ROS106, ROS107

Description LOW PRESSURE PLANT -
CONDITIONS ASSESSMENT

Drawing Title ROS105 SWITCH HOUSE BM & MN
PLANS

Discipline	HERITAGE	Drawn	BD
Volume		Drawing	
Sheet	H251	Number	
File			

Conditions Legend

Finish Deterioration

Flooring Missing Unit/Section


Metal Deterioration

Corrosion

Masonry Deterioration


Terrazzo Spall

The Conditions Legend is specific to the subject building of each report and conditions drawing set

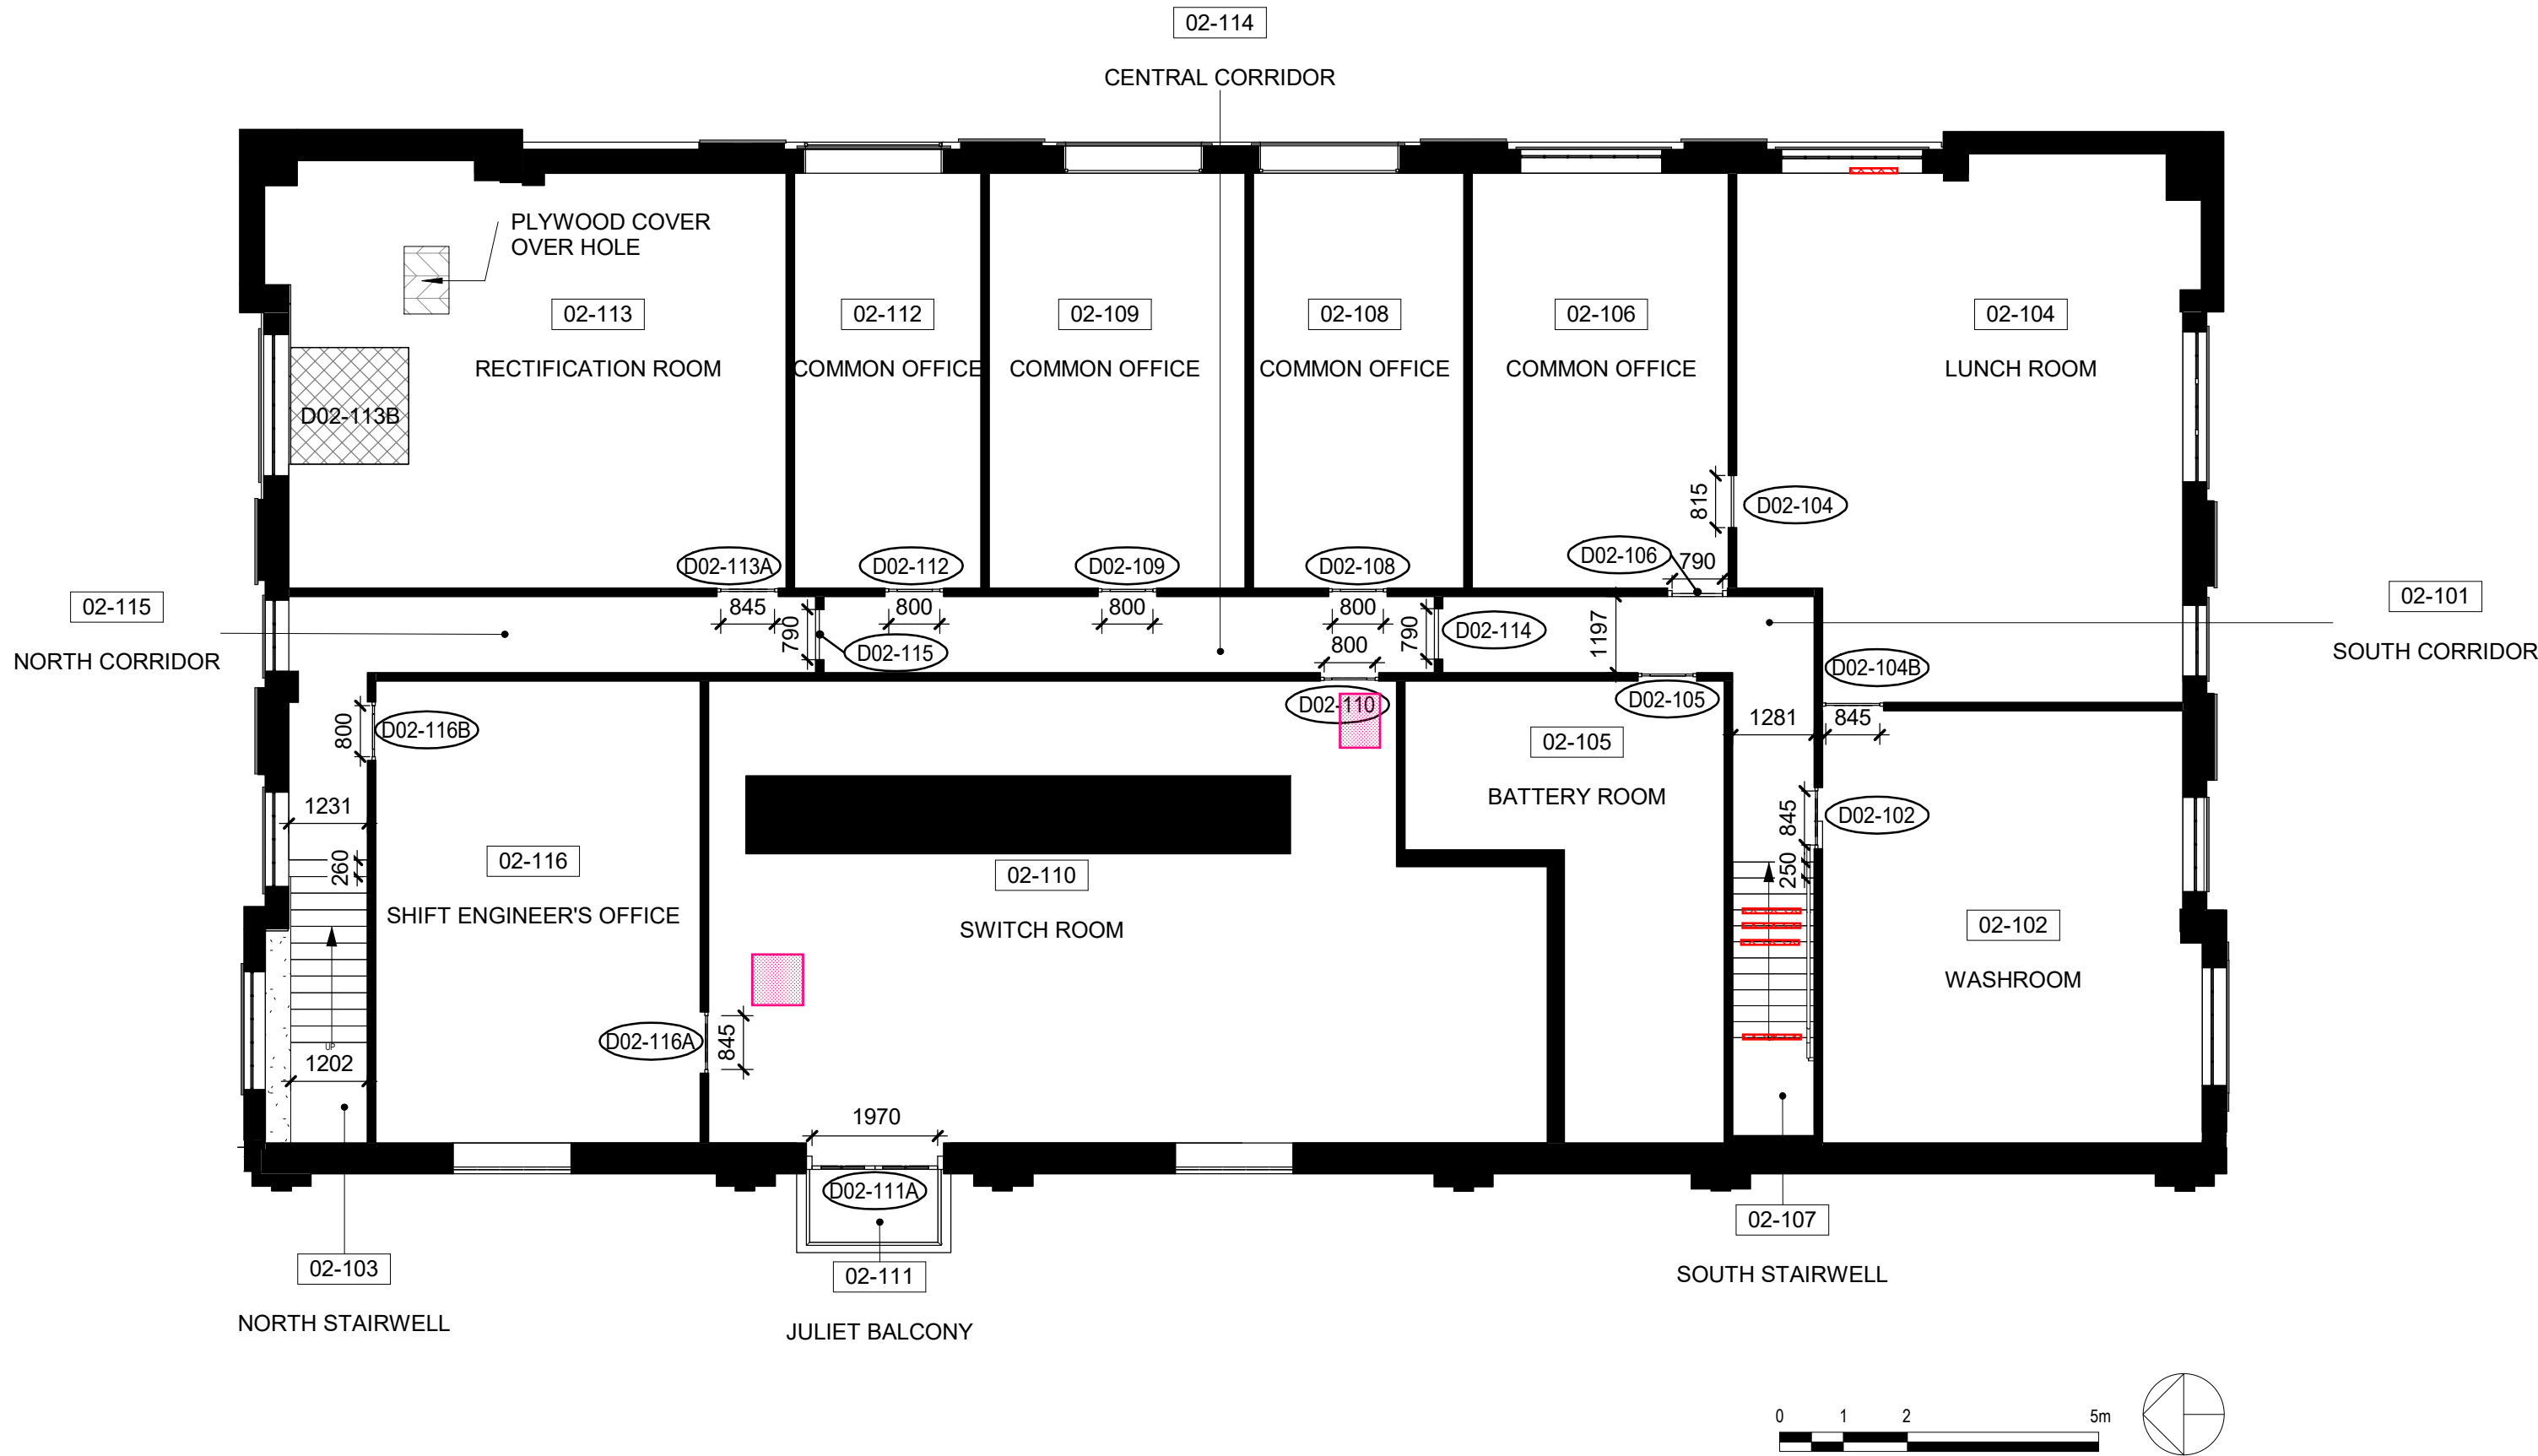

1 02 - SWITCH HOUSE

1 : 100

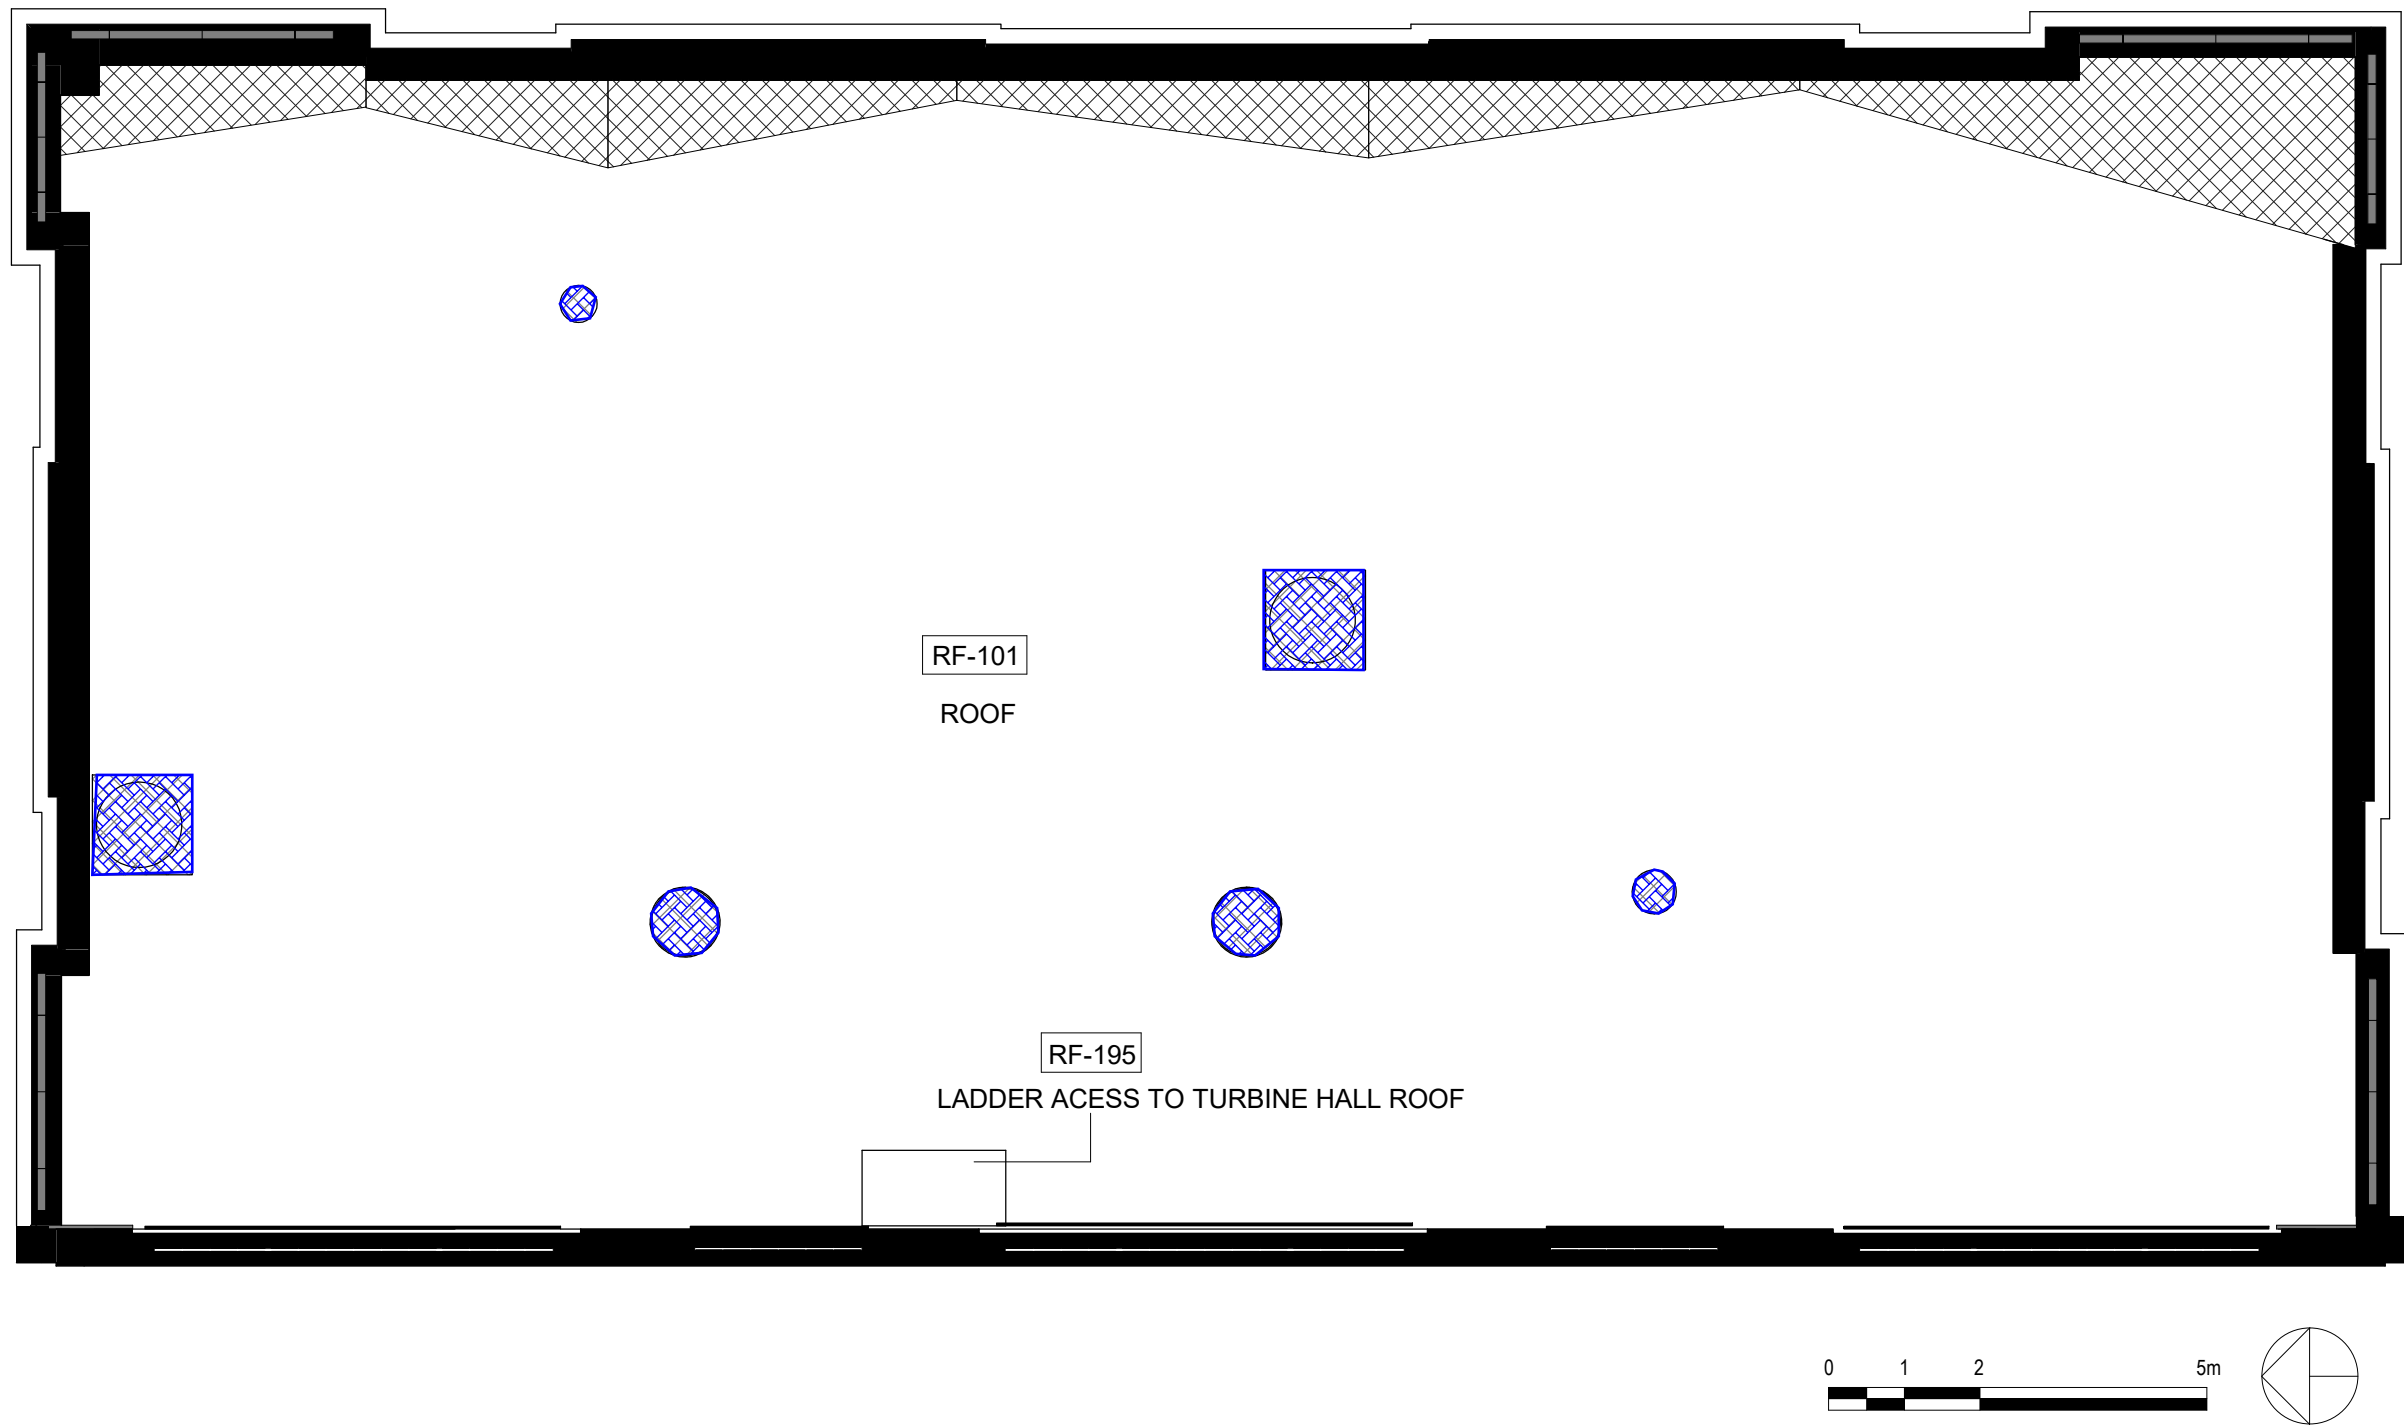

2 RF - SWITCH HOUSE

1 : 100

HATCH LEGEND

- CONCRETE
- METAL
- PLYWOOD
- OPEN TO BELOW
- MASKED REGION
- PROJECTING SURFACE
- CUT SURFACE

Consultant

PRIME CONSULTANT/ARCHITECTURAL

the marc boutin architectural collaborative inc.

205 9th Avenue SE, Suite 100

Calgary, AB, T2C 0R3

Contact: Richard Cotter

MECHANICAL/ELECTRICAL

Williams Engineering Canada Inc.

10065 Jasper Ave #200,

Edmonton, AB T5J 3B1

Contact: Sheldon Samborsky (M), Ben Rajewski (E)

HERITAGE

DPS Inc. Architecture & Design

400 Boulevard de Maisonneuve O,

Montreal, QC H3A 1L4

Contact: Evan Ostend

ARCHITECTURAL

Saucier + Perrotte Architectes

7043 Waverly St,

Montreal, QC H2S 3J1

Contact: Anne-Marie Saucier

STRUCTURAL/CIVIL/BUILDING ENVELOPE

Reed Jones Christofferson Ltd

17415 102 Ave NW #100,

Edmonton, AB T5S 1J6

Contact: Frank Cavaliere (S), John Balla (C), Nick Trovati (RE)

BUILDING/FIRE CODE

Jensen Hughes

5855 9 St SE #106,

Calgary, AB T2H 1Z9

Contact: Kyle Duckworth

COST

BTY Group

404 8 Ave SW #645,

Calgary, AB T2P 0R9

Contact: Michael Giesert

INDIGENITY

Nahayewin

1205 - 10903 103 Ave NW,

Edmonton, Alberta, T5K 2X6

Contact: Hunter Cardinal

MBAC

DFS

CONSULTANT PROJECT 20008

Seal	Permit
	PRELIMINARY NOT FOR CONSTRUCTION

Edmonton

ROSSDALE POWER PLANT
ADVANCED ASSESSMENT AND
PRIORITY REHABILITATION -
HISTORIC BUILDING RECORD

CP-9496

Department INTEGRATED INFRASTRUCTURE SERVICES

No.	Description	Date
1	BUILDING RECORD	2021-01-19
2	BUILDING RECORD	2021-01-27
3	BUILDING RECORD	2021-02-09
4	BUILDING RECORD	2021-02-19
5	CONDITONS ASSESSMENT	2021-03-06
6	CONDITONS ASSESSMENT	2021-03-07
7	BUILDING RECORD	2021-03-12
8	BUILDING RECORD	2021-04-23

Location ID ROS 105, ROS106, ROS107

Description LOW PRESSURE PLANT -
CONDITIONS ASSESSMENT

Drawing Title ROS105 SWITCH HOUSE 02 & RF
PLANS

Discipline	HERITAGE	Drawn	BD
Volume		Drawing	
Sheet	H252	Number	
File			

Conditions Legend

Masonry Deterioration

Bituminous Stain

Falling Mortar

Plywood Cover

Poorly In-Filled Patch

Relict Fixtures

Concrete Deterioration

Crack

Exposed Rebar

Relict Fixtures

Spall

Metal Deterioration

Corrosion

Window Deterioration

Broken Unit

Wood Deterioration


Paint Failure

The Conditions Legend is specific to the subject building of each report and conditions drawing set

1

SOUTH ELEVATION SWITCH HOUSE

1 : 100

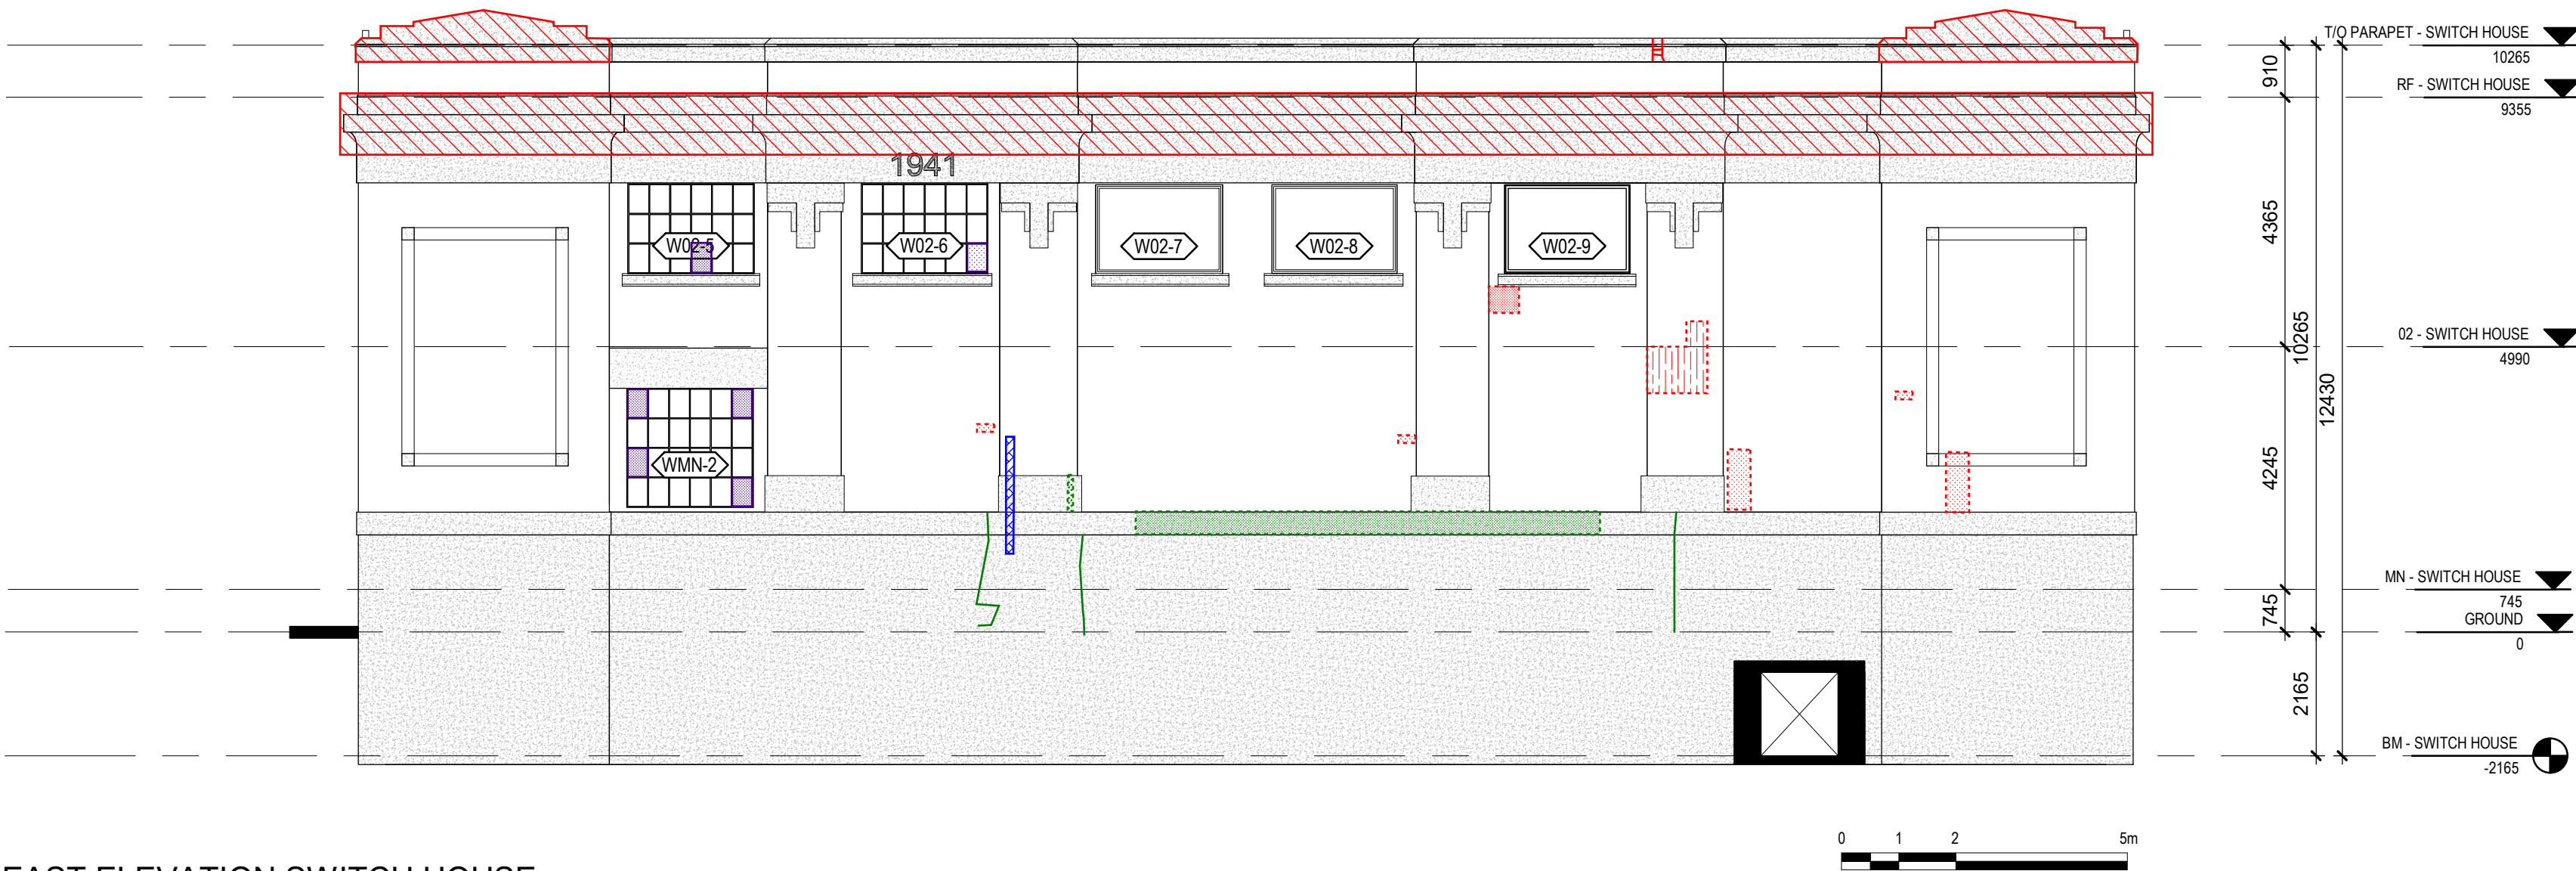

2

EAST ELEVATION SWITCH HOUSE

1 : 100



3

NORTH ELEVATION SWITCH HOUSE

1 : 100

DRAWING NOTES

ALL WALL ASSEMBLIES ARE BRICK UNLESS DRAFTED WITH CONCRETE HATCH.

HATCH LEGEND

- CONCRETE
- METAL
- PLYWOOD
- OPEN TO BELOW
- MASKED REGION
- PROJECTING SURFACE
- CUT SURFACE

Consultant

PRIME CONSULTANT/ARCHITECTURAL
the marc boutin architectural collaborative inc.
205 9th Avenue SE, Suite 100
Calgary, AB, T2C 0R3
Contact: Richard Coder

HERITAGE
DFS Inc. Architecture & Design
400 Boulevard de Maisonneuve O,
Montreal, QC H3A 1L4
Contact: Evan Ostlund

ARCHITECTURAL
Saucier + Perrotte Architectes
7043 Waverly St.
Montreal, QC H2S 3J1
Contact: Anne-Marie Saucier

STRUCTURAL/CIVIL/BUILDING ENVELOPE
Reed Jones Christofferson LLP
17415 102 Ave NW #100,
Edmonton, AB T5S 1J6
Contact: Frank Cavaliere (S), John Balla (C),
Nick Trovati (RE)

MECHANICAL/ELECTRICAL
Williams Engineering Canada Inc.
10605 Jasper Ave #200,
Edmonton, AB T5J 3B1
Contact: Sheldon Samborsky (M), Ben Rajewski (E)

BUILDING/FIRE CODE
Jensen Hughes
5855 9 St SE #106,
Calgary, AB T2H 1Z9
Contact: Kyle Duckworth

COST
BTY Group
404 8 Ave SW #645,
Calgary, AB T2P 0R9
Contact: Michael Gabelt

INDIGENITY
Nahayewin
1205 - 10903 103 Ave NW,
Edmonton, Alberta, T5K 2X6
Contact: Hunter Cardinal

CONSULTANT PROJECT 20008

Seal

Permit

PRELIMINARY NOT FOR CONSTRUCTION

Edmonton

ROSSDALE POWER PLANT
ADVANCED ASSESSMENT AND
PRIORITY REHABILITATION -
HISTORIC BUILDING RECORD

CP-9496

Department INTEGRATED INFRASTRUCTURE SERVICES

No.	Description	Date
1	BUILDING RECORD	2021-01-19
2	BUILDING RECORD	2021-01-27
3	BUILDING RECORD	2021-02-09
4	BUILDING RECORD	2021-02-19
5	CONDITONS ASSESSMENT	2021-03-06
6	CONDITONS ASSESSMENT	2021-03-07
7	BUILDING RECORD	2021-03-12
8	BUILDING RECORD	2021-04-23

Location ID ROS 105, ROS106, ROS107
Description LOW PRESSURE PLANT -
CONDITIONS ASSESSMENT

Drawing Title ROS105 SWITCH HOUSE
EXTERIOR ELEVATIONS

Discipline	HERITAGE	Drawn	BD
Volume		Drawing	
Sheet	H351	Number	
File			

Conditions Legend


Concrete Deterioration

- Missing Section


Masonry Deterioration

- Historic Graffiti

The Conditions Legend is specific to the subject building of each report and conditions drawing set.

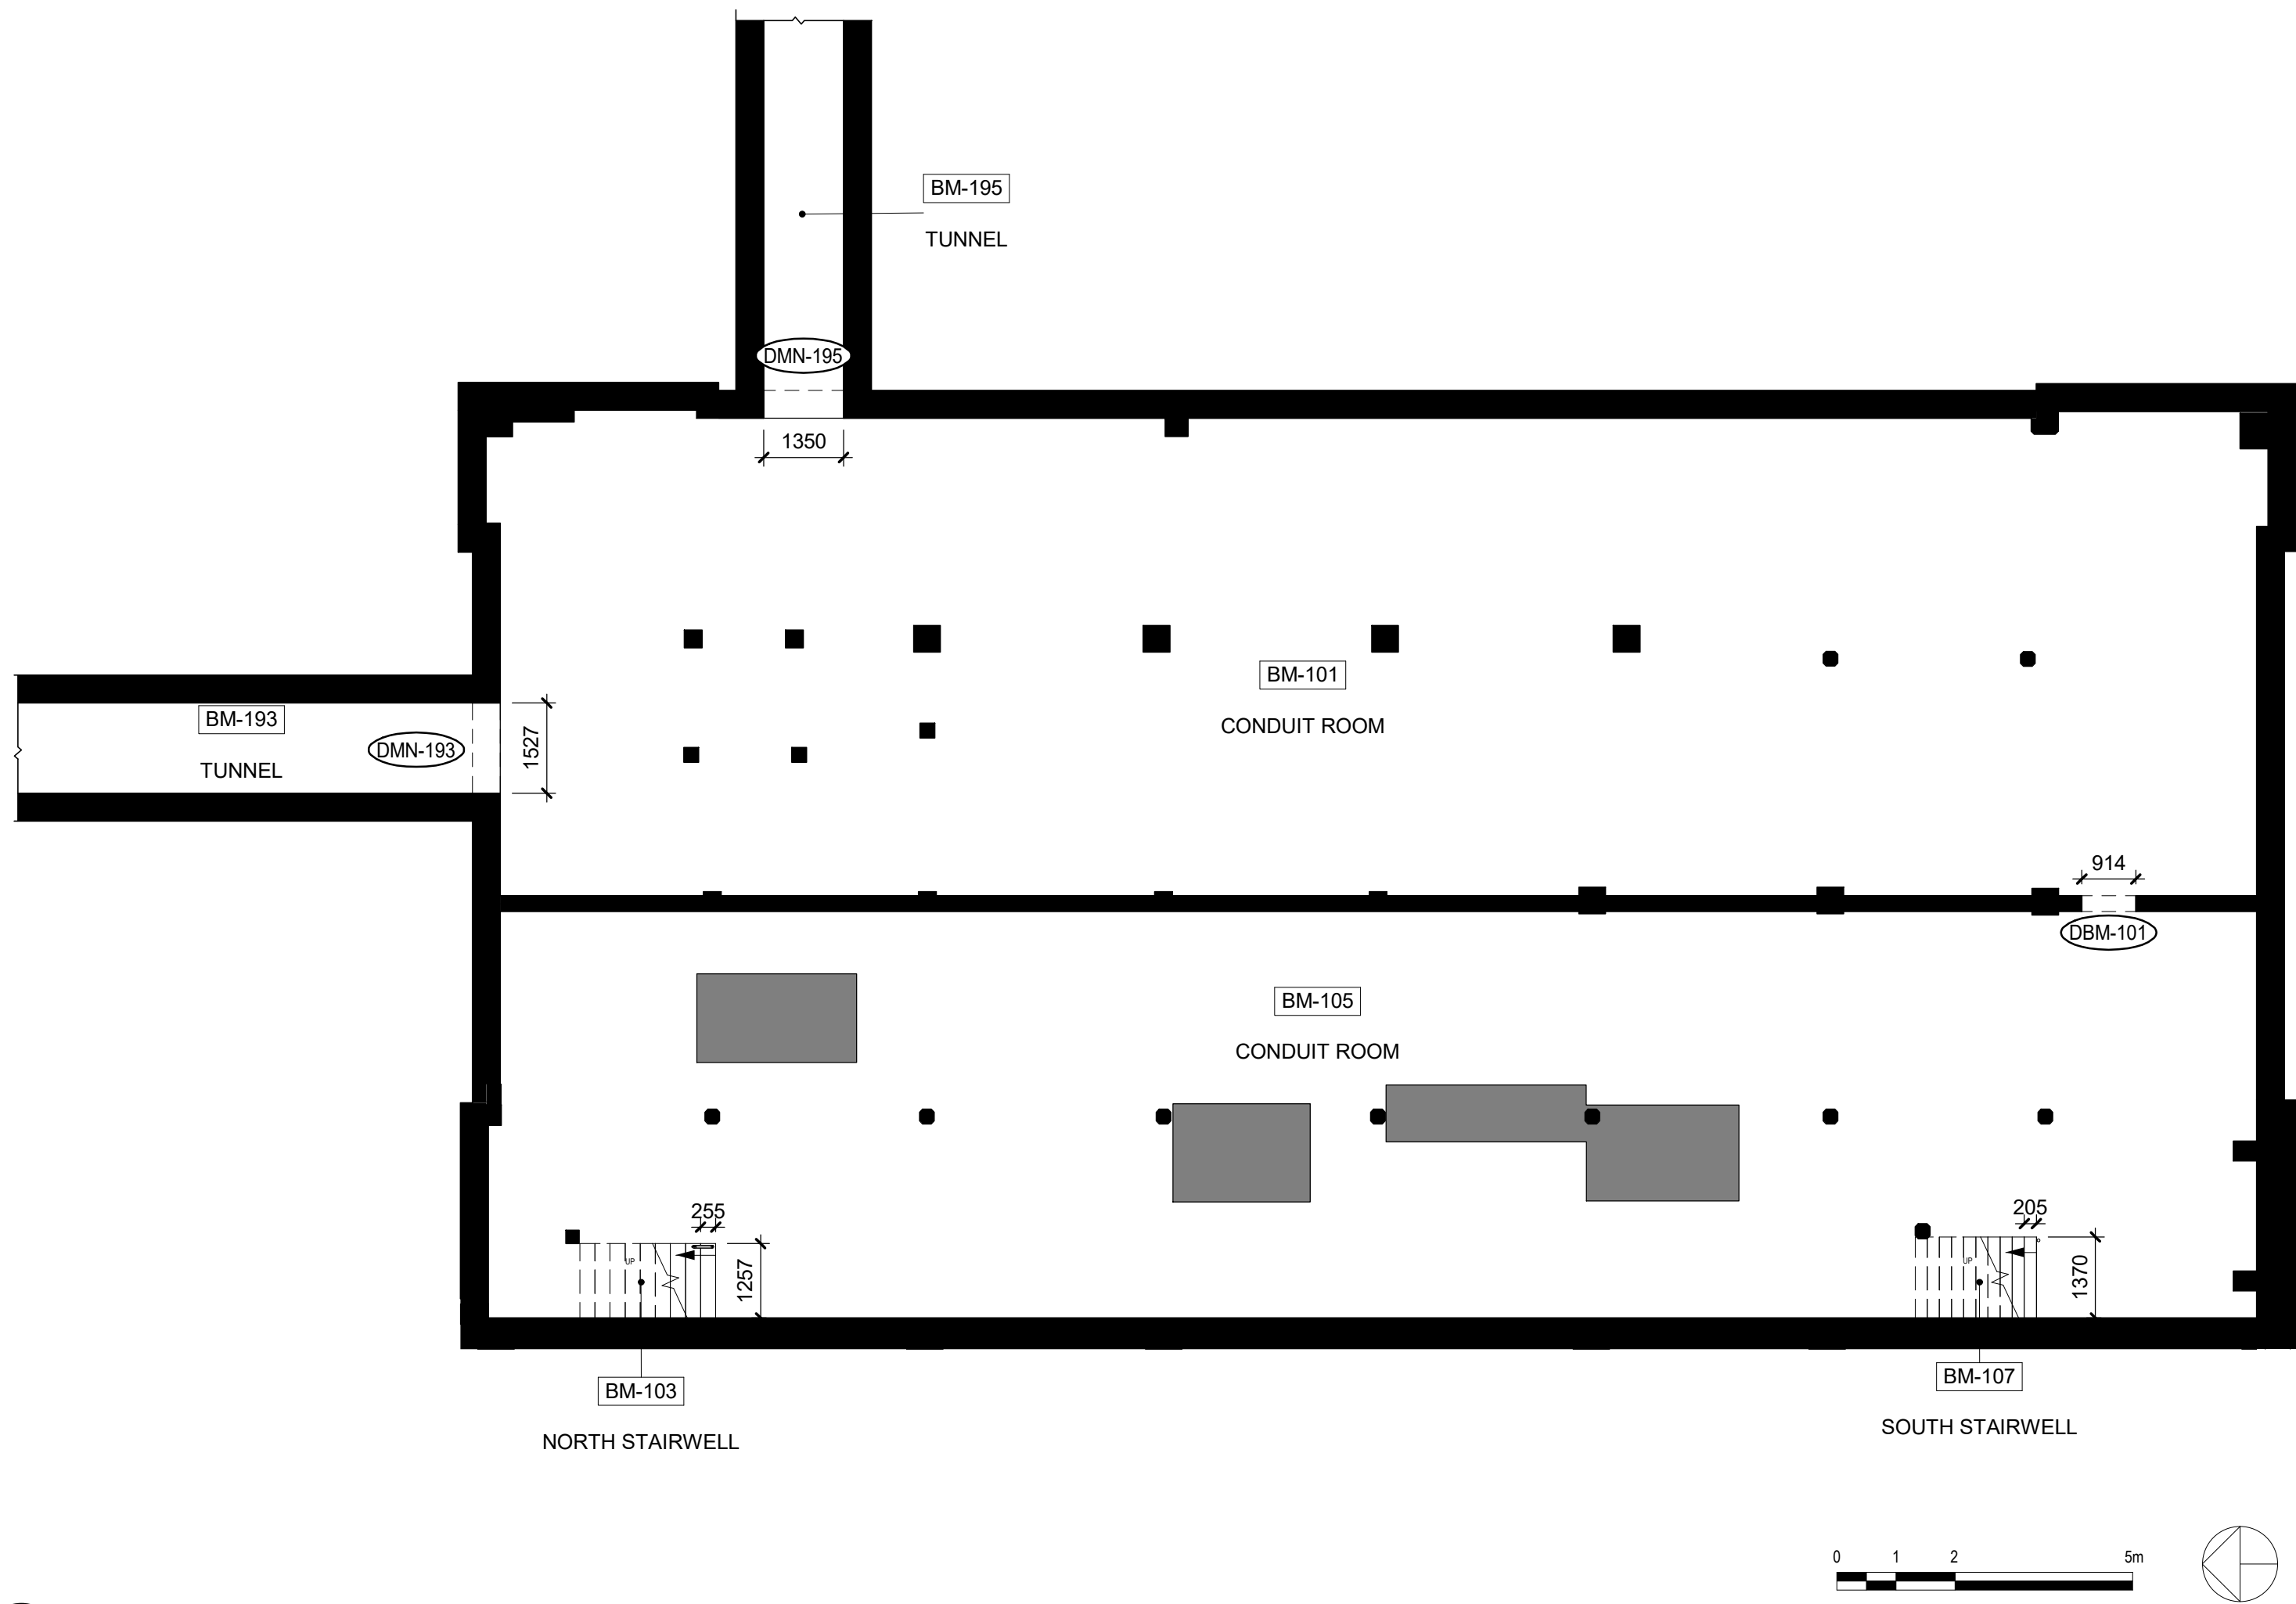

1 BM - SWITCH HOUSE REFLECTED CEILING PLAN
1 : 100

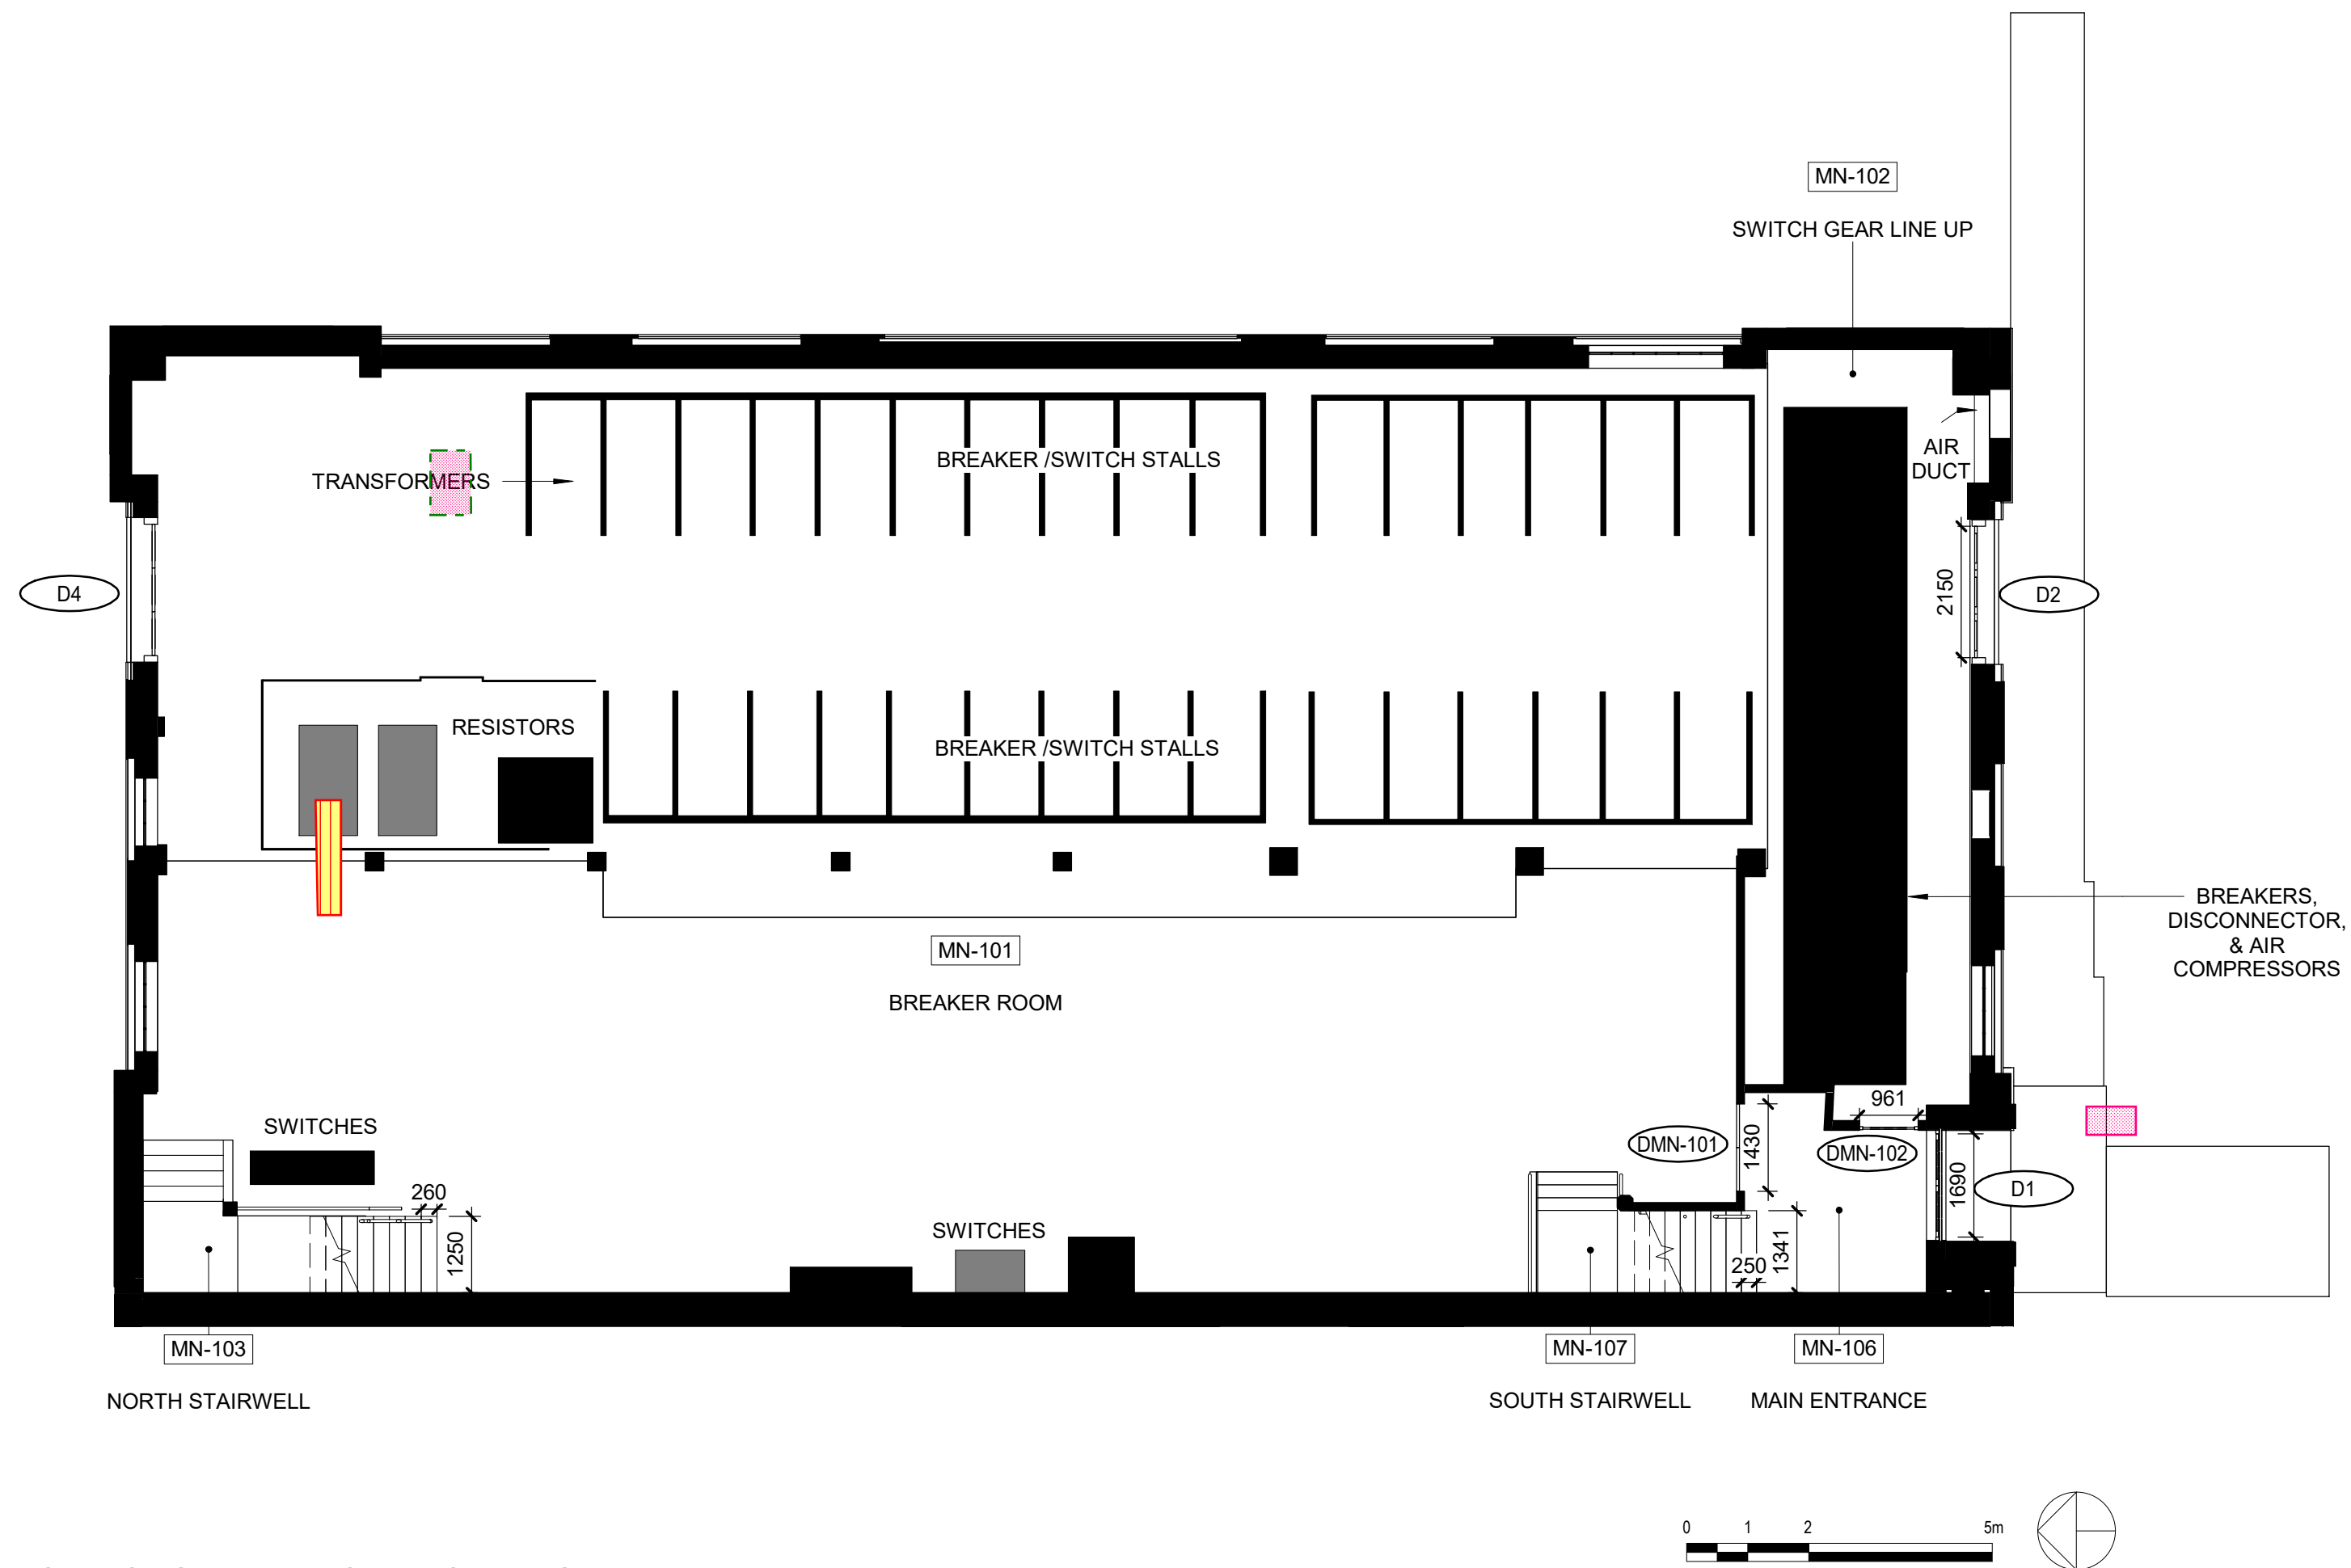

2 MN - SWITCH HOUSE REFLECTED CEILING PLAN
1 : 100

HATCH LEGEND

- CONCRETE
- METAL
- PLYWOOD
- OPEN TO BELOW
- MASKED REGION
- PROJECTING SURFACE
- CUT SURFACE

Consultant

PRIME CONSULTANT/ARCHITECTURAL
the marc boutin architectural collaborative inc.
205 9th Avenue SE, Suite 100
Calgary, AB, T2C 0R3
Contact: Richard Collier

MECHANICAL/ELECTRICAL
Williams Engineering Canada Inc.
10085 Jasper Ave #200,
Edmonton, AB T5J 3B1
Contact: Sheldon Samborsky (M), Ben Rajewski (E)

HERITAGE
DPS Inc. Architecture & Design
400 Boulevard de Maisonneuve O,
Montreal, QC H3A 1L4
Contact: Evan Ostend

ARCHITECTURAL
Saucier + Perrotte Architectes
7043 Waverly St.
Montreal, QC H2S 3J1
Contact: Anne-Marie Saucier

STRUCTURAL/CIVIL/BUILDING ENVELOPE
Reed Jones Christofferson Ltd
17415 102 Ave NW #100,
Edmonton, AB T5S 1J6
Contact: Frank Cavalliere (S), John Balla (C),
Nick Trovati (RE)

BUILDING/FIRE CODE
Jensen Hughes
5855 9 St SE #106,
Calgary, AB T2H 1Z9
Contact: Nyle Duckworth

COST
BTY Group
404 8 Ave SW #645,
Calgary, AB T2P 0R9
Contact: Michael Gabet

INDIGENITY
Nahayewin
1205 - 10903 103 Ave NW,
Edmonton, Alberta, T5K 2K6
Contact: Hunter Cardinal

CONSULTANT PROJECT 20008

Seal Permit

PRELIMINARY NOT FOR CONSTRUCTION

Edmonton

ROSSDALE POWER PLANT
ADVANCED ASSESSMENT AND
PRIORITY REHABILITATION -
HISTORIC BUILDING RECORD

CP-9496

Department INTEGRATED INFRASTRUCTURE SERVICES

No.	Description	Date
1	CONDITIONS ASSESSMENT	2021-03-06
2	CONDITIONS ASSESSMENT	2021-03-07
3	BUILDING RECORD	2021-04-23

Location ID ROS 105, ROS106, ROS107

Description LOW PRESSURE PLANT -
CONDITIONS ASSESSMENT

Drawing Title ROS105 SWITCH HOUSE BM & MN
REFLECTED CEILING PLANS

Discipline	HERITAGE	Drawn	BD
Volume		Drawing	
Sheet	H550	Number	
File			


Conditions Legend

Finish Deterioration
Vent Related Plaster
Failure

The Conditions Legend is
specific to the subject
building of each report and
conditions drawing set

HATCH LEGEND

- CONCRETE
METAL
PLYWOOD
OPEN TO BELOW
MASKED REGION
PROJECTING SURFACE
CUT SURFACE

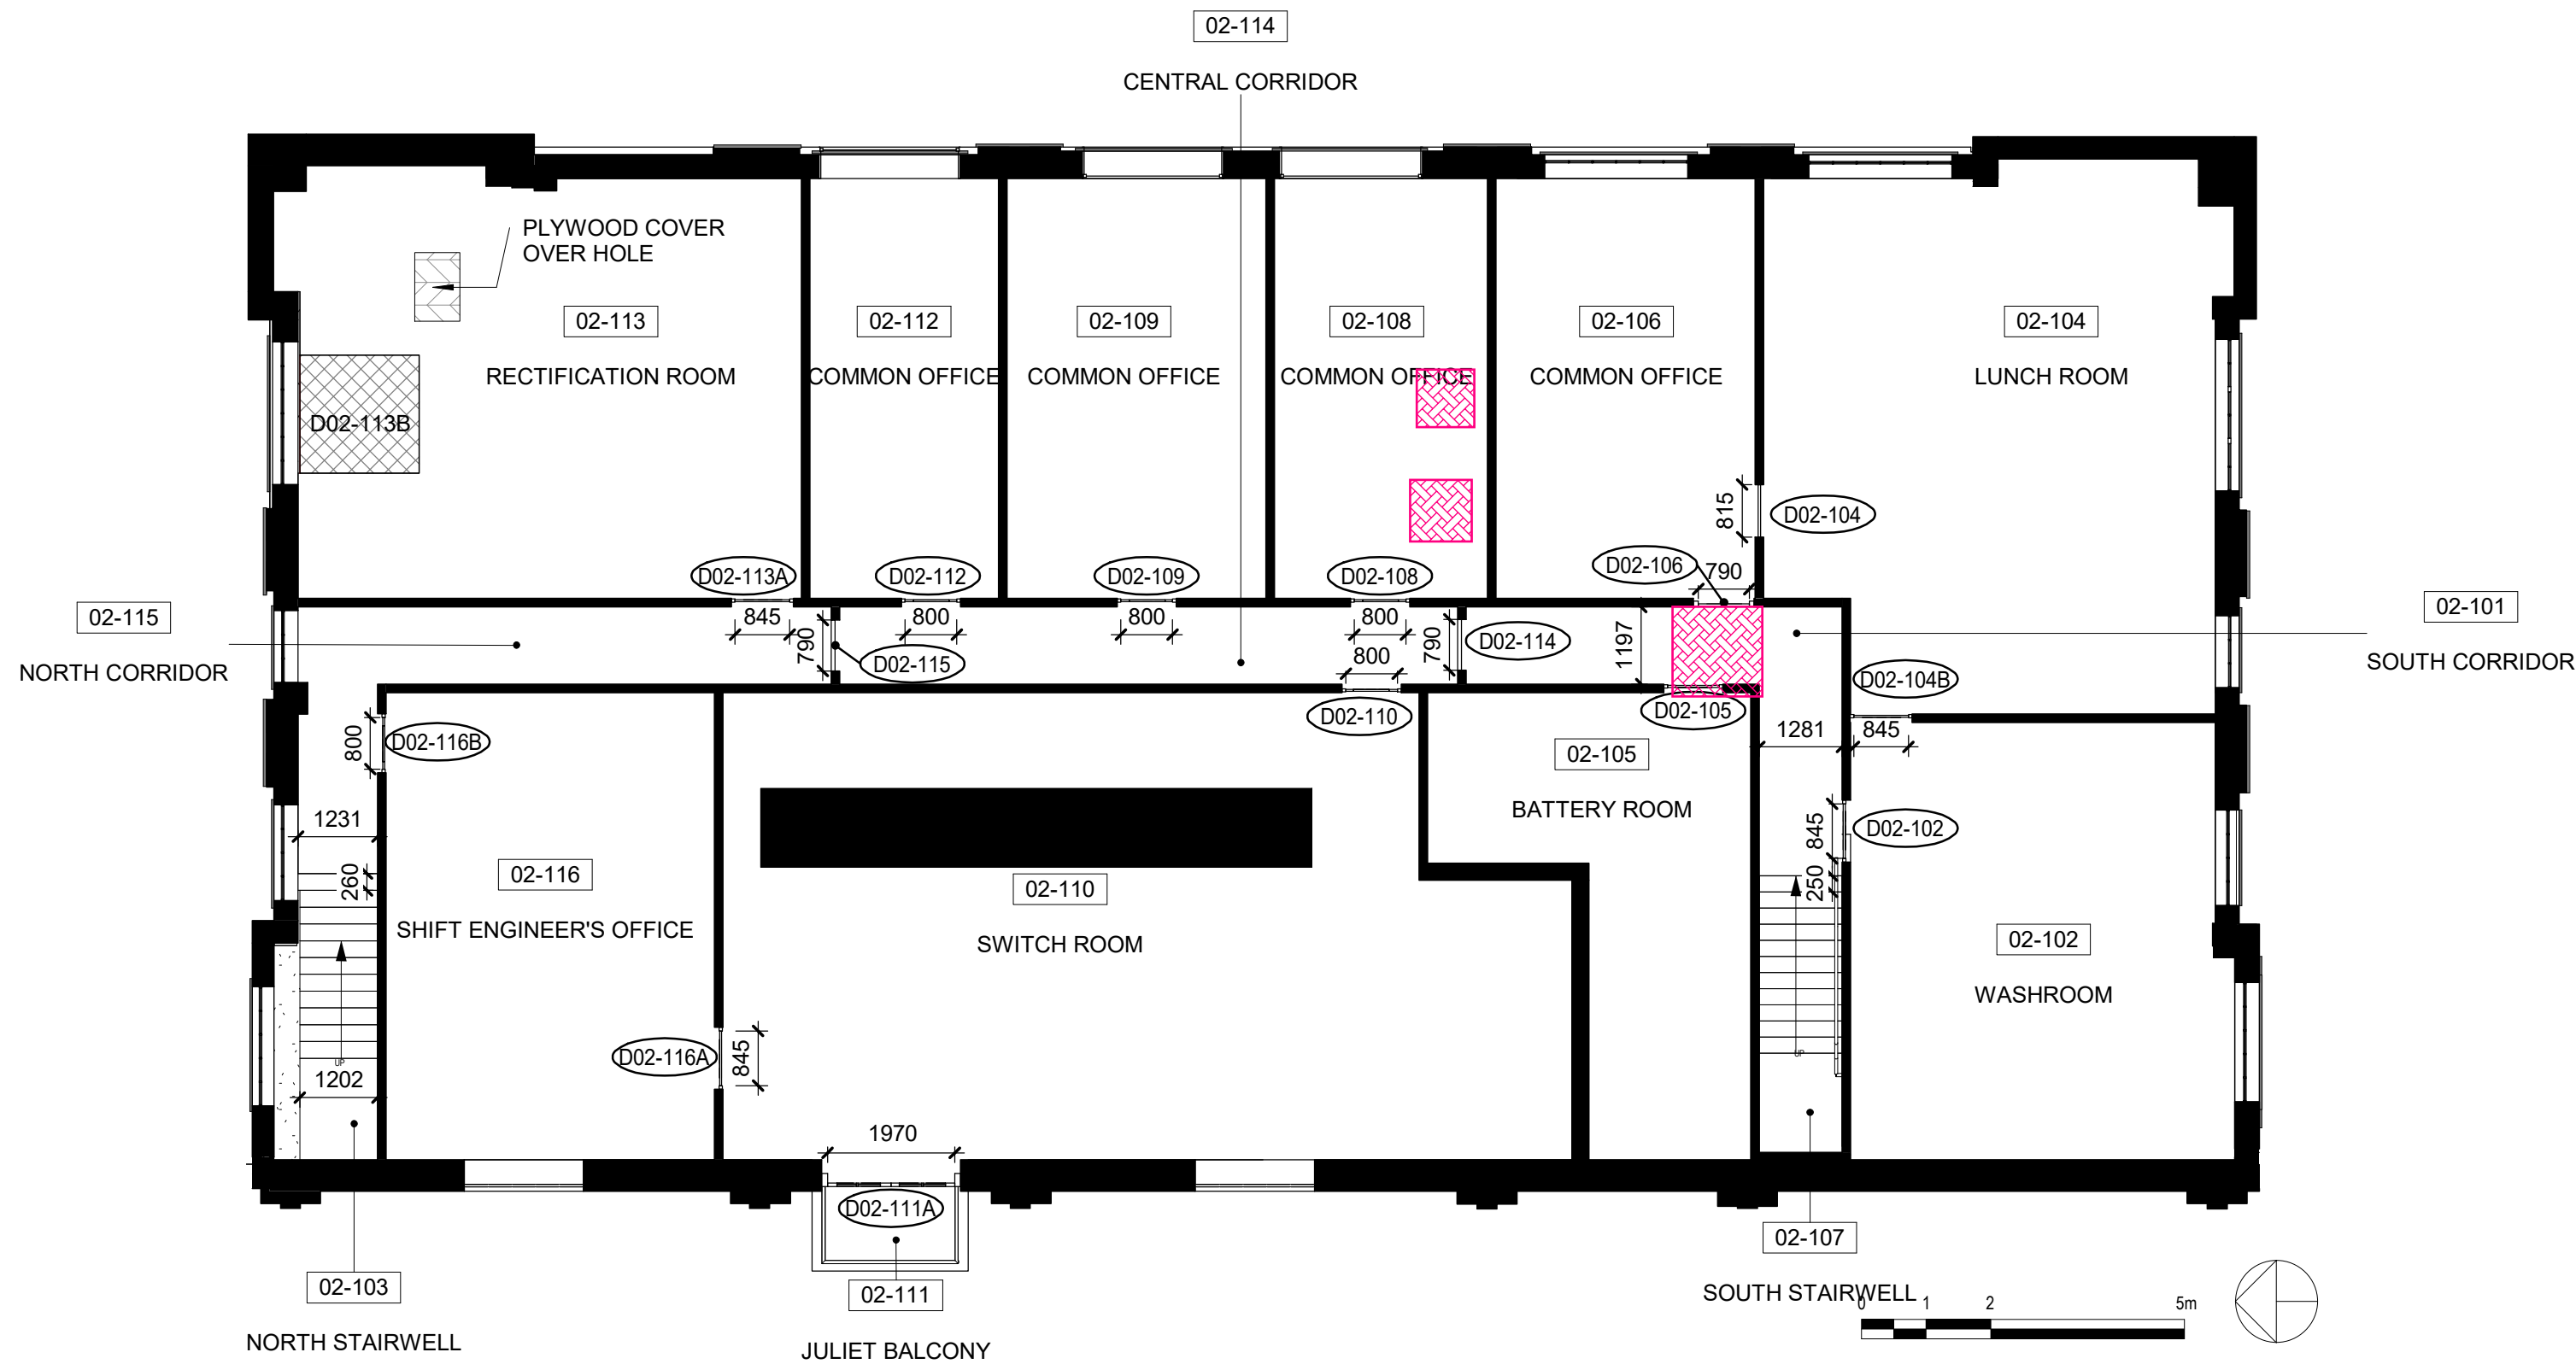

02 - SWITCH HOUSE REFLECTED CEILING PLAN
1 : 100

Consultant

PRIME CONSULTANT/ARCHITECTURAL
the marc boutin architectural collaborative inc.
205 9th Avenue SE, Suite 100
Calgary, AB, T2C 0R3
Contact: Richard Colter

HERITAGE
DPS Inc. Architecture & Design
400 Boulevard de Maisonneuve O.
Montreal, QC H3A 1L4
Contact: Evan Ostend

ARCHITECTURAL
Saucier + Perrotte Architectes
7043 Waverly St.
Montreal, QC H2S 3J1
Contact: Anne-Marie Saucier

STRUCTURAL/CIVIL/BUILDING ENVELOPE
Reed Jones Christofferson LLP
17415 102 Ave NW #100,
Edmonton, AB T5S 1J6
Contact: Frank Cavaliere (S), John Balla (C),
Nick Trovati (RE)

MECHANICAL/ELECTRICAL
Williams Engineering Canada Inc.
10085 Jasper Ave #200,
Edmonton, AB T5J 3B1
Contact: Sheldon Samborsky (M), Ben Rajewski (E)

BUILDING/FIRE CODE
Jensen Hughes
5855 9 St SE #106,
Calgary, AB T2H 1Z9
Contact: Kyle Duckworth

COST
BTY Group
404 8 Ave SW #645,
Calgary, AB T2P 0R9
Contact: Michael Gabet

INDIGENITY
Nahwegahnee
1205 - 10903 103 Ave NW,
Edmonton, Alberta, T5K 2X6
Contact: Hunter Cardinal



CONSULTANT PROJECT 20008

Seal

Permit

PRELIMINARY NOT FOR CONSTRUCTION



ROSSDALE POWER PLANT
ADVANCED ASSESSMENT AND
PRIORITY REHABILITATION -
HISTORIC BUILDING RECORD

CP-9496

Department INTEGRATED INFRASTRUCTURE SERVICES

No.	Description	Date
1	CONDITIONS ASSESSMENT	2021-03-06
2	CONDITIONS ASSESSMENT	2021-03-07
3	BUILDING RECORD	2021-04-23

Location ID ROS 105, ROS106, ROS107

Description LOW PRESSURE PLANT -
CONDITIONS ASSESSMENT

Drawing Title ROS105 SWITCH HOUSE 02
REFLECTED CEIING PLAN


Discipline	HERITAGE	Drawn	BD
Volume		Drawing	
Sheet	H551	Number	
File			

Conditions Legend


Concrete Deterioration

Missing Section


The Conditions Legend is specific to the subject building of each report and conditions drawing set

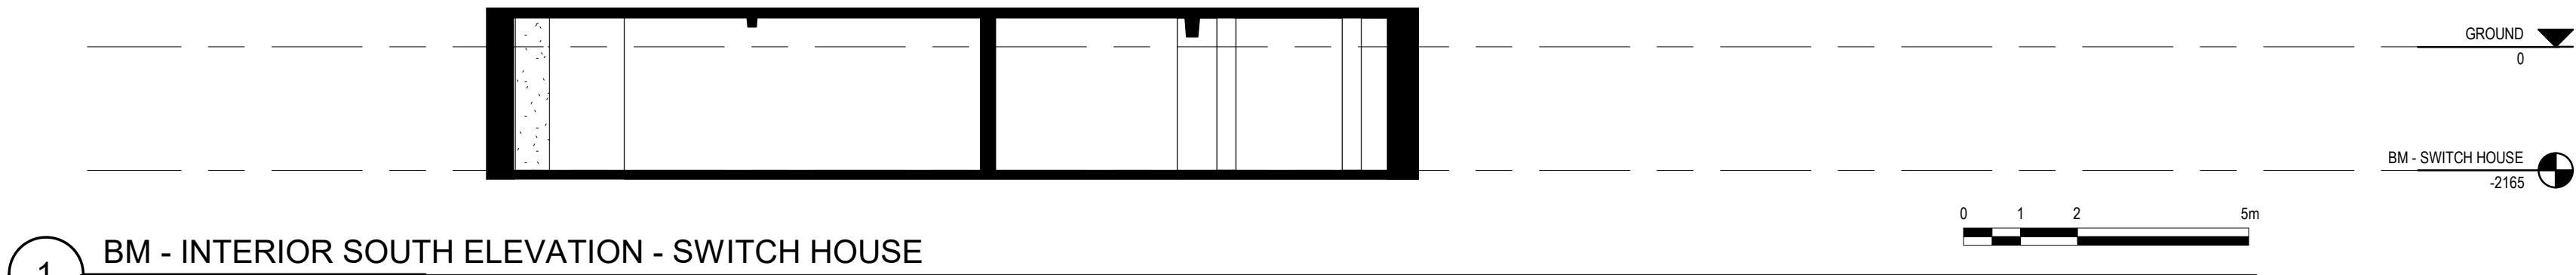


1 BM - INTERIOR SOUTH ELEVATION - SWITCH HOUSE
1 : 100

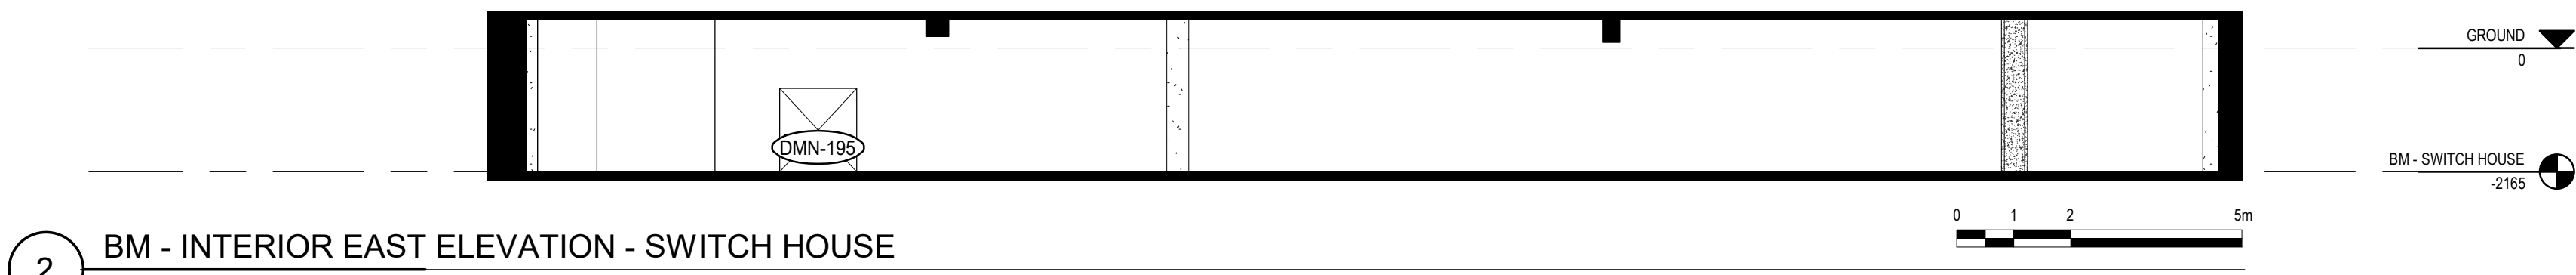

2 BM - INTERIOR EAST ELEVATION - SWITCH HOUSE
1 : 100

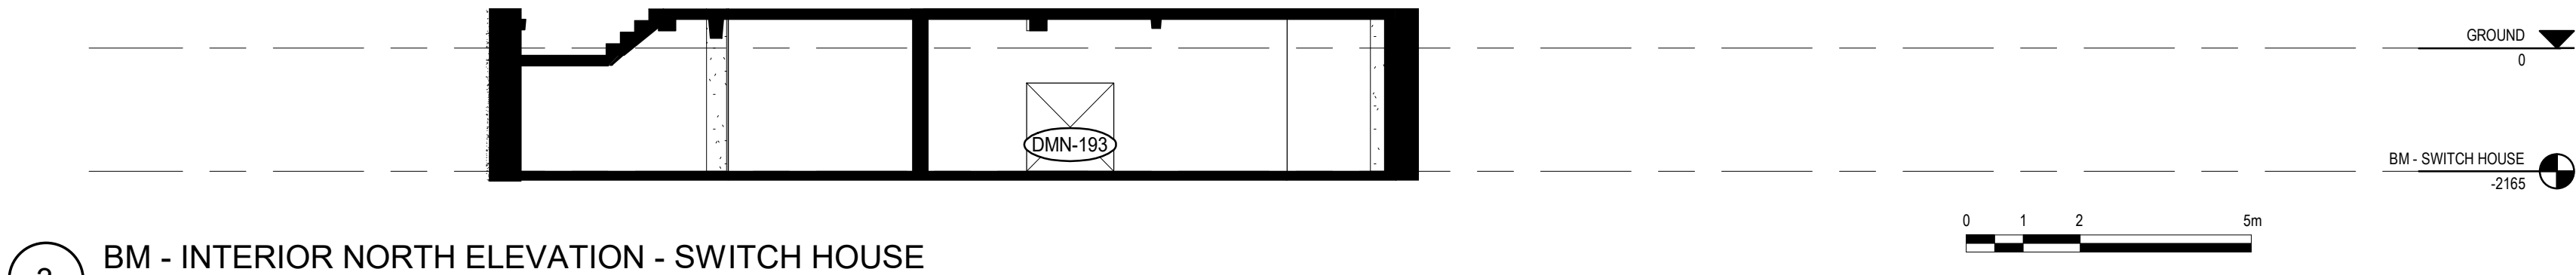

3 BM - INTERIOR NORTH ELEVATION - SWITCH HOUSE
1 : 100

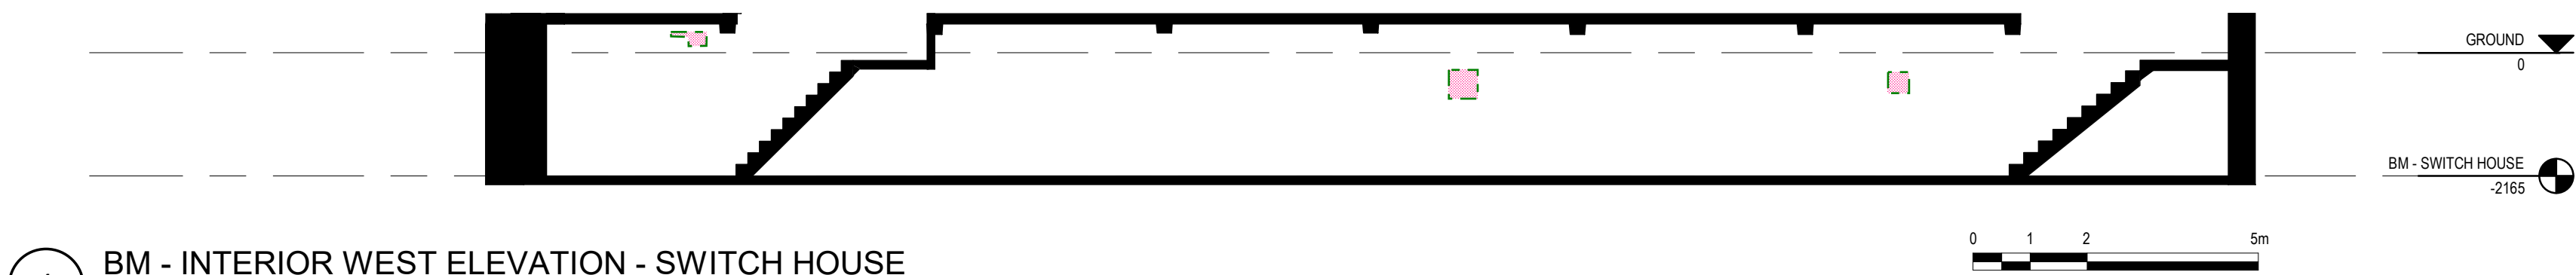

4 BM - INTERIOR WEST ELEVATION - SWITCH HOUSE
1 : 100

HATCH LEGEND

- CONCRETE
- METAL
- PLYWOOD
- OPEN TO BELOW
- MASKED REGION
- PROJECTING SURFACE
- CUT SURFACE

Consultant

PRIME CONSULTANT/ARCHITECTURAL
the marc boutin architectural collaborative inc.
205 9th Avenue SE, Suite 100
Calgary, AB, T2C 0R3
Contact: Richard Cotter

MECHANICAL/ELECTRICAL
Williams Engineering Canada Inc.
10085 Jasper Ave #200,
Edmonton, AB T5J 3B1
Contact: Sheldon Samborsky (M), Ben Rajewski (E)

HERITAGE
DPS Inc. Architecture & Design
400 Boulevard de Maisonneuve O,
Montreal, QC H3A 1L4
Contact: Evan Ostend

BUILDING/FIRE CODE
Jensen Hughes
5855 9 St SE #106,
Calgary, AB T2H 1Z9
Contact: Kyle Duckworth

ARCHITECTURAL
Saucier + Perrotte Architectes
7043 Waverly St,
Montreal, QC H2S 3J1
Contact: Anne-Marie Saucier

COST
BTY Group
404 8 Ave SW #645,
Calgary, AB T2P 0R9
Contact: Michael Giesbert

STRUCTURAL/CIVIL/BUILDING ENVELOPE
Reed Jones Christofferson Ltd
17415 102 Ave NW #100,
Edmonton, AB T5S 1J6
Contact: Frank Cavaliere (S), John Balla (C),
Nick Trovati (RE)

INDIGENITY
Nahayewin
1205 - 10903 103 Ave NW,
Edmonton, Alberta, T5K 2X6
Contact: Hunter Cardinal

CONSULTANT PROJECT 20008

Seal

Permit

PRELIMINARY NOT FOR CONSTRUCTION



ROSSDALE POWER PLANT
ADVANCED ASSESSMENT AND
PRIORITY REHABILITATION -
HISTORIC BUILDING RECORD

CP-9496

Department INTEGRATED INFRASTRUCTURE SERVICES

No.	Description	Date
1	BUILDING RECORD	2021-01-19
2	BUILDING RECORD	2021-01-27
3	BUILDING RECORD	2021-02-09
4	BUILDING RECORD	2021-02-19
5	CONDIONS ASSESSMENT	2021-03-06
6	CONDIONS ASSESSMENT	2021-03-07
7	BUILDING RECORD	2021-03-12
8	BUILDING RECORD	2021-04-23

Location ID ROS 105, ROS106, ROS107


Description LOW PRESSURE PLANT -
CONDITIONS ASSESSMENT

Drawing Title ROS105 SWITCH HOUSE BM
INTERIOR ELEVATIONS


Discipline	HERITAGE	Drawn	BD
Volume		Drawing	
Sheet	H650	Number	
File			




1 MN - INTERIOR SOUTH ELEVATION - SWITCH HOUSE
1 : 100

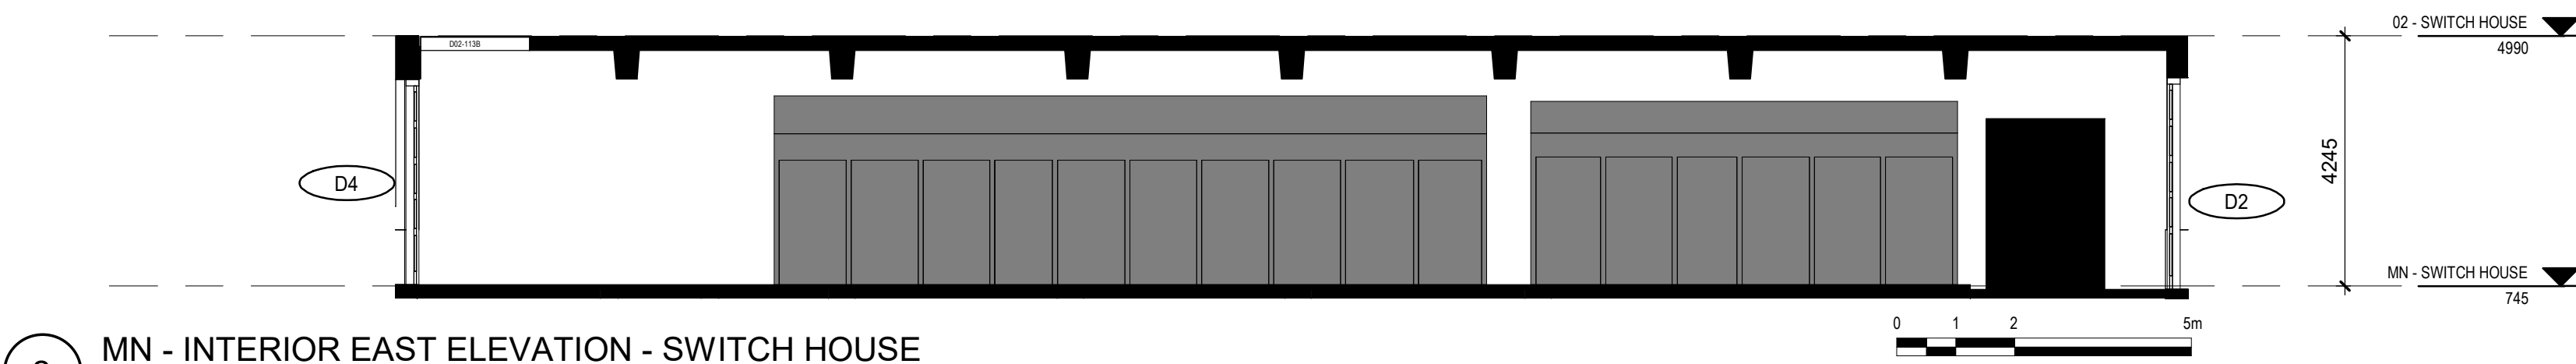

2 MN - INTERIOR EAST ELEVATION - SWITCH HOUSE
1 : 100

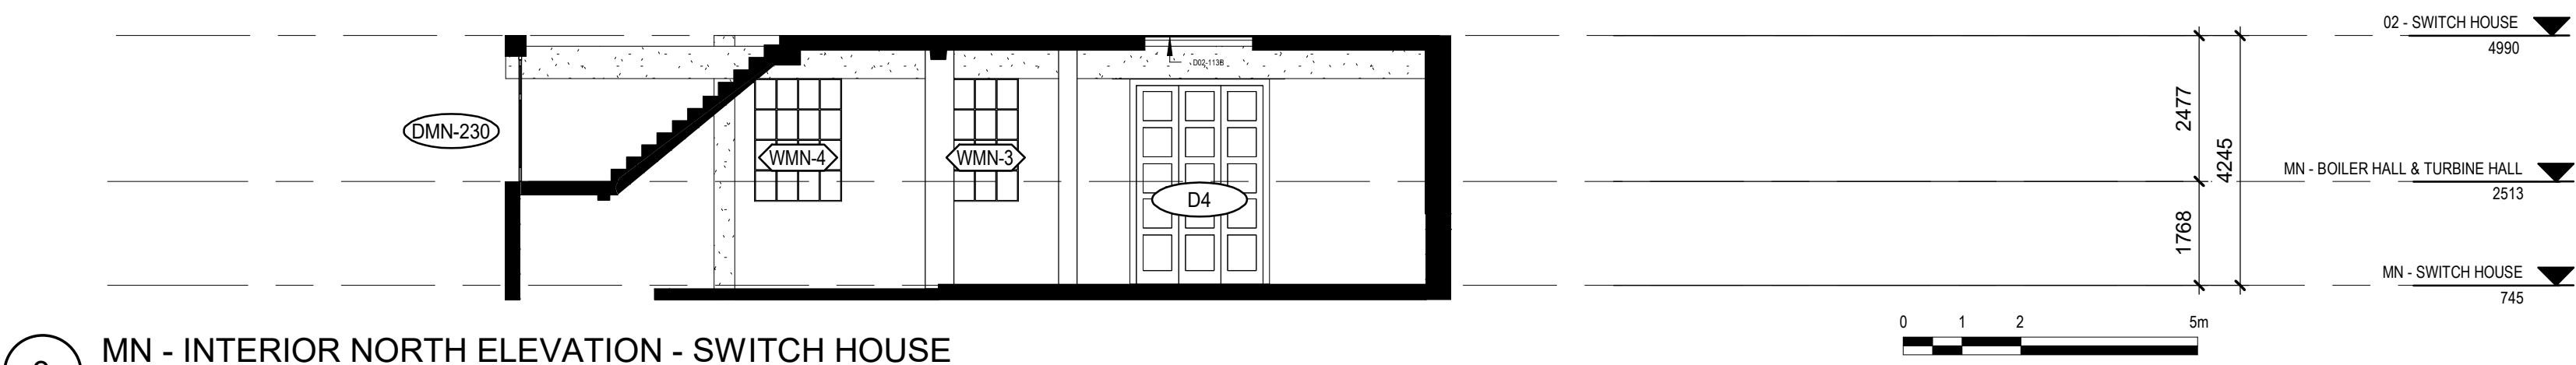

3 MN - INTERIOR NORTH ELEVATION - SWITCH HOUSE
1 : 100

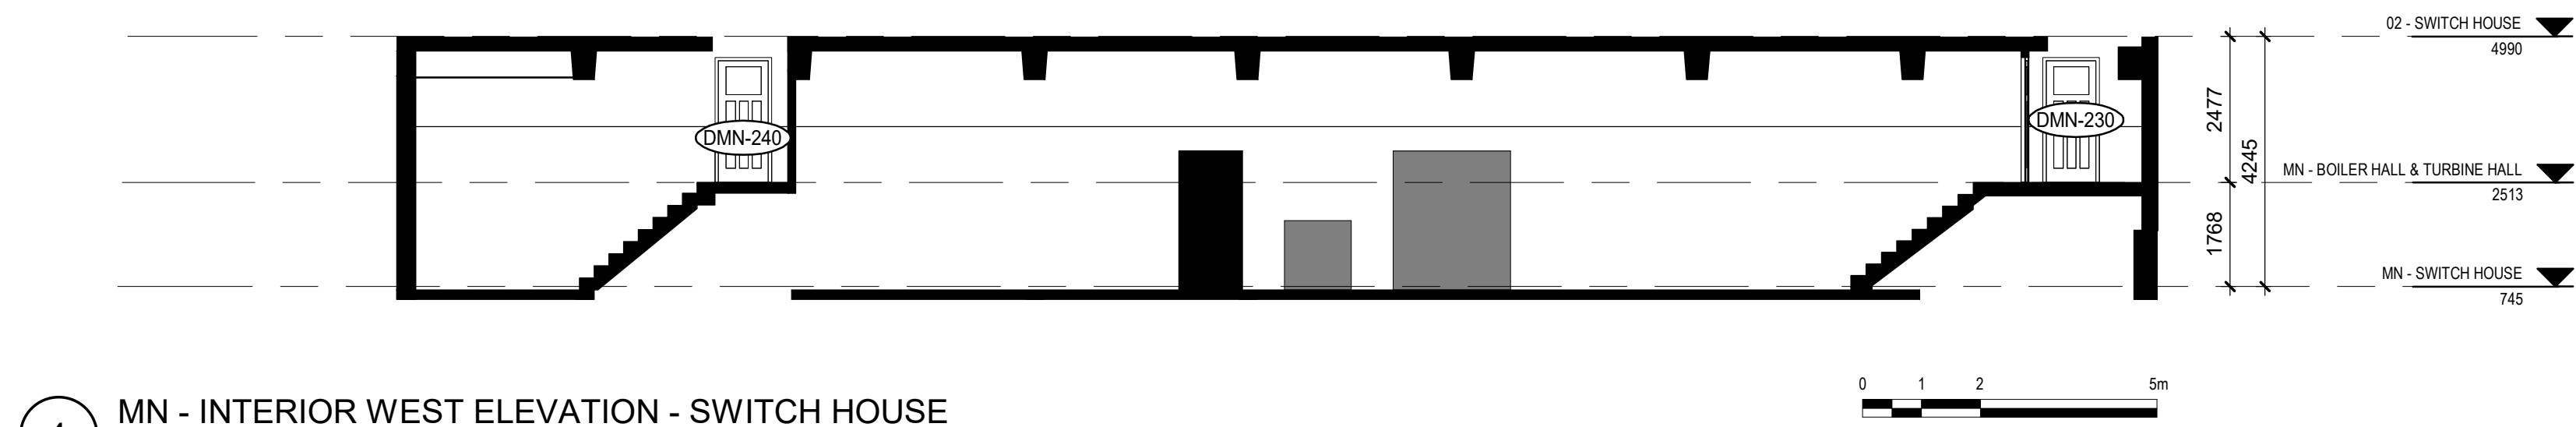

4 MN - INTERIOR WEST ELEVATION - SWITCH HOUSE
1 : 100

HATCH LEGEND

- CONCRETE
- METAL
- PLYWOOD
- OPEN TO BELOW
- MASKED REGION
- PROJECTING SURFACE
- CUT SURFACE

Consultant

PRIME CONSULTANT/ARCHITECTURAL
the marc boutin architectural collaborative inc.
10085 Jasper Ave #200,
Edmonton, AB T5C 0R3
Contact: Richard Colter

MECHANICAL/ELECTRICAL
Williams Engineering Canada Inc.
205 9th Avenue SE, Suite 100
Edmonton, AB T5J 3B1
Contact: Sheldon Samborsky (M), Ben Rajewski (E)

HERITAGE
DFS Inc. Architecture & Design
400 Boulevard de Maisonneuve O,
Montreal, QC H3A 1L4
Contact: Evan Ostend

ARCHITECTURAL
Saucier + Perrotte Architectes
7043 Waverly St.
Montreal, QC H2S 3J1
Contact: Anne-Marie Saucier

STRUCTURAL/CIVIL/BUILDING ENVELOPE
Reed Jones Christofferson Ltd
17415 102 Ave NW #100,
Edmonton, AB T5S 1J6
Contact: Frank Cavaliere (S), John Balla (C),
Nick Trovati (RE)

BUILDING/FIRE CODE
Jensen Hughes
5855 9 St SE #106,
Calgary, AB T2H 1Z9
Contact: Kyle Duckworth

COST
BTY Group
404 8 Ave SW #645,
Calgary, AB T2P 0R9
Contact: Michael Giesert

INDIGENITY
Nahayewit
1205 - 10903 103 Ave NW,
Edmonton, Alberta, T5K 2X6
Contact: Hunter Cardinal

CONSULTANT PROJECT 20008

Seal Permit

PRELIMINARY NOT FOR CONSTRUCTION

Edmonton

ROSSDALE POWER PLANT
ADVANCED ASSESSMENT AND
PRIORITY REHABILITATION -
HISTORIC BUILDING RECORD

CP-9496

Department INTEGRATED INFRASTRUCTURE SERVICES

No.	Description	Date
1	BUILDING RECORD	2021-01-19
2	BUILDING RECORD	2021-01-27
3	BUILDING RECORD	2021-02-09
4	BUILDING RECORD	2021-02-19
5	CONDITONS ASSESSMENT	2021-03-06
6	CONDITONS ASSESSMENT	2021-03-07
7	BUILDING RECORD	2021-03-12
8	BUILDING RECORD	2021-04-23

Location ID ROS 105, ROS106, ROS107
Description LOW PRESSURE PLANT -
CONDITIONS ASSESSMENT

Drawing Title ROS105 SWITCH HOUSE MN
INTERIOR ELEVATIONS


Discipline	HERITAGE	Drawn	BD
Volume		Drawing	
Sheet	H651	Number	
File			

Conditions Legend

Finish Deterioration

Missing Section


The Conditions Legend is specific to the subject building of each report and conditions drawing set

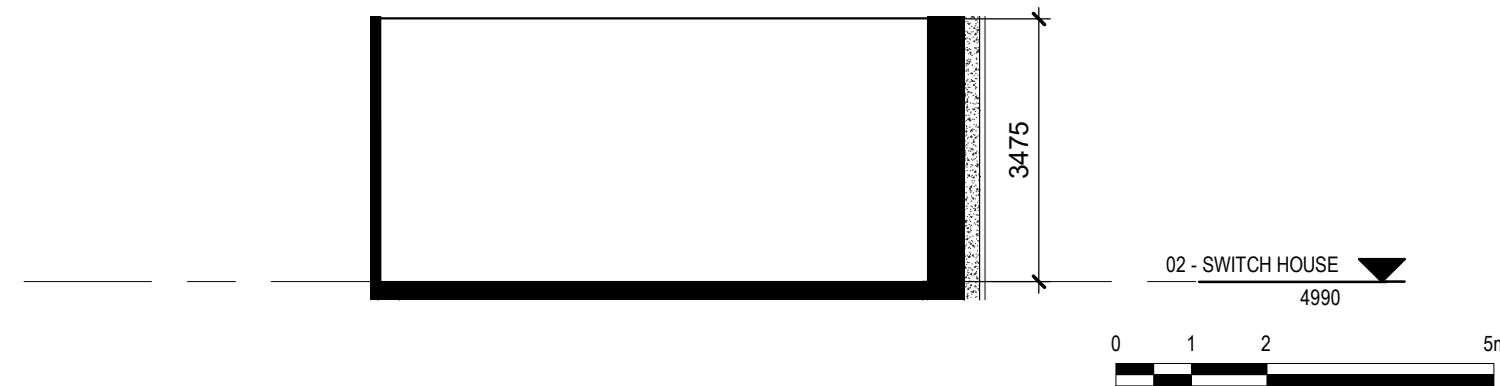


1 02 -SWITCH ROOM - SOUTH ELEVATION - SWITCH HOUSE
1 : 100




2 02- SWITCH ROOM - EAST ELEVATION - SWITCH HOUSE
1 : 100

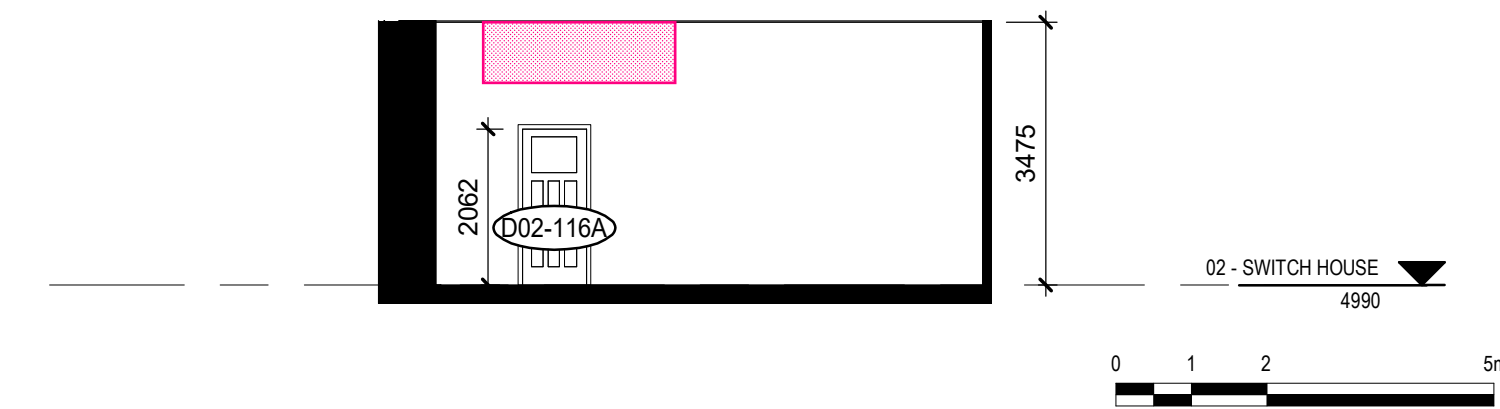


3 02 - SWITCH ROOM - NORTH ELEVATION - SWITCH HOUSE
1 : 100

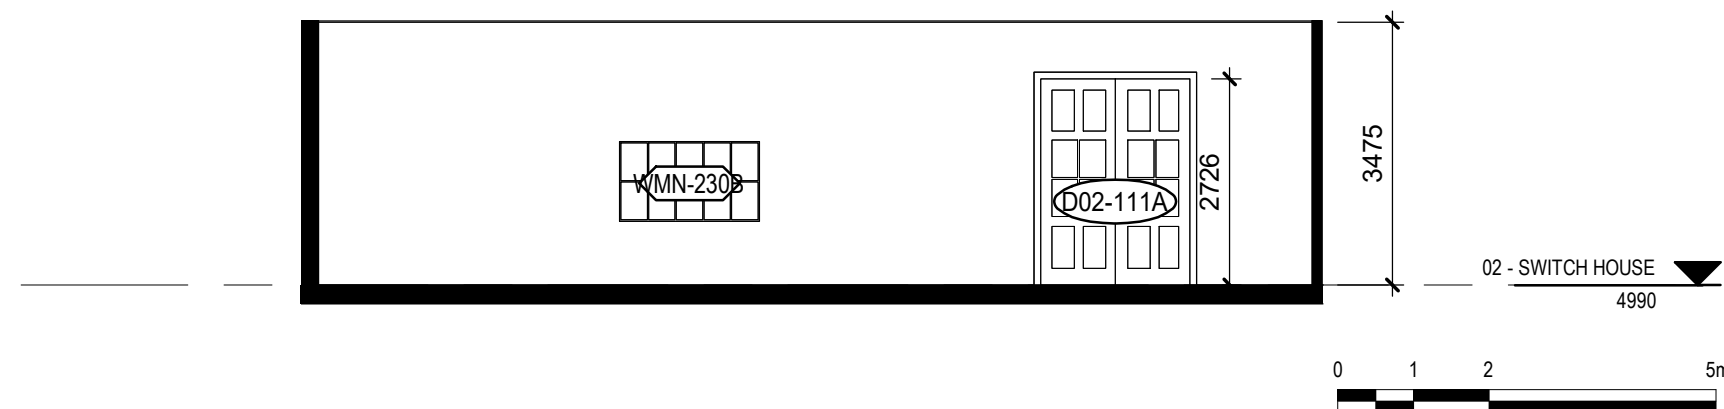


4 02 - SWITCH ROOM - WEST ELEVATION - SWITCH HOUSE
1 : 100

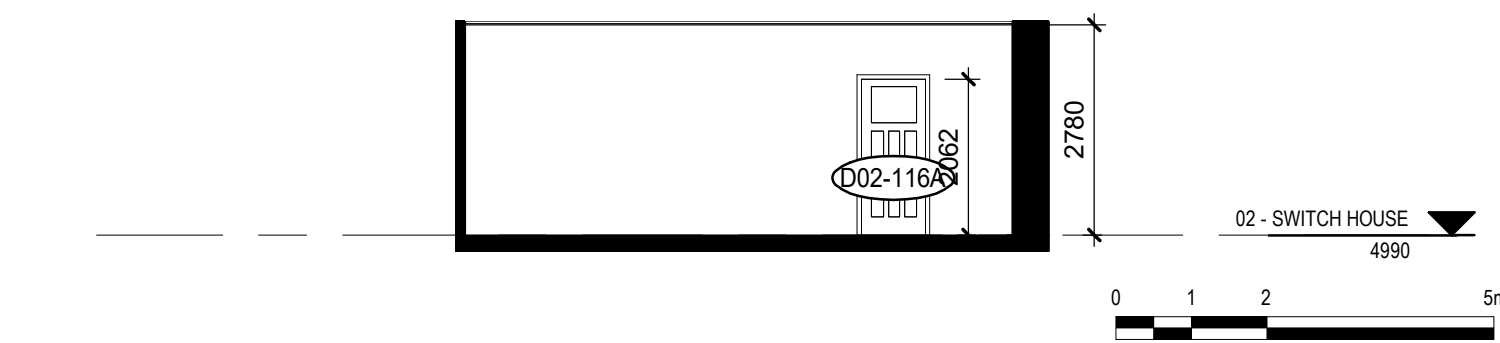


5 02 - SHIFT ENGINEER'S OFFICE - SOUTH ELEVATION - SWITCH HOUSE
1 : 100

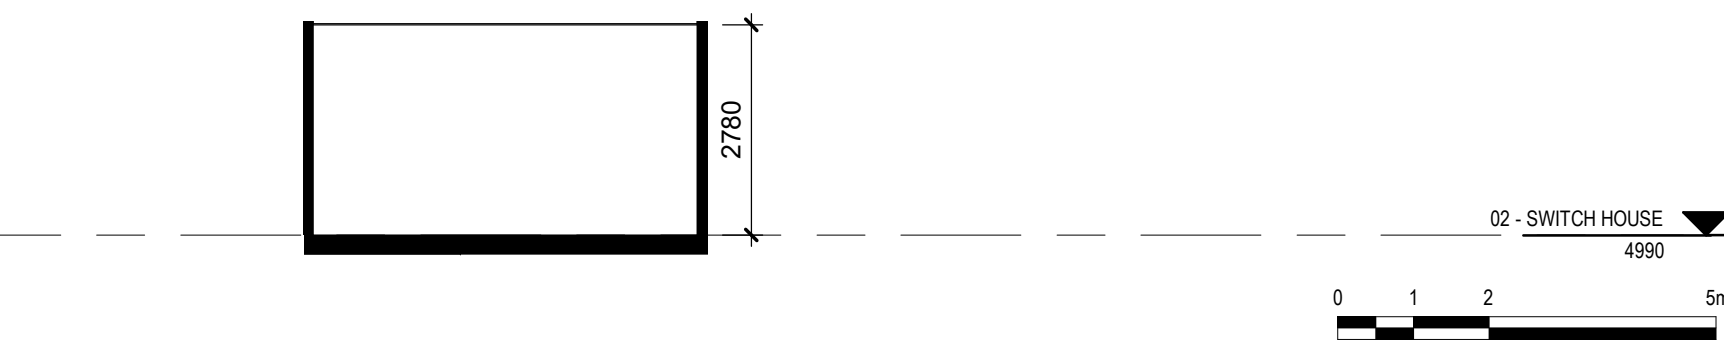

6 02 - SHIFT ENGINEER'S OFFICE - EAST ELEVATION - SWITCH HOUSE
1 : 100

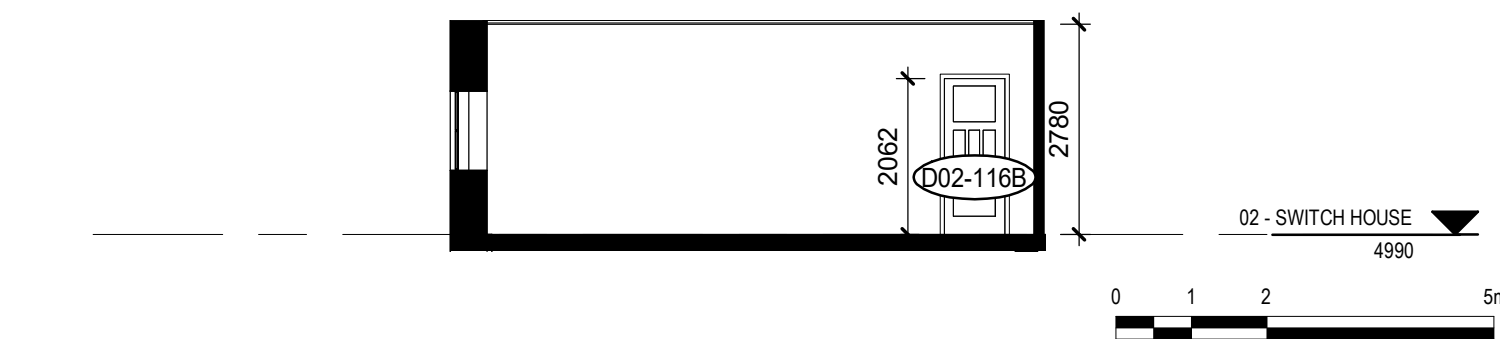

7 02- SHIFT ENGINEER'S OFFICE - NORTH ELEVATION - SWITCH HOUSE
1 : 100

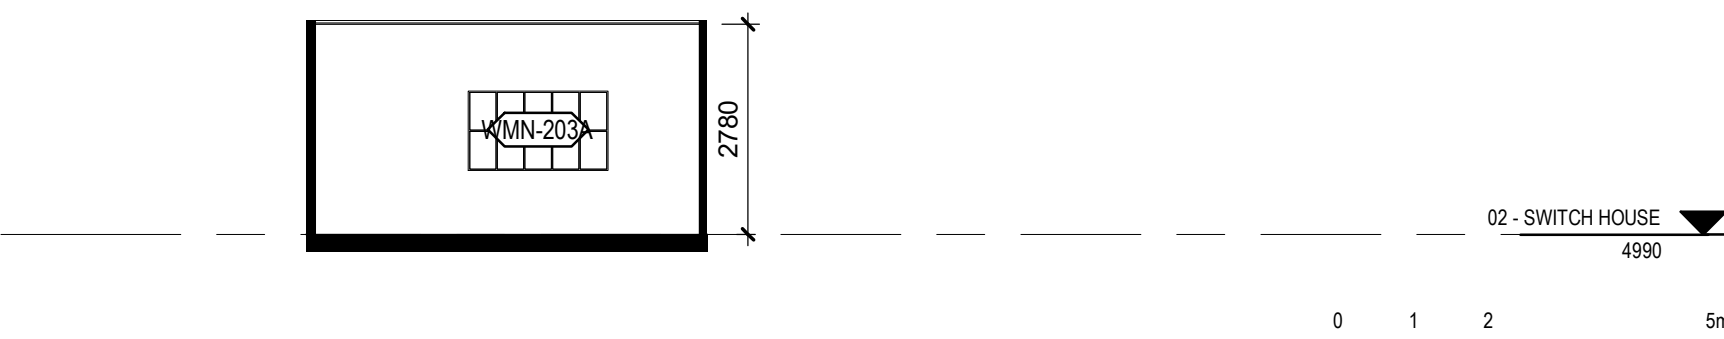

8 02 - SHIFT ENGINEER'S OFFICE - WEST ELEVATION - SWITCH HOUSE
1 : 100

HATCH LEGEND

- CONCRETE
- METAL
- PLYWOOD
- OPEN TO BELOW
- MASKED REGION
- PROJECTING SURFACE
- CUT SURFACE

Consultant

PRIME CONSULTANT/ARCHITECTURAL
the marc boutin architectural collaborative inc.
205 9th Avenue SE, Suite 100
Calgary, AB, T2C 0R3
Contact: Richard Coder

HERITAGE
DPS Inc. Architecture & Design
400 Boulevard de Maisonneuve O,
Montreal, QC H3A 1L4
Contact: Evan Ostlund

ARCHITECTURAL
Saucier + Perrotte Architectes
7043 Waverly St.
Montreal, QC H2S 3J1
Contact: Anne-Marie Saucier

STRUCTURAL/CIVIL/BUILDING ENVELOPE
Reed Jones Christofferson LLP
17415 102 Ave NW #100,
Edmonton, AB T5S 1J6
Contact: Frank Cavaliere (S), John Balla (C),
Nick Trovati (RE)

MECHANICAL/ELECTRICAL
Williams Engineering Canada Inc.
10085 Jasper Ave #200,
Edmonton, AB T5J 3B1
Contact: Sheldon Samborsky (M), Ben Rajewski (E)

BUILDING/FIRE CODE
Jensen Hughes
5855 9 St SE #106,
Calgary, AB T2H 1Z9
Contact: Nyle Duckworth

COST
BTY Group
404 8 Ave SW #645,
Calgary, AB T2P 0R9
Contact: Michael Gabet

INDIGENITY
Nahayewit
1205 - 10903 103 Ave NW,
Edmonton, Alberta, T5K 2X6
Contact: Hunter Cardinal



CONSULTANT PROJECT 20008

Seal	Permit
	PRELIMINARY NOT FOR CONSTRUCTION

ROSSDALE POWER PLANT
ADVANCED ASSESSMENT AND
PRIORITY REHABILITATION -
HISTORIC BUILDING RECORD

CP-9496





Department	INTEGRATED INFRASTRUCTURE SERVICES
------------	------------------------------------

No.	Description	Date
1	BUILDING RECORD	2021-01-19
2	BUILDING RECORD	2021-01-27
3	BUILDING RECORD	2021-02-09
4	BUILDING RECORD	2021-02-19
5	CONDITONS ASSESSMENT	2021-03-06
6	CONDITONS ASSESSMENT	2021-03-07
7	BUILDING RECORD	2021-03-12
8	BUILDING RECORD	2021-04-23

Location ID	ROS 105, ROS106, ROS107
Description	LOW PRESSURE PLANT - CONDITIONS ASSESSMENT

Drawing Title	ROS105 SWITCH HOUSE 02 INTERIOR ELEVATIONS -
---------------	---

Discipline	HERITAGE	Drawn	BD
Volume		Drawing Number	
Sheet	H652		
File			

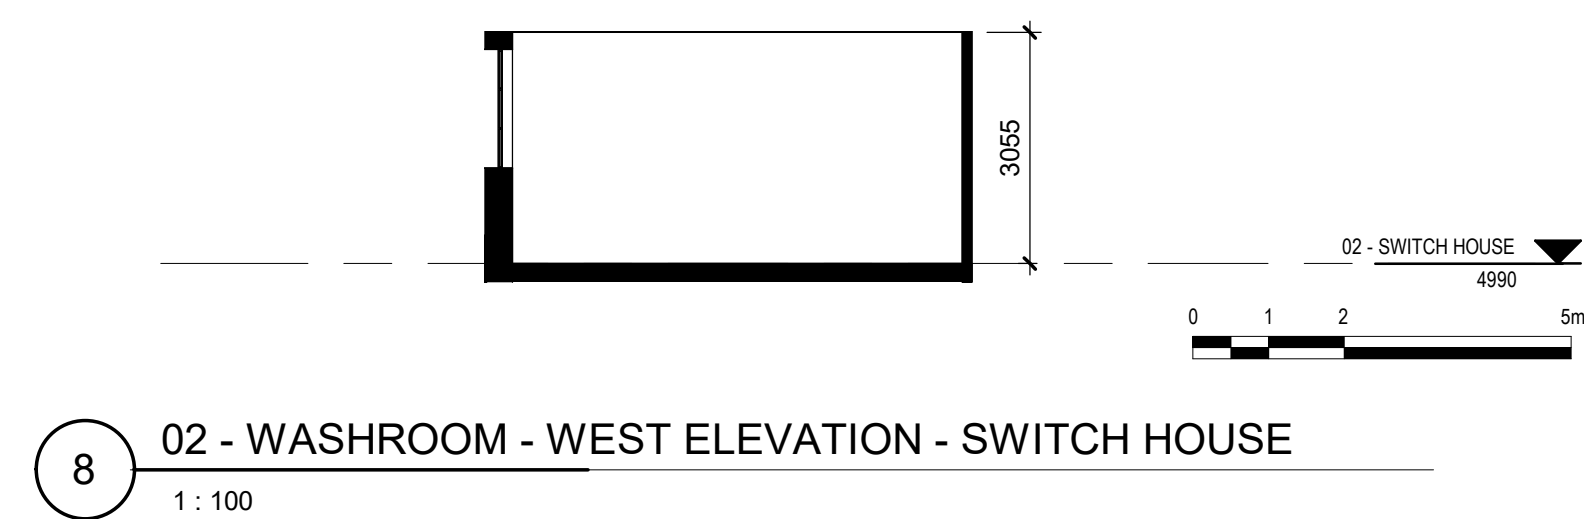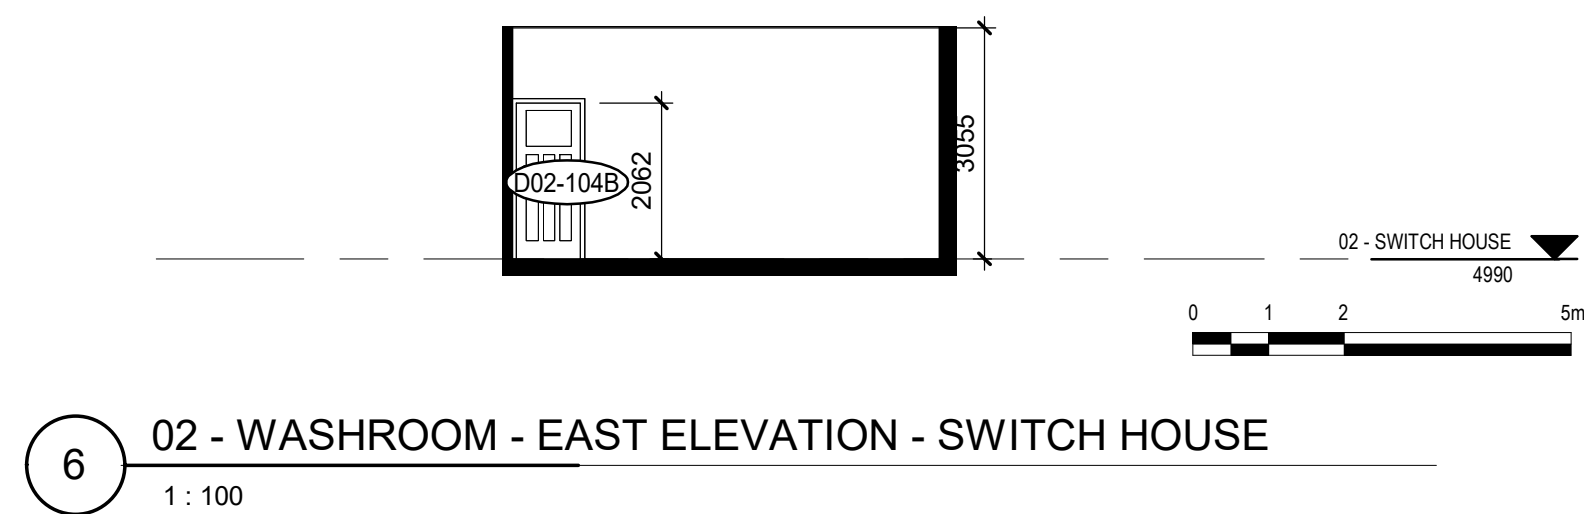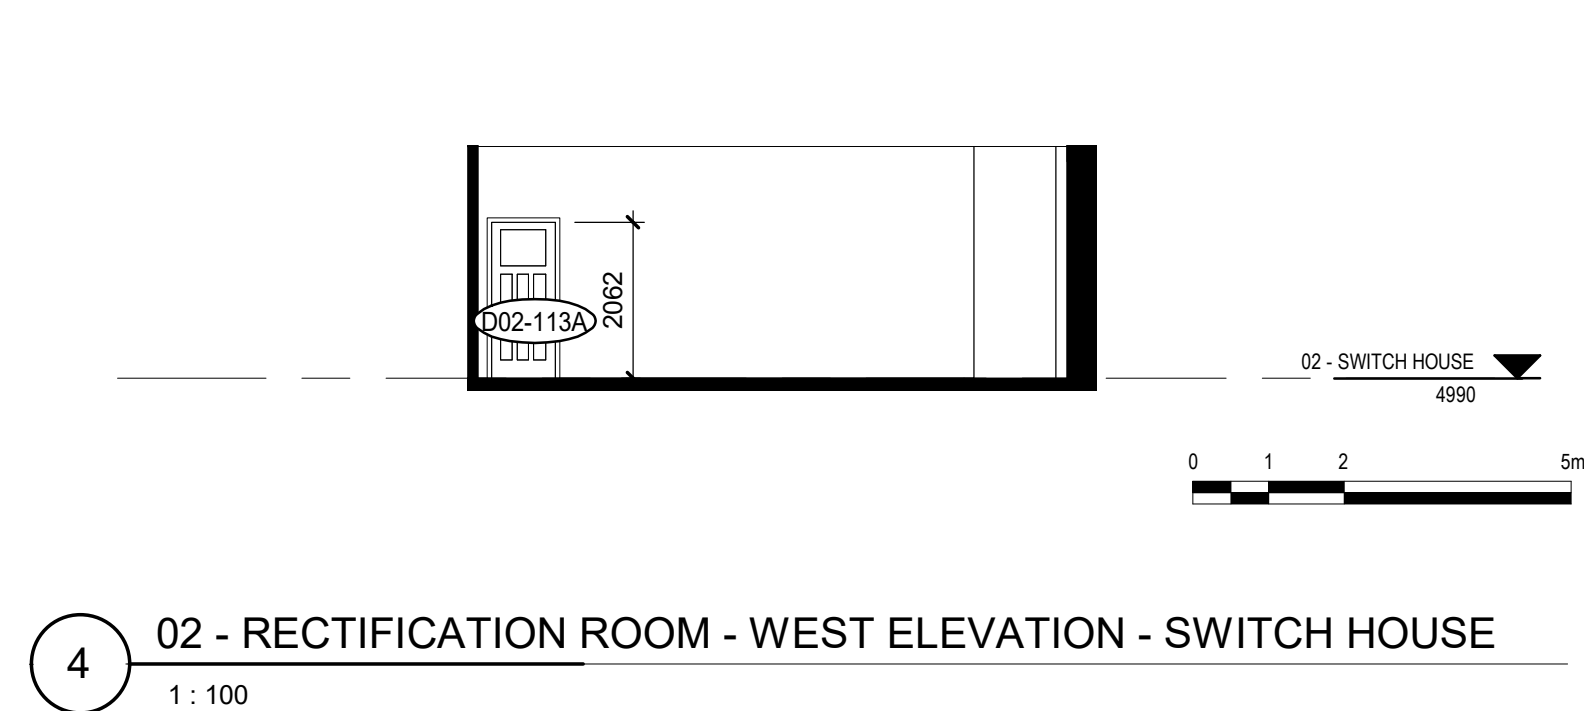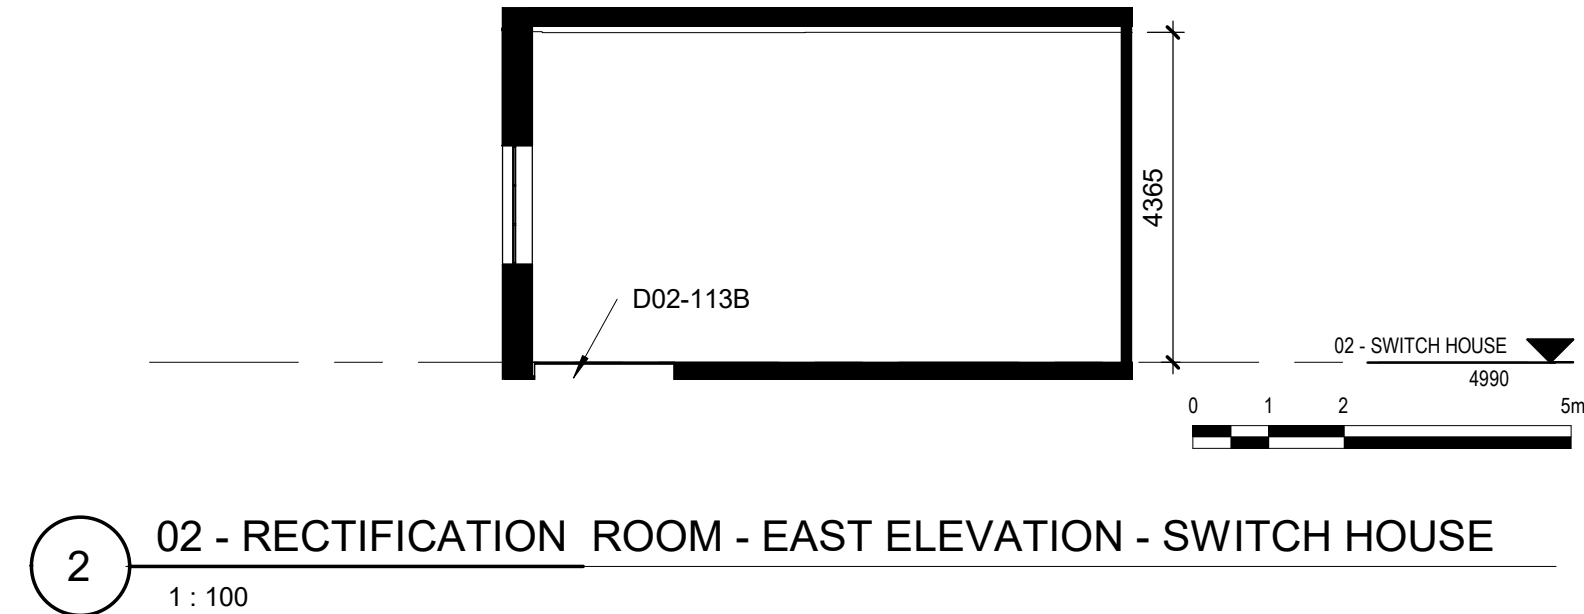

Consultant

PRIME CONSULTANT/ARCHITECTURAL
the marc boutin architectural collaborative inc.
 265 9th Avenue SE, Suite 100
 Calgary, AB T2S 0R3
 Contact: Richard Côté

HERITAGE
DFS inc. Architecture & Design
 400 Boulevard de Maisonneuve O.
 Montréal, QC H3K 1L4
 Contact: Evan Oland

ARCHITECTURAL
Saucer + Perotte Architects
 7045 Waverly St.
 Montréal, QC H2S 3J1
 Contact: Anne-Marie Saucier

STRUCTURAL/CIVIL/BUILDING ENVELOPE
Read Jones+Crosstoffer Ltd.
 17415 102 Ave NW #100,
 Edmonton, AB T5C 1L8
 Contact: Frank Cavaliere (S), John Ballia (C),
 John Tarr

MECHANICAL/ELECTRICAL
Williams Engineering Canada Inc.
 10065 Jasper Ave #200,
 Edmonton, AB T5J 3R1
 Contact: Shellen Samarsky (M), Ben Rajewski (E)

BUILDING/ENVELOPE CODE
Jensen Hughes
 5855 9th St SE #106,
 Calgary AB T2H 1Z9
 Contact: Kyle Duckworth

COST
BTY Group
 404 4 Ave SW #645,
 Calgary AB T2P 0R9
 Contact: Michael Gabert

INDUSNETTY
Nahayway
 10205 - 10903 103 Ave NW,
 Edmonton, Alberta, T5C 2G6
 Contact: Hunter Cardinal

The image shows the top section of a document cover. On the left is the City of Edmonton logo, which consists of a blue square with a white stylized 'E' and the word 'Edmonton' in white. To the right of the logo, the title 'ROSSDALE POWER PLANT ADVANCED ASSESSMENT AND PRIORITY REHABILITATION - HISTORIC BUILDING RECORD' is written in a bold, black, sans-serif font, arranged in four lines. Below the title, the identifier 'CP-9496' is printed in a smaller, black, sans-serif font.

Department INTEGRATED INFRASTRUCTURE SERVICES

No.	Description	Date
1	BUILDING RECORD	2021-01-19
2	BUILDING RECORD	2021-01-27
3	BUILDING RECORD	2021-02-09
4	BUILDING RECORD	2021-02-19
5	CONDITONS ASSESSMENT	2021-03-06
6	CONDITONS ASSESSMENT	2021-03-07
7	BUILDING RECORD	2021-03-12
8	BUILDING RECORD	2021-04-23

Location ID	ROS 105, ROS106, ROS107
Description	LOW PRESSURE PLANT - CONDITIONS ASSESSMENT

Drawing Title	ROS105 SWITCH HOUSE 02 INTERIOR ELEVATIONS
------------------	---

Discipline	HERITAGE	Drawn	BD
Volume		Drawing Number	
Sheet	H653		
File			